

RECEIVED

FEB 14 2017

OHIO EPA NEDO



To Whom It May Concern,

Date: 2/7/2017

Subject: Lead or Lead Free in Facility

To the best of my knowledge the Cheese Plant is lead free. It was totally renovated in 2001 both 1<sup>st</sup> level and 2<sup>nd</sup> level. In 1985 the Whey Plant was added onto and every water line was put in with Lead Free solder or black iron pipe threaded or welded.

*Lonnie R. Via*  
Lonnie R. Via

Facilities Manager


Brewster Cheese Company

Entity: Brewster Cheese  
Doc Type: REPORT  
Doc Subtype: \_\_\_\_\_  
Program: DPAGW  
County: STARK  
Secondary ID: OH 7631512  
& DOC in color



PWS ID: DH7631512

Brewster Cheese Well Water System with  
 Locations of possible lead solder

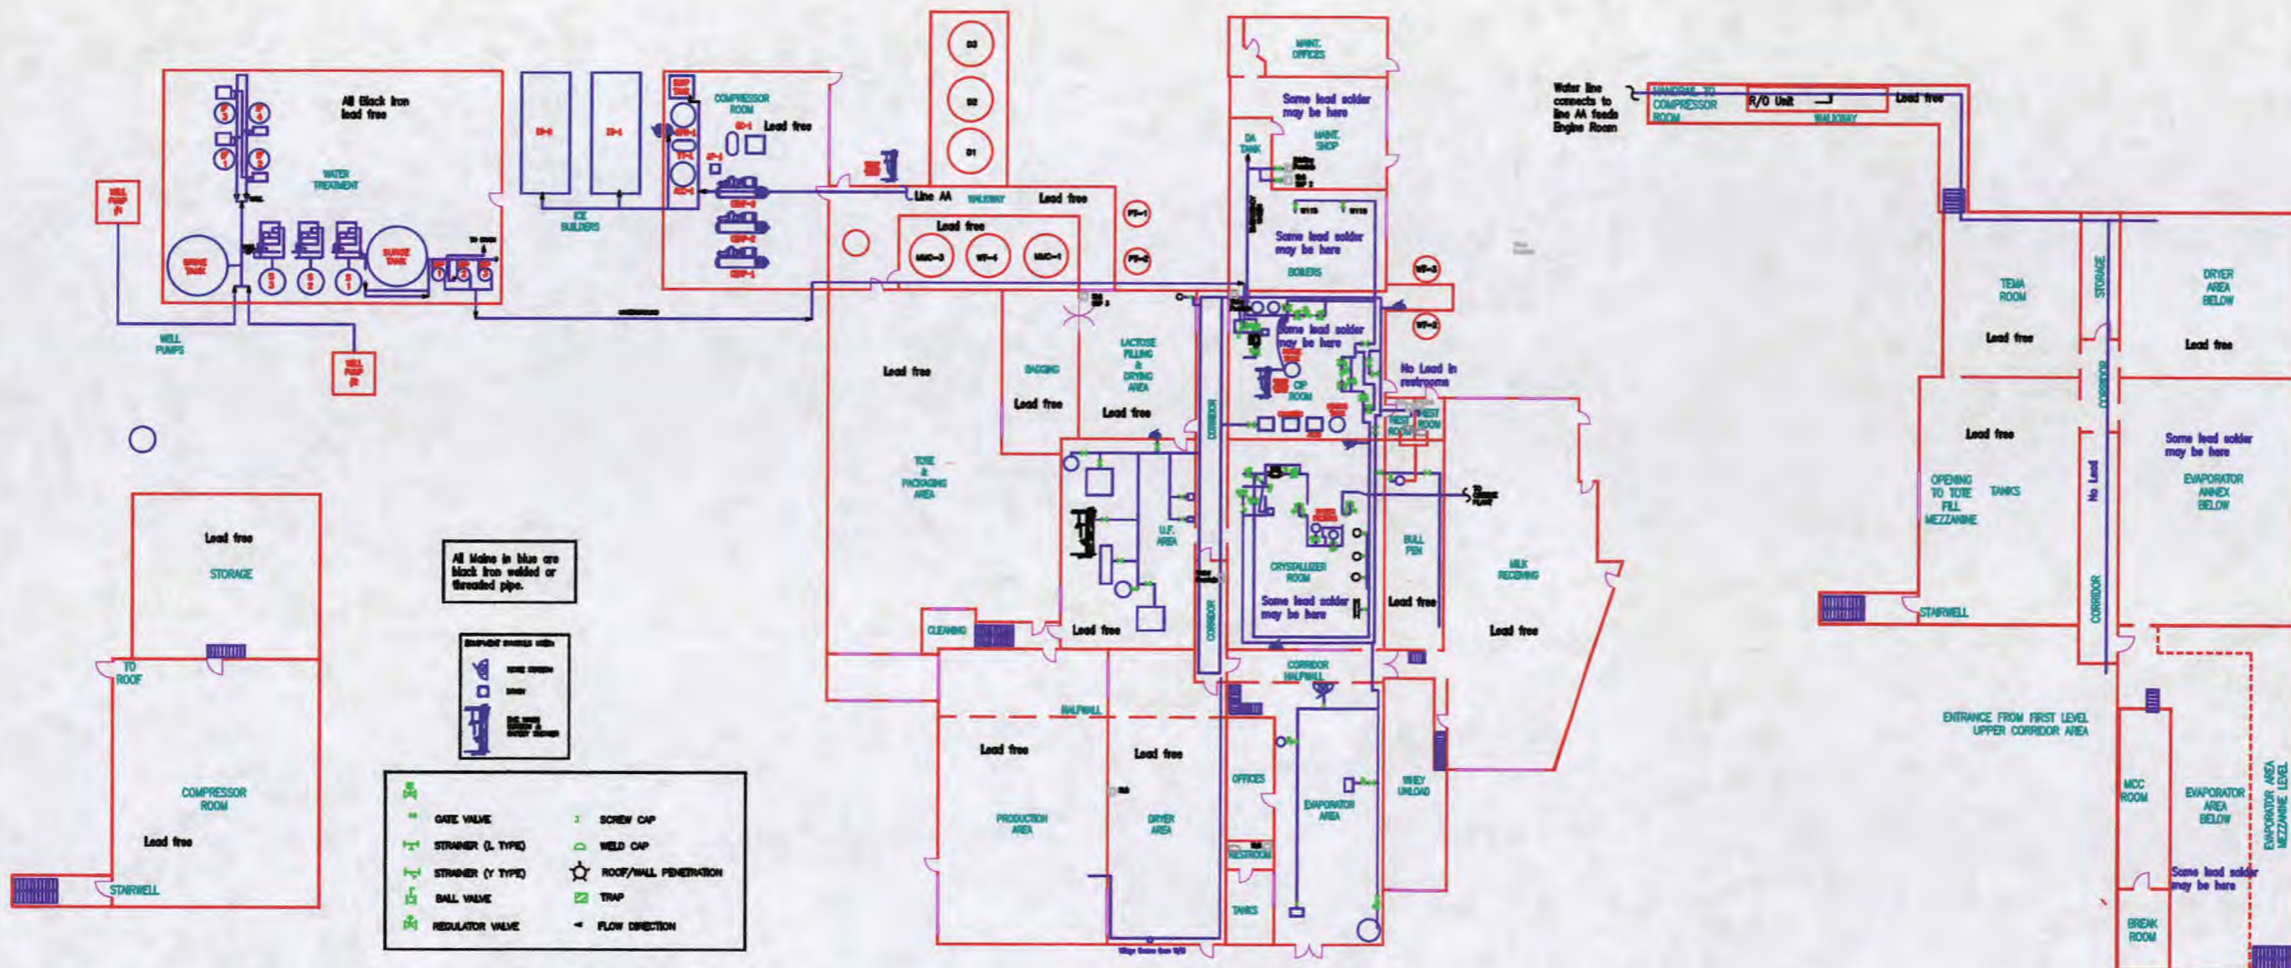

PLAN VIEW THIRD FLOOR WHEY PLANT  
 SCALE: 3/8"=1'-0"

PLAN VIEW FIRST FLOOR WHEY PLANT  
 SCALE: 3/8"=1'-0"

PLAN VIEW SECOND FLOOR WHEY PLANT  
 SCALE: 3/8"=1'-0"


VALVE LIST

NUMBER	TYPE	UNIT	LOCATION	REVISIONS
1001	Gate Valve	100	WELL PUMPS	
1002	Gate Valve	100	WELL PUMPS	
1003	Gate Valve	100	WELL PUMPS	
1100	Gate Valve	100	WELL PUMPS	

WATER PLANS  
 BREWSTER DAIRY  
 WHEY PLANT BREWSTER, OH

DESIGN BY  
 E. WHEELER  
 DATE  
 02-07-10  
 REVISION DATE  
 02-02-17  
 DRAWN DATE  
 02-02-17  
 CLIENT APPROVAL  
 Lorale R. Vot  
 2



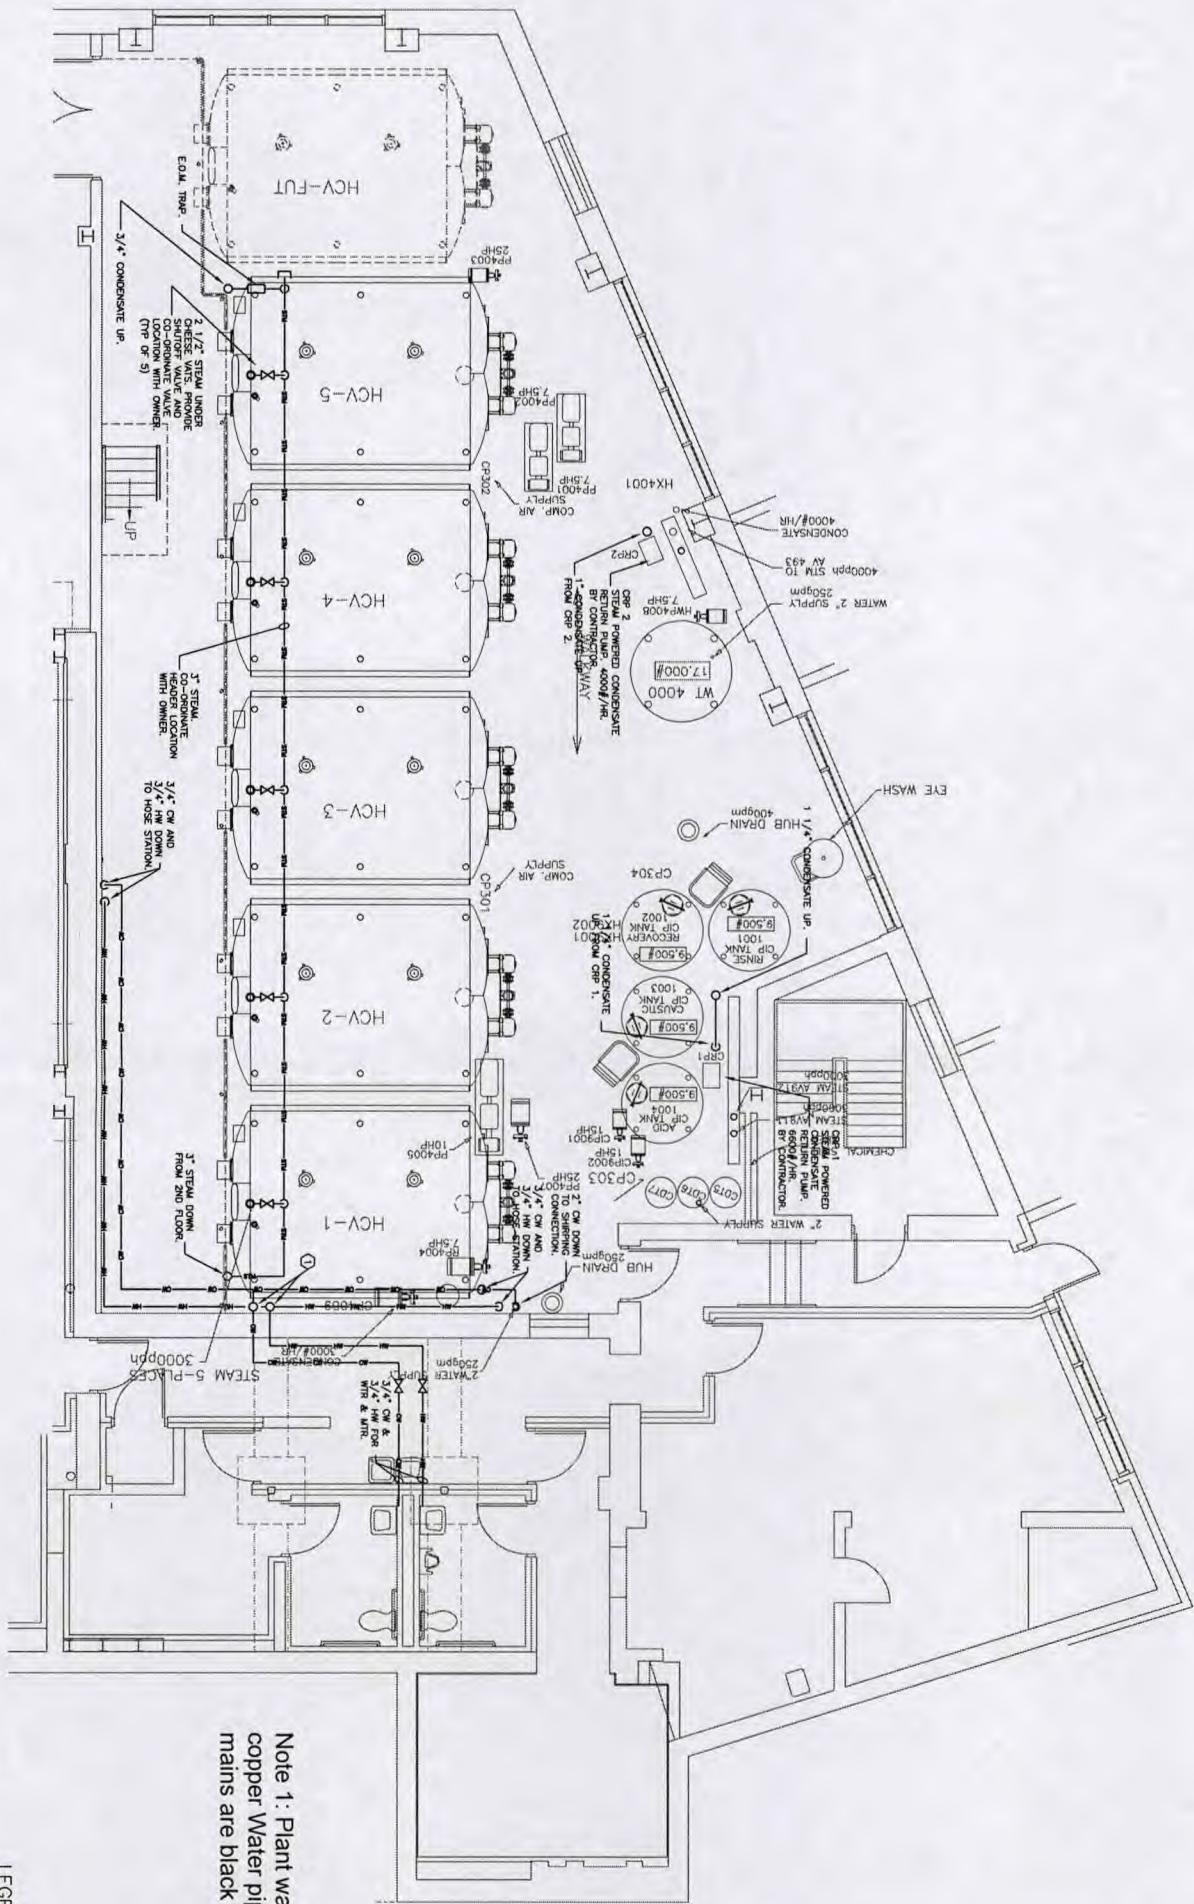

FIRST FLOOR PIPING PLAN  
SCALE: 1/4" = 1'-0"  
NORTH


**DRAWING NOTES**  
 1) 3" CW DOWN FROM 2ND FLOOR - SHUT 2" TO SHIPPING CONNECTION & (2) 3/4" TO (2) HOSE STATIONS.  
 1" HW DOWN - SHUT TO (2) 3/4" HOSE STATIONS.

Note 1: Plant was renovated in 2001 all copper water piping was lead free. All water mains are black iron pipe.

**LEGEND**

 - |   |                         |   |                  |
|---|-------------------------|---|------------------|
| — | EXISTING STEAM          | — | STEAM            |
| — | EXISTING CONDENSATE     | — | CONDENSATE       |
| — | EXISTING HOT WATER      | — | HOT WATER SUPPLY |
| — | EXISTING COLD WATER     | — | HOT WATER RETURN |
| — | EXISTING NATURAL GAS    | — | COLD WATER       |
| — | EXISTING COMPRESSED AIR | — | NATURAL GAS      |
| — | EXISTING CATCHER SUPPLY | — | COMPRESSED AIR   |
| — | EXISTING CATCHER RETURN | — | ICE WATER SUPPLY |
| — |                         | — | ICE WATER RETURN |
| — |                         | — | CATCHER SUPPLY   |
| — |                         | — | CATCHER RETURN   |

1ST FLOOR MECH. PIPING PLAN  
WEST ADDITION



675 South Wabash Avenue  
Brewster, Ohio 44613

Revision					
No.	Description	Date	No.	Description	Date



1385 Tennessee Avenue  
Cincinnati, OH 45229  
Phone 513/641-0320  
Facsimile 513/641-0057  
www.HendonRedmond.com

Engineers ■ Architects ■ Consultants

Drawing Number  
**M1.03**

Date  
7-18-01

Job Number  
3070-601

Scale  
AS SHOWN




Note 1: Plant was renovated in 2001 all copper Water piping was lead free. All water mains are black iron pipe.

LEGEND




FIRST FLOOR PIPING PLAN NORTH  
SCALE: 1/4" = 1'-0"

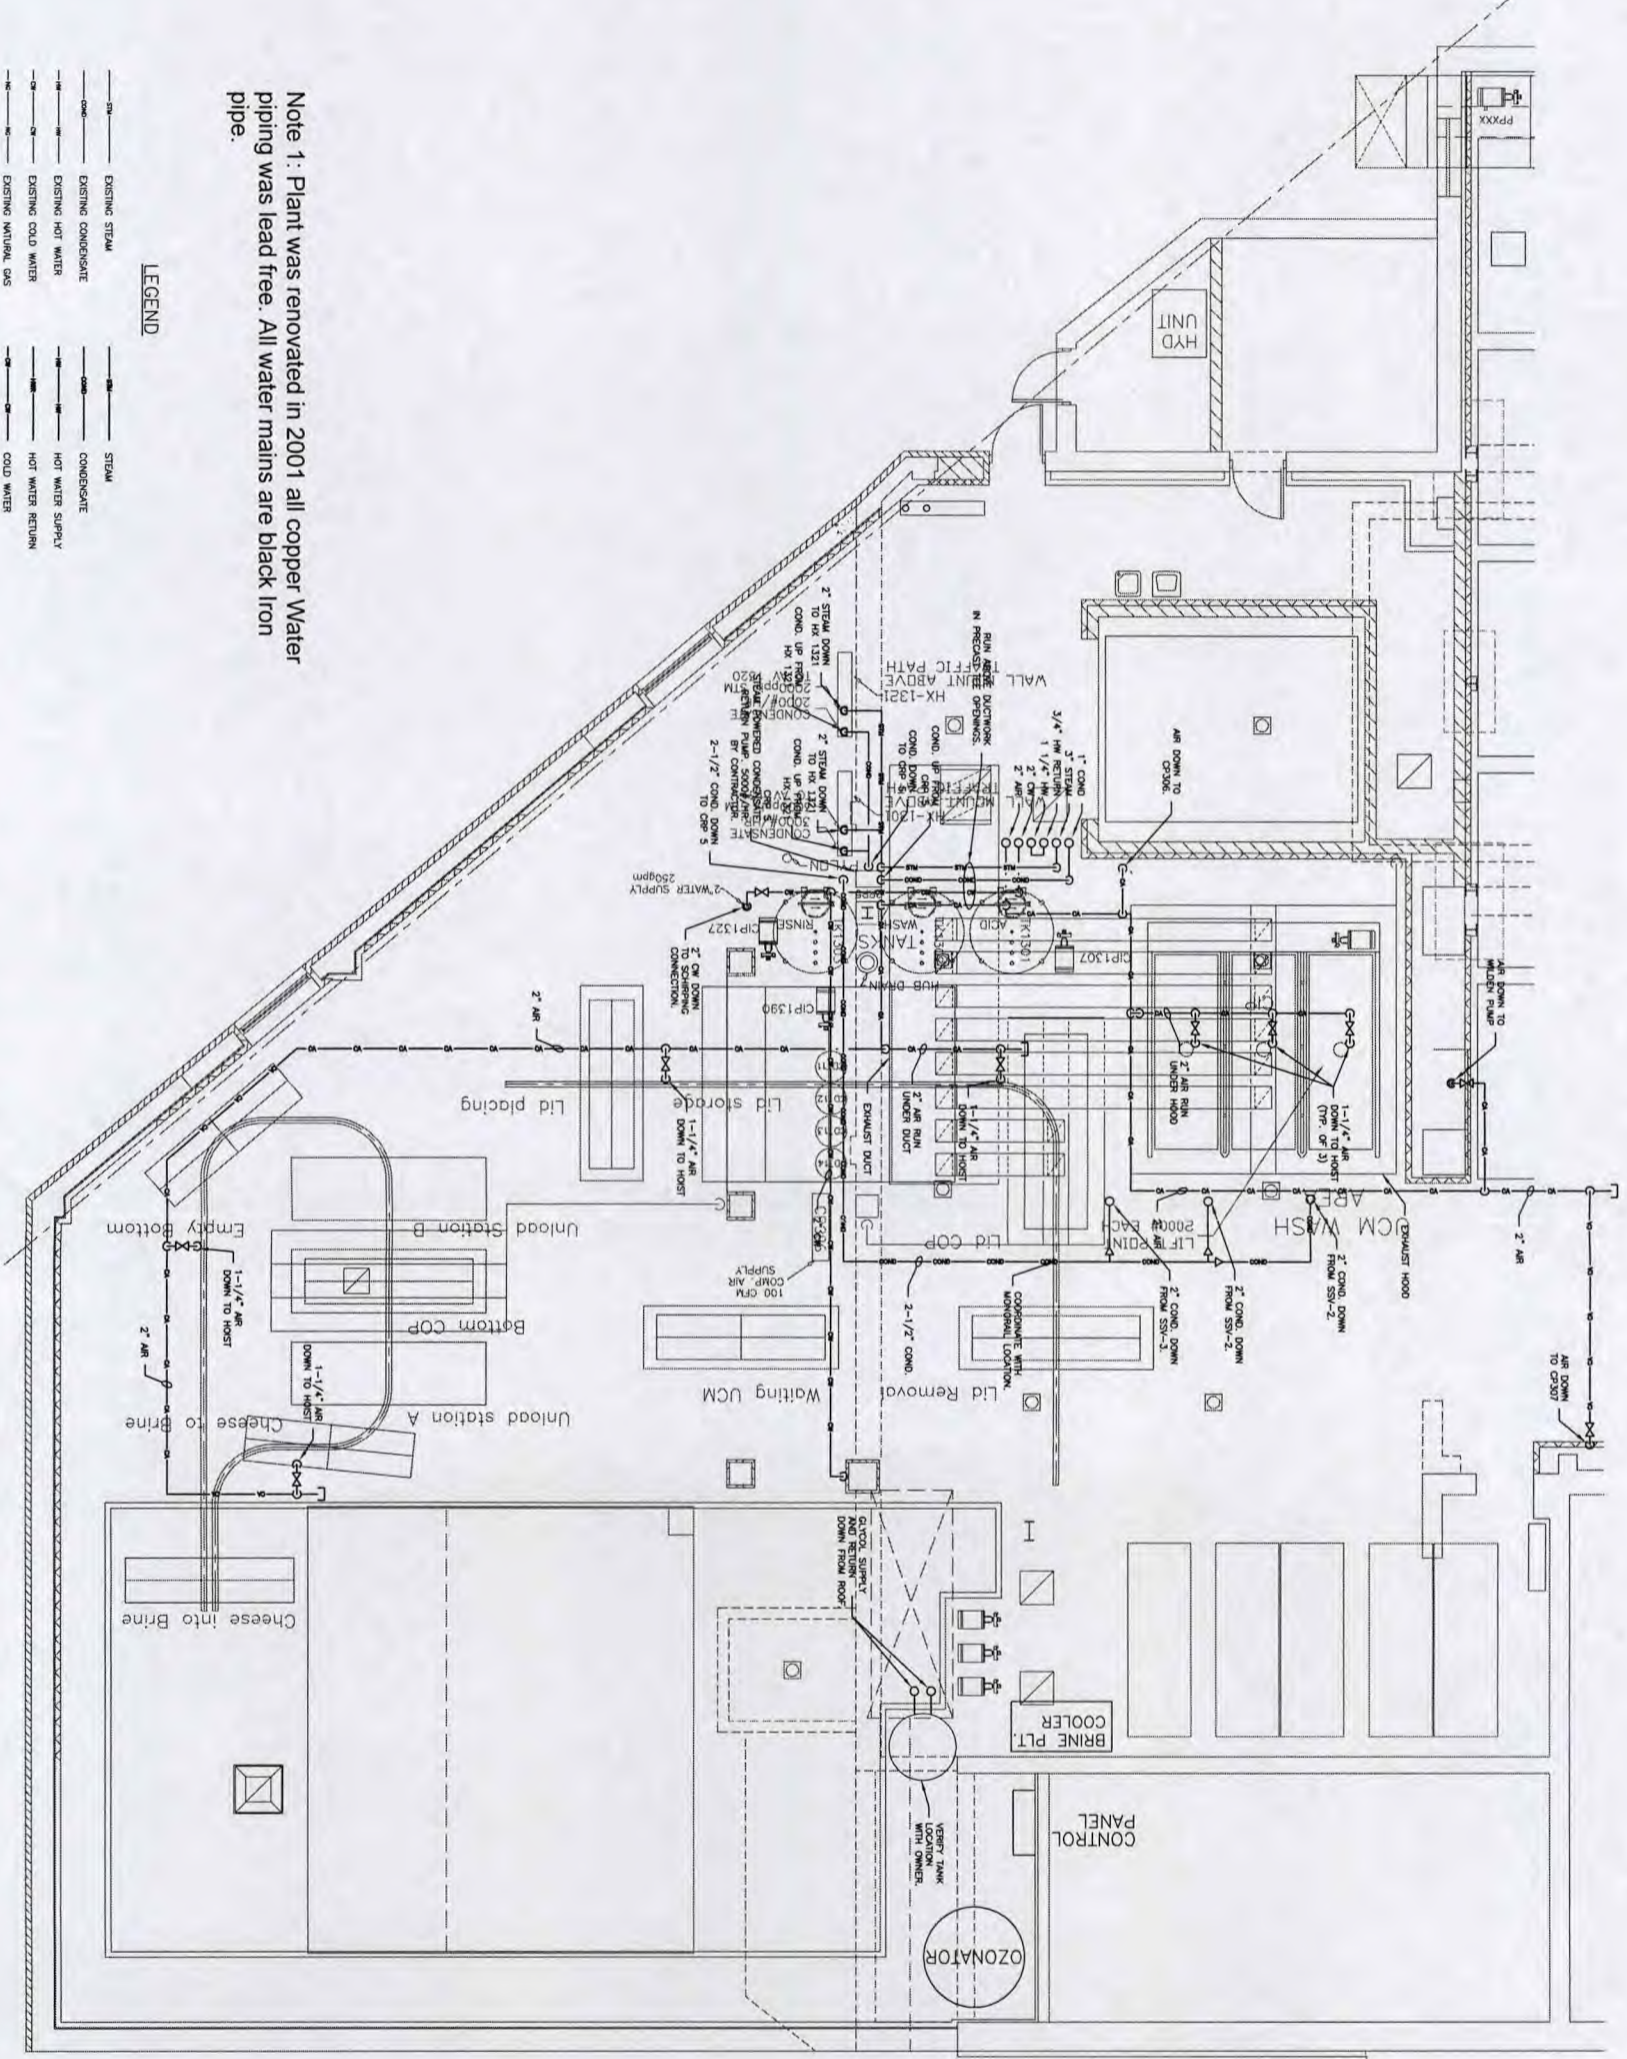

<p>Scale: AS SHOWN</p> <p>Job Number: 3070-601</p> <p>Date: 7-18-01</p> <p>Drawing Number: M1.05</p>	<p><b>1ST FLOOR MECH. PIPING PLAN</b> <b>WEST ADDITION</b></p> <p> 675 South Wabash Avenue Brewster, Ohio 44613</p>	<table border="1" style="width: 100%; border-collapse: collapse;"> <thead> <tr> <th>Revision No.</th> <th>Description</th> <th>Date</th> <th>No.</th> <th>Description</th> <th>Date</th> </tr> </thead> <tbody> <tr> <td>1</td> <td>GENERAL REVISION</td> <td>10/26/01</td> <td></td> <td></td> <td></td> </tr> <tr> <td>2</td> <td>GENERAL REVISION</td> <td>11/15/01</td> <td></td> <td></td> <td></td> </tr> </tbody> </table>	Revision No.	Description	Date	No.	Description	Date	1	GENERAL REVISION	10/26/01				2	GENERAL REVISION	11/15/01				<p><b>HENDON REDMOND</b></p> <p>Engineers ■ Architects ■ Consultants</p> <p style="font-size: small;">1385 Tennessee Avenue Cincinnati, OH 45229 Phone: 513/641-0320 Facsimile: 513/641-0057 www.HendonRedmond.com</p>
Revision No.	Description	Date	No.	Description	Date																
1	GENERAL REVISION	10/26/01																			
2	GENERAL REVISION	11/15/01																			



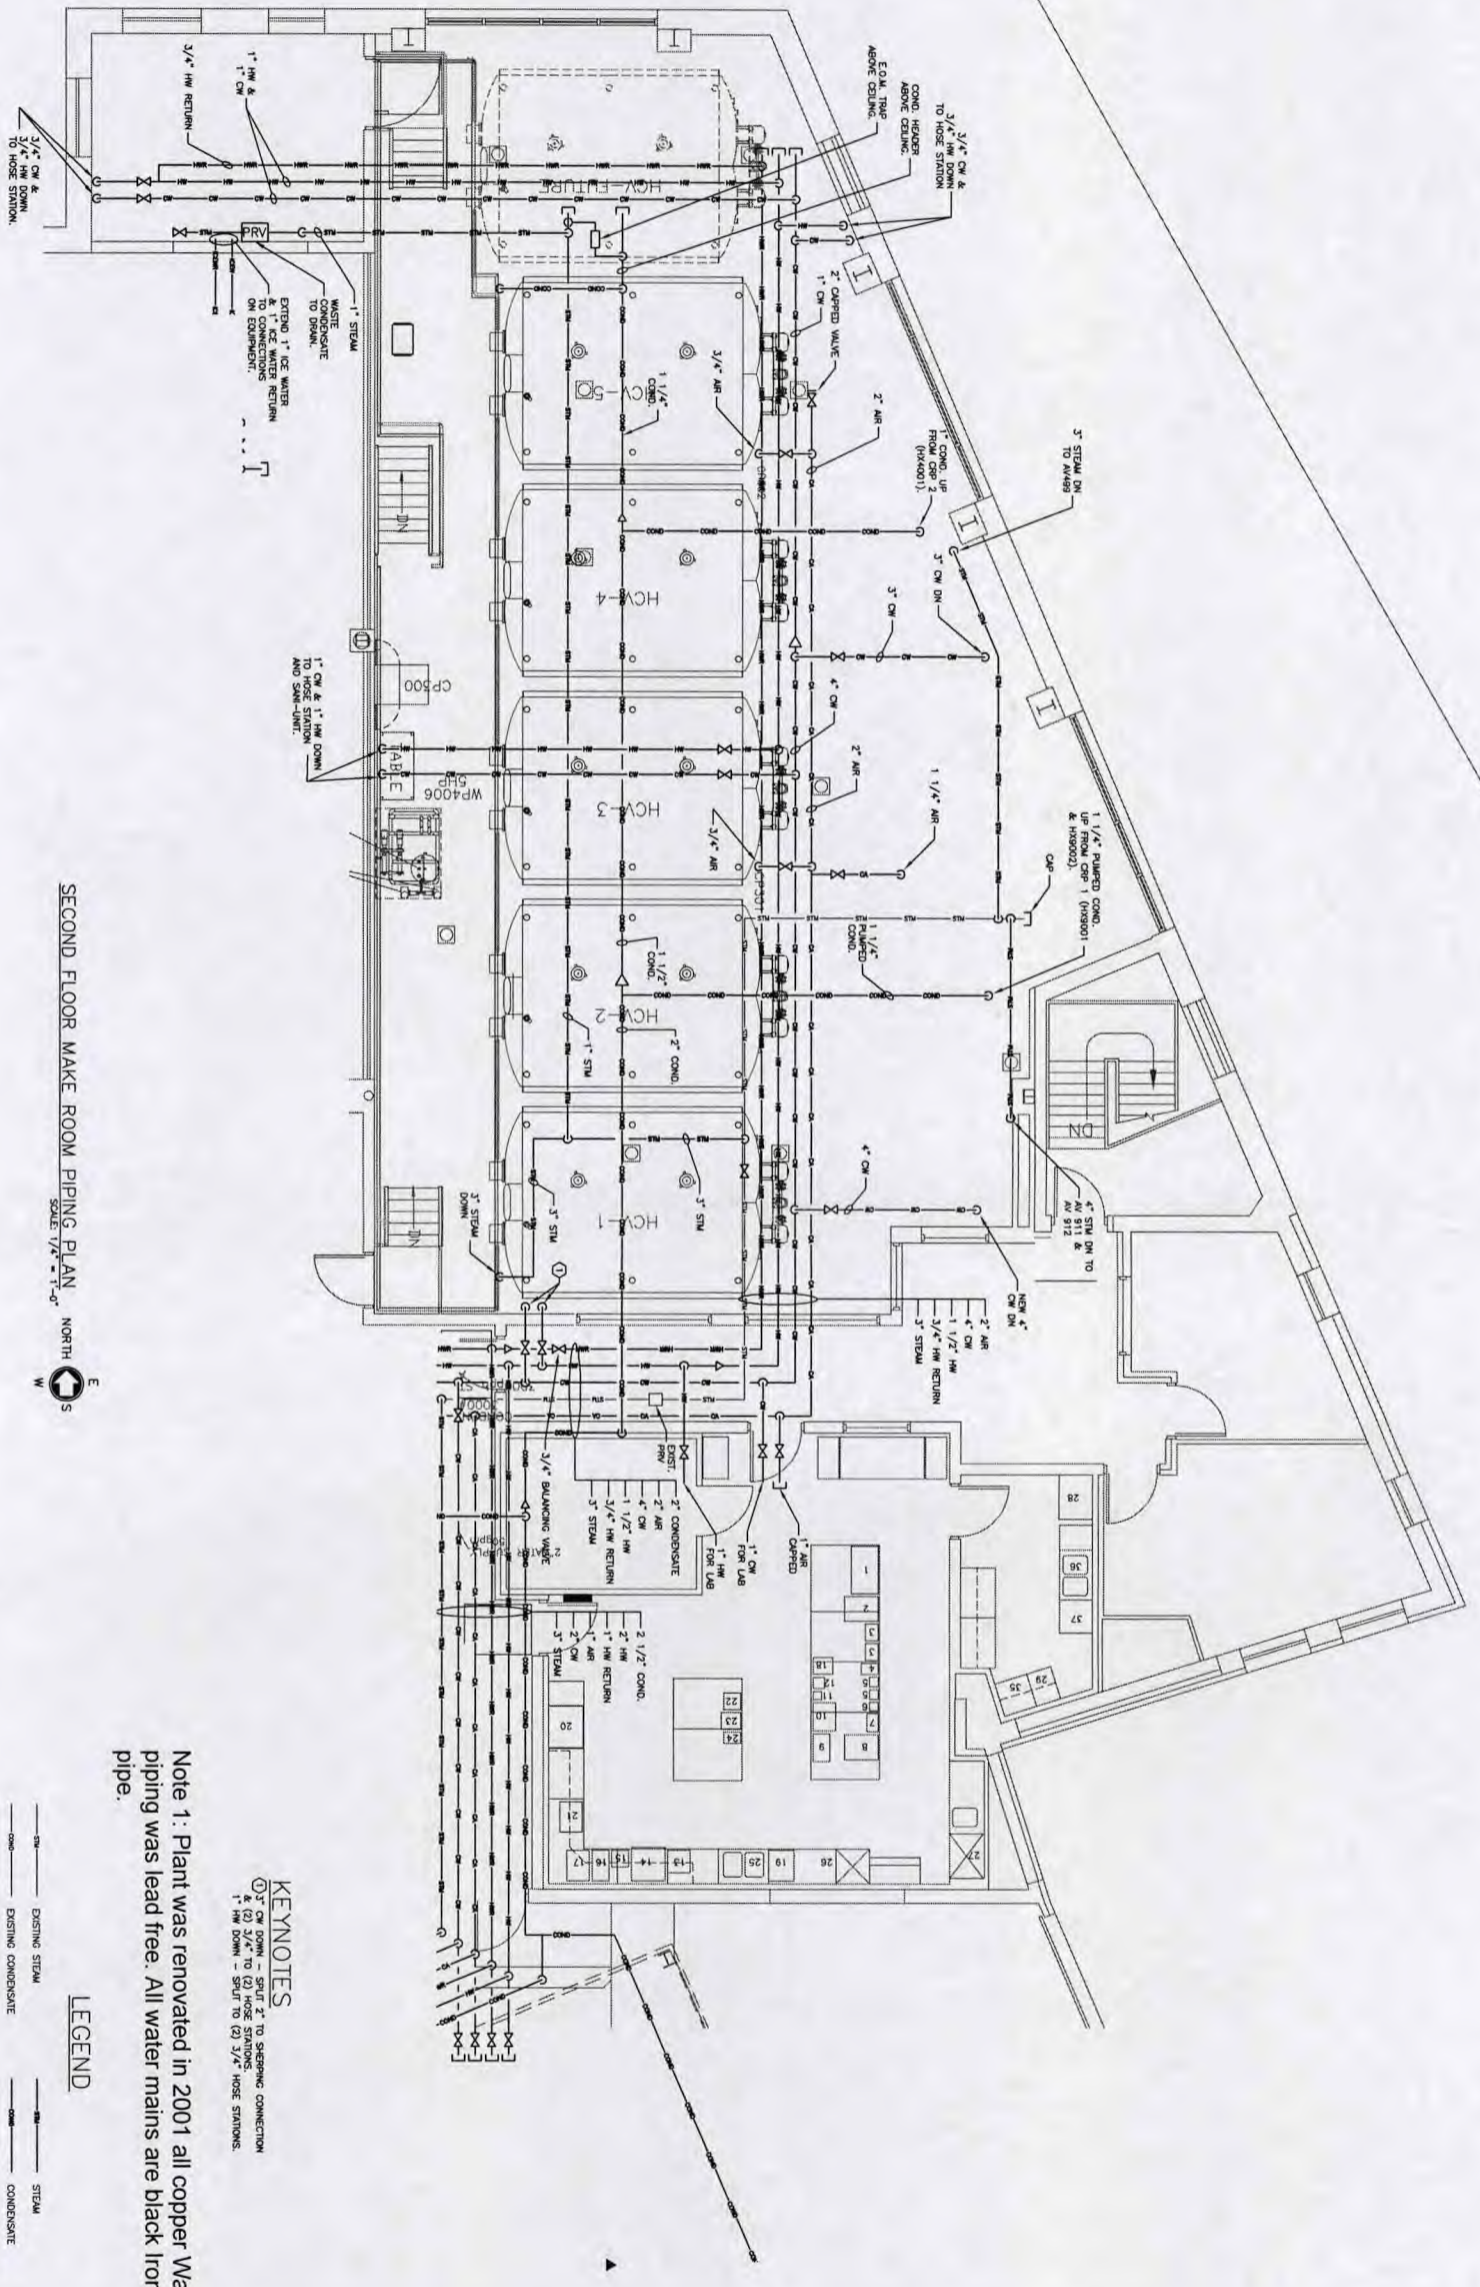

SECOND FLOOR MAKE ROOM PIPING PLAN  
SCALE 1/2"=1'-0"  
NORTH

Note 1: Plant was renovated in 2001 all copper water piping was lead free. All water mains are black iron pipe.

KEYNOTES  
 (1) 2" CW DOWN - SUIT 2" TO SHARING CONNECTION & (2) 3/4" CW TO (2) HOSE STATIONS  
 1" HW DOWN - SPLIT TO (2) 3/4" HOSE STATIONS

LEGEND

—	EXISTING STEAM	—	STEAM
—	EXISTING CONDENSATE	—	CONDENSATE
—	EXISTING HOT WATER	—	HOT WATER SUPPLY
—	EXISTING COLD WATER	—	HOT WATER RETURN
—	EXISTING NATURAL GAS	—	COLD WATER
—	EXISTING COMPRESSED AIR	—	NATURAL GAS
—	EXISTING GLYCOL SUPPLY	—	COMPRESSED AIR
—	EXISTING GLYCOL RETURN	—	ICE WATER SUPPLY
—		—	ICE WATER RETURN
—		—	GLYCOL SUPPLY
—		—	GLYCOL RETURN

Revision No.	Description	Date	No.	Description	Date
1	GENERAL REVISIONS	7/18/01			

2ND FLOOR MECH. PIPING PLAN  
WEST ADDITION

675 South Wabash Avenue  
Brewster, Ohio 44613

**brewster cheese**

Scale: AS SHOWN

Job Number: 3070-601

Date: 5-21-01


Drawing Number: M1.06

**HENDON REDMOND**

Engineers ■ Architects ■ Consultants

1385 Tennessee Avenue  
Cincinnati, OH 45229  
Phone 513/641-0320  
Facsimile 513/641-0057  
www.HendonRedmond.com



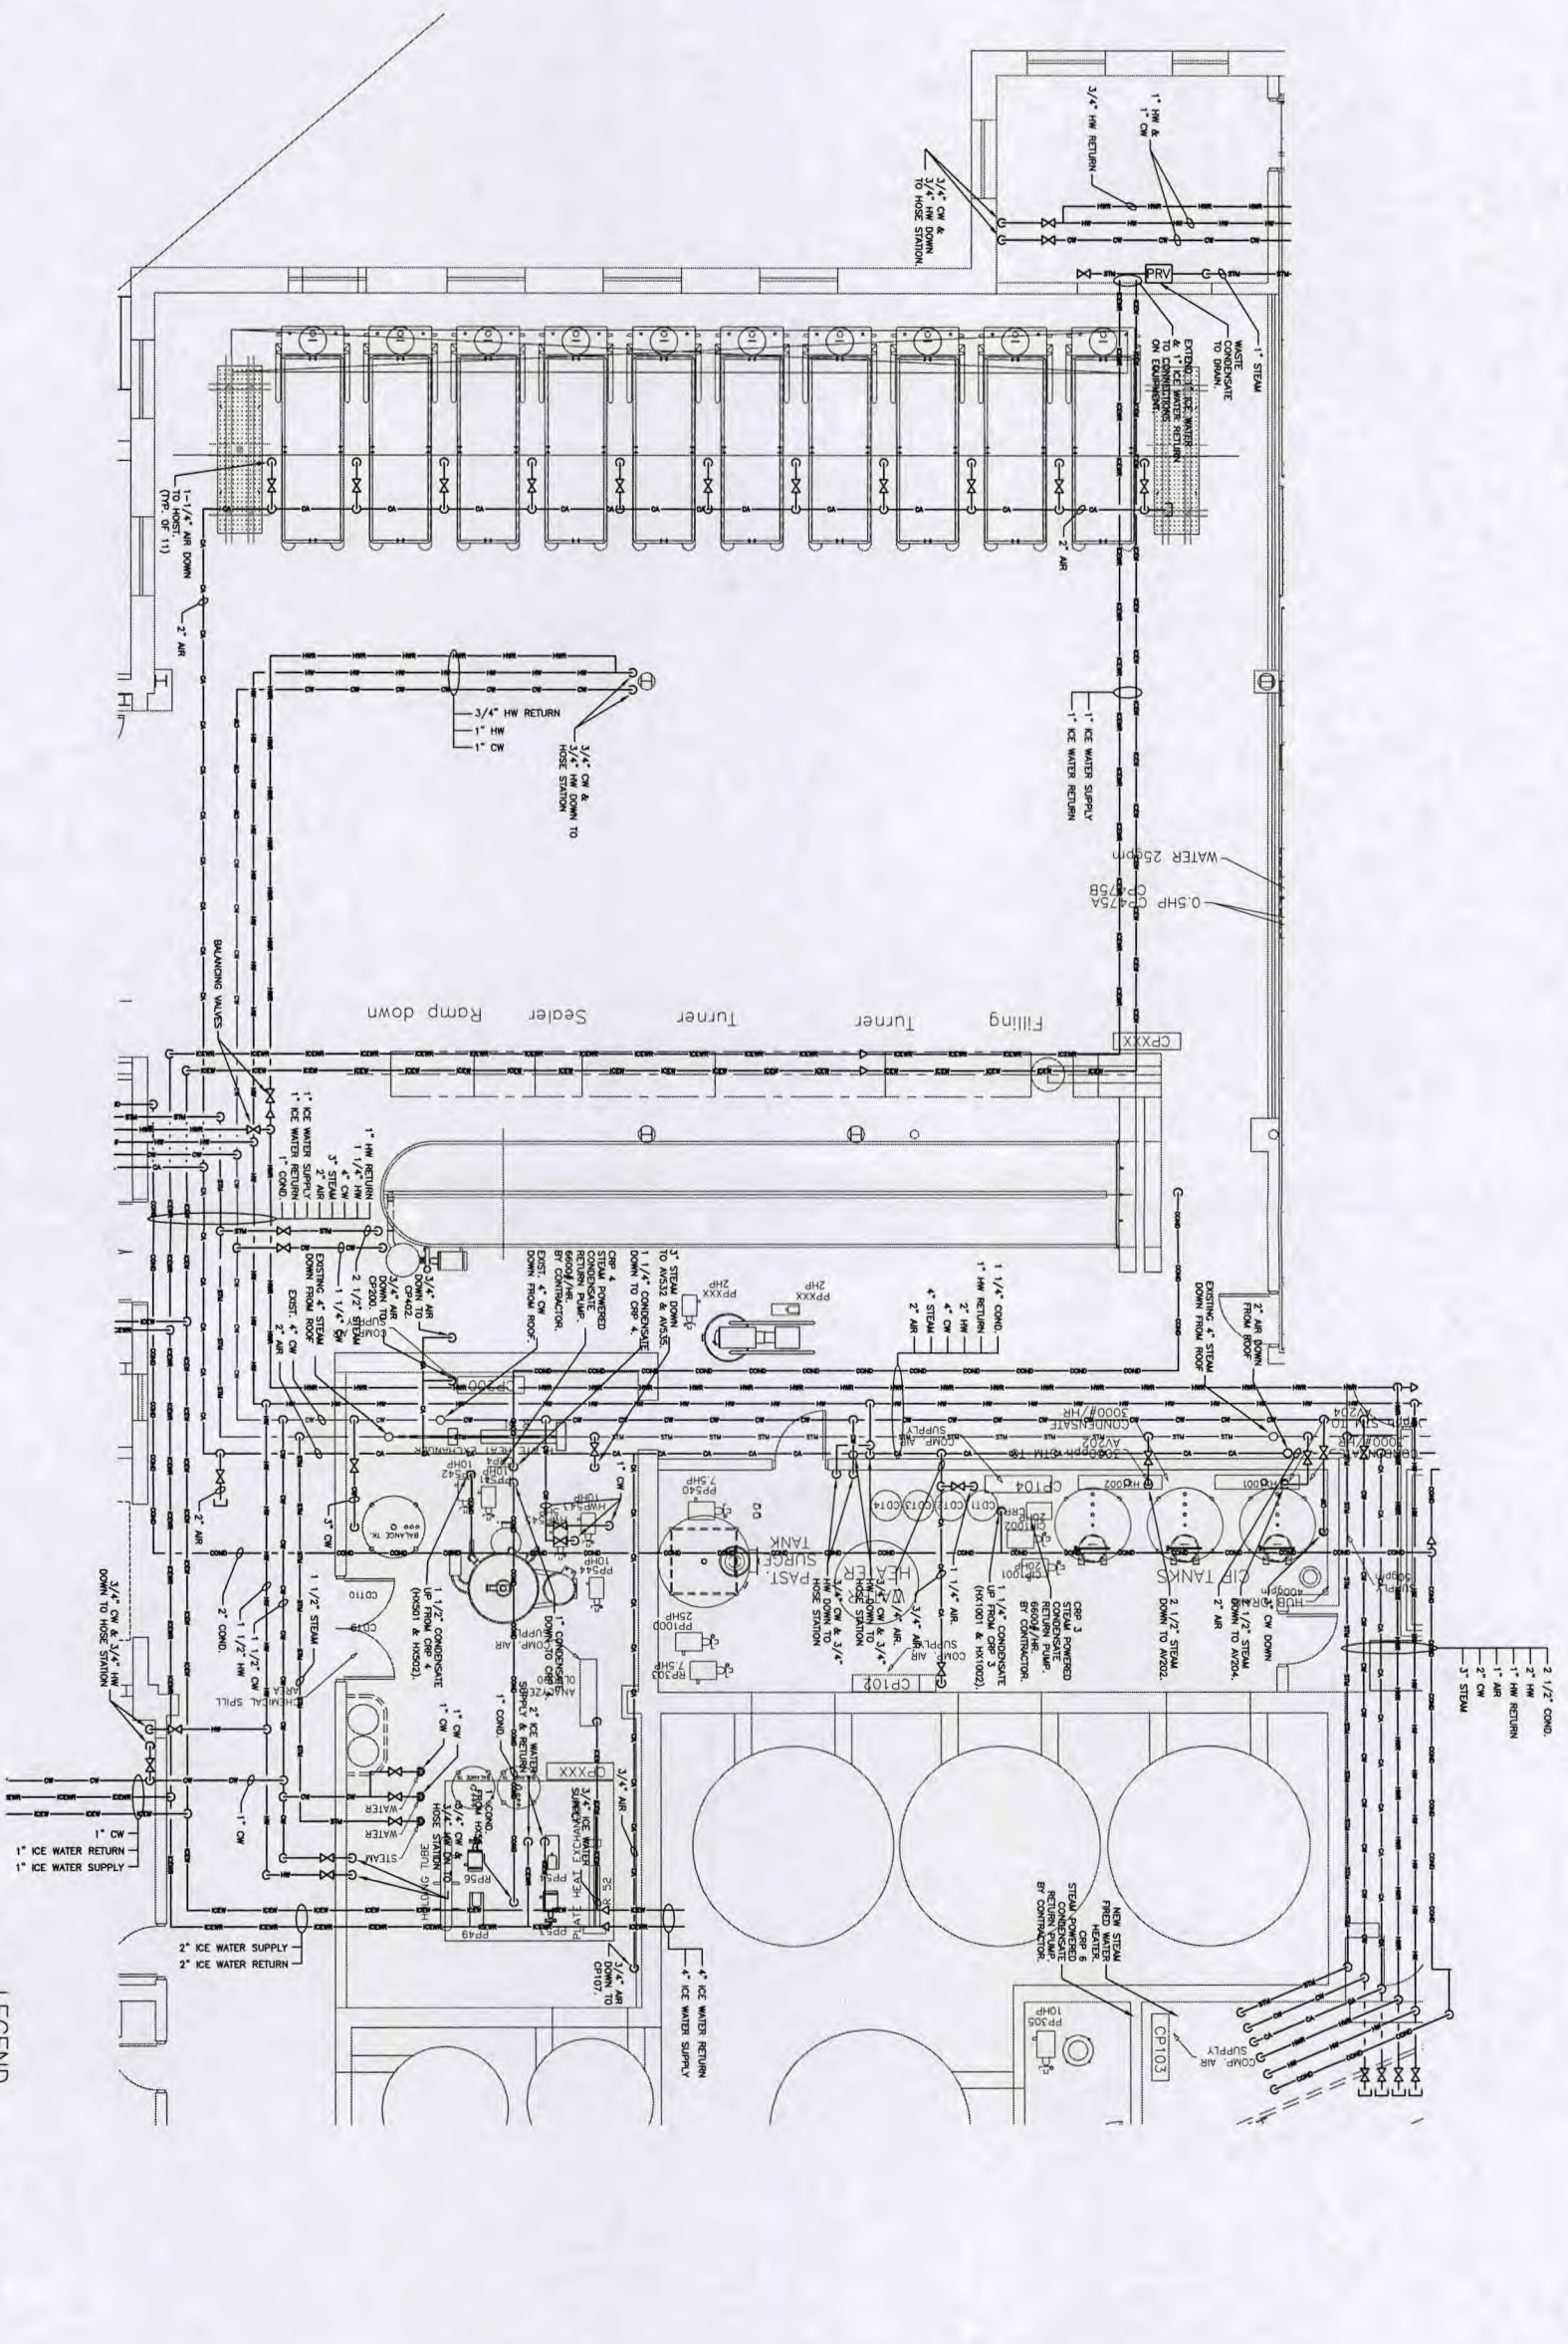

SECOND FLOOR PIPING PLAN NORTH  
SCALE: 1/8" = 1'-0"

**KEYNOTES**  
 ① 3" CW DOWN - SPILT TO SHIPPING CONNECTION  
 ② 3/4" TO (2) HOSE STATIONS  
 ③ 1" HW DOWN - SPILT TO (2) 3/4" HOSE STATIONS

**Note 1:** Plant was renovated in 2001 all copper water piping was lead free. All water mains are black iron pipe.


**LEGEND**

 —	EXISTING STEAM	—	STEAM
—	EXISTING CONDENSATE	—	CONDENSATE
—	EXISTING HOT WATER	—	HOT WATER SUPPLY
—	EXISTING COLD WATER	—	COLD WATER
—	EXISTING NATURAL GAS	—	NATURAL GAS
—	EXISTING COMPRESSED AIR	—	COMPRESSED AIR
—	EXISTING ICE WATER SUPPLY	—	ICE WATER SUPPLY
—	EXISTING ICE WATER RETURN	—	ICE WATER RETURN
—	EXISTING DUCTWORK	—	DUCTWORK

Revision No.	Description	Date	No.	Description	Date
1	GENERAL REVISION	7/18/01			
2	GENERAL REVISION	10/20/01			
3	ADDED AIR TO UCH FILL	11/15/01			

**2ND FLOOR MECH. PIPING PLAN  
WEST ADDITION**

675 South Wabash Avenue  
Brewster, Ohio 44613



Drawing Number  
**M1.07**

Date  
5-21-01

Job Number  
3070-601


Scale  
AS SHOWN



1385 Tennessee Avenue  
Cincinnati, OH 45229  
Phone 513/641-0320  
Facsimile 513/641-0057  
www.HendonRedmond.com

**Engineers ■ Architects ■ Consultants**



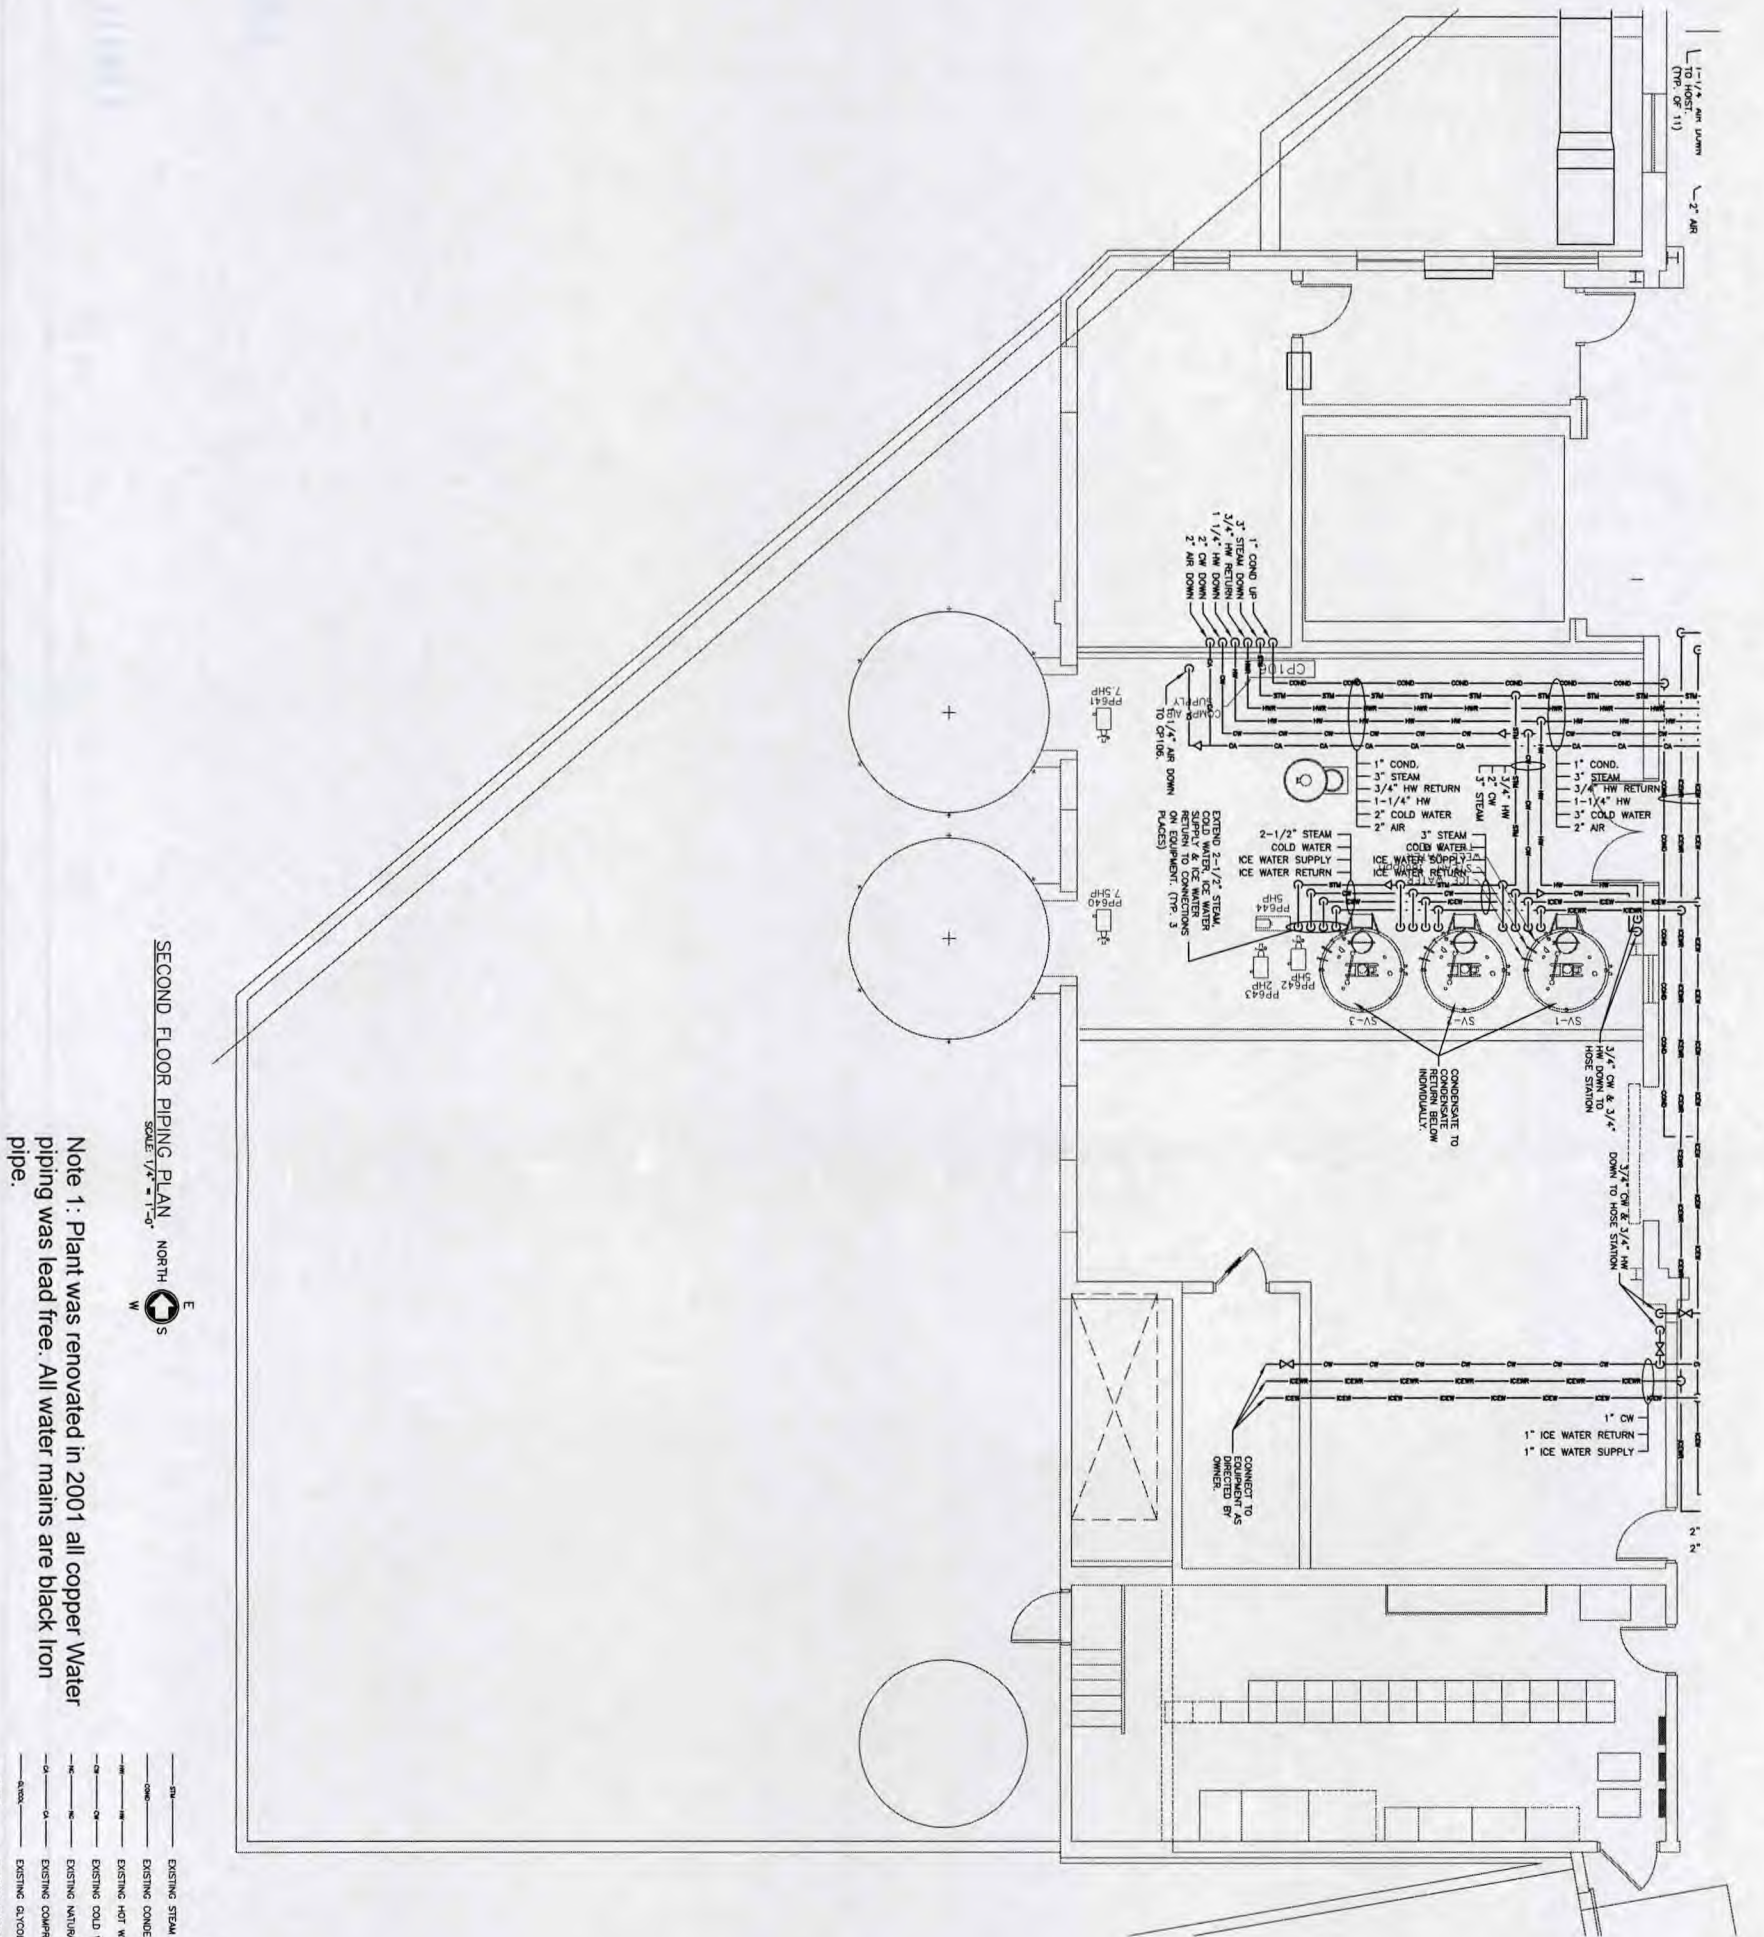


SECOND FLOOR PIPING PLAN NORTH  
SCALE: 1/4" = 1'-0"

Note 1: Plant was renovated in 2001 all copper Water piping was lead free. All water mains are black iron pipe.

LEGEND

—●—	EXISTING STEAM	—●—	STEAM
—○—	EXISTING CONDENSATE	—○—	CONDENSATE
—□—	EXISTING HOT WATER	—□—	HOT WATER SUPPLY
—◇—	EXISTING COLD WATER	—◇—	HOT WATER RETURN
—△—	EXISTING NATURAL GAS	—△—	COLD WATER
—▽—	EXISTING COMPRESSED AIR	—▽—	NATURAL GAS
—◇—	EXISTING COLD WATER SUPPLY	—◇—	COMPRESSED AIR
—△—	EXISTING HOT WATER RETURN	—△—	ICE WATER SUPPLY
—▽—	EXISTING NATURAL GAS	—▽—	ICE WATER RETURN
—◇—	EXISTING COMPRESSED AIR	—◇—	GLYCOL SUPPLY
—△—	EXISTING COLD WATER SUPPLY	—△—	GLYCOL RETURN
—▽—	EXISTING HOT WATER RETURN	—▽—	

 2ND FLOOR MECH. PIPING PLAN  
WEST ADDITION



675 South Wabash Avenue  
Brewster, Ohio 44613

Revision No.	Description	Date	No.	Description	Date
1	GENERAL REVISION	7/18/01			
2	GENERAL REVISION	10/30/01			



1385 Tennessee Avenue  
Cincinnati, OH 45229  
Phone 513/641-0320  
Facsimile 513/641-0057  
www.HendonRedmond.com

Engineers ■ Architects ■ Consultants

M1.08

Scale	AS SHOWN
Job Number	3070-601
Date	5-21-01
Drawing Number	