


**OVERALL FLOOR PLAN**  
SCALE 1/32" = 1'-0"

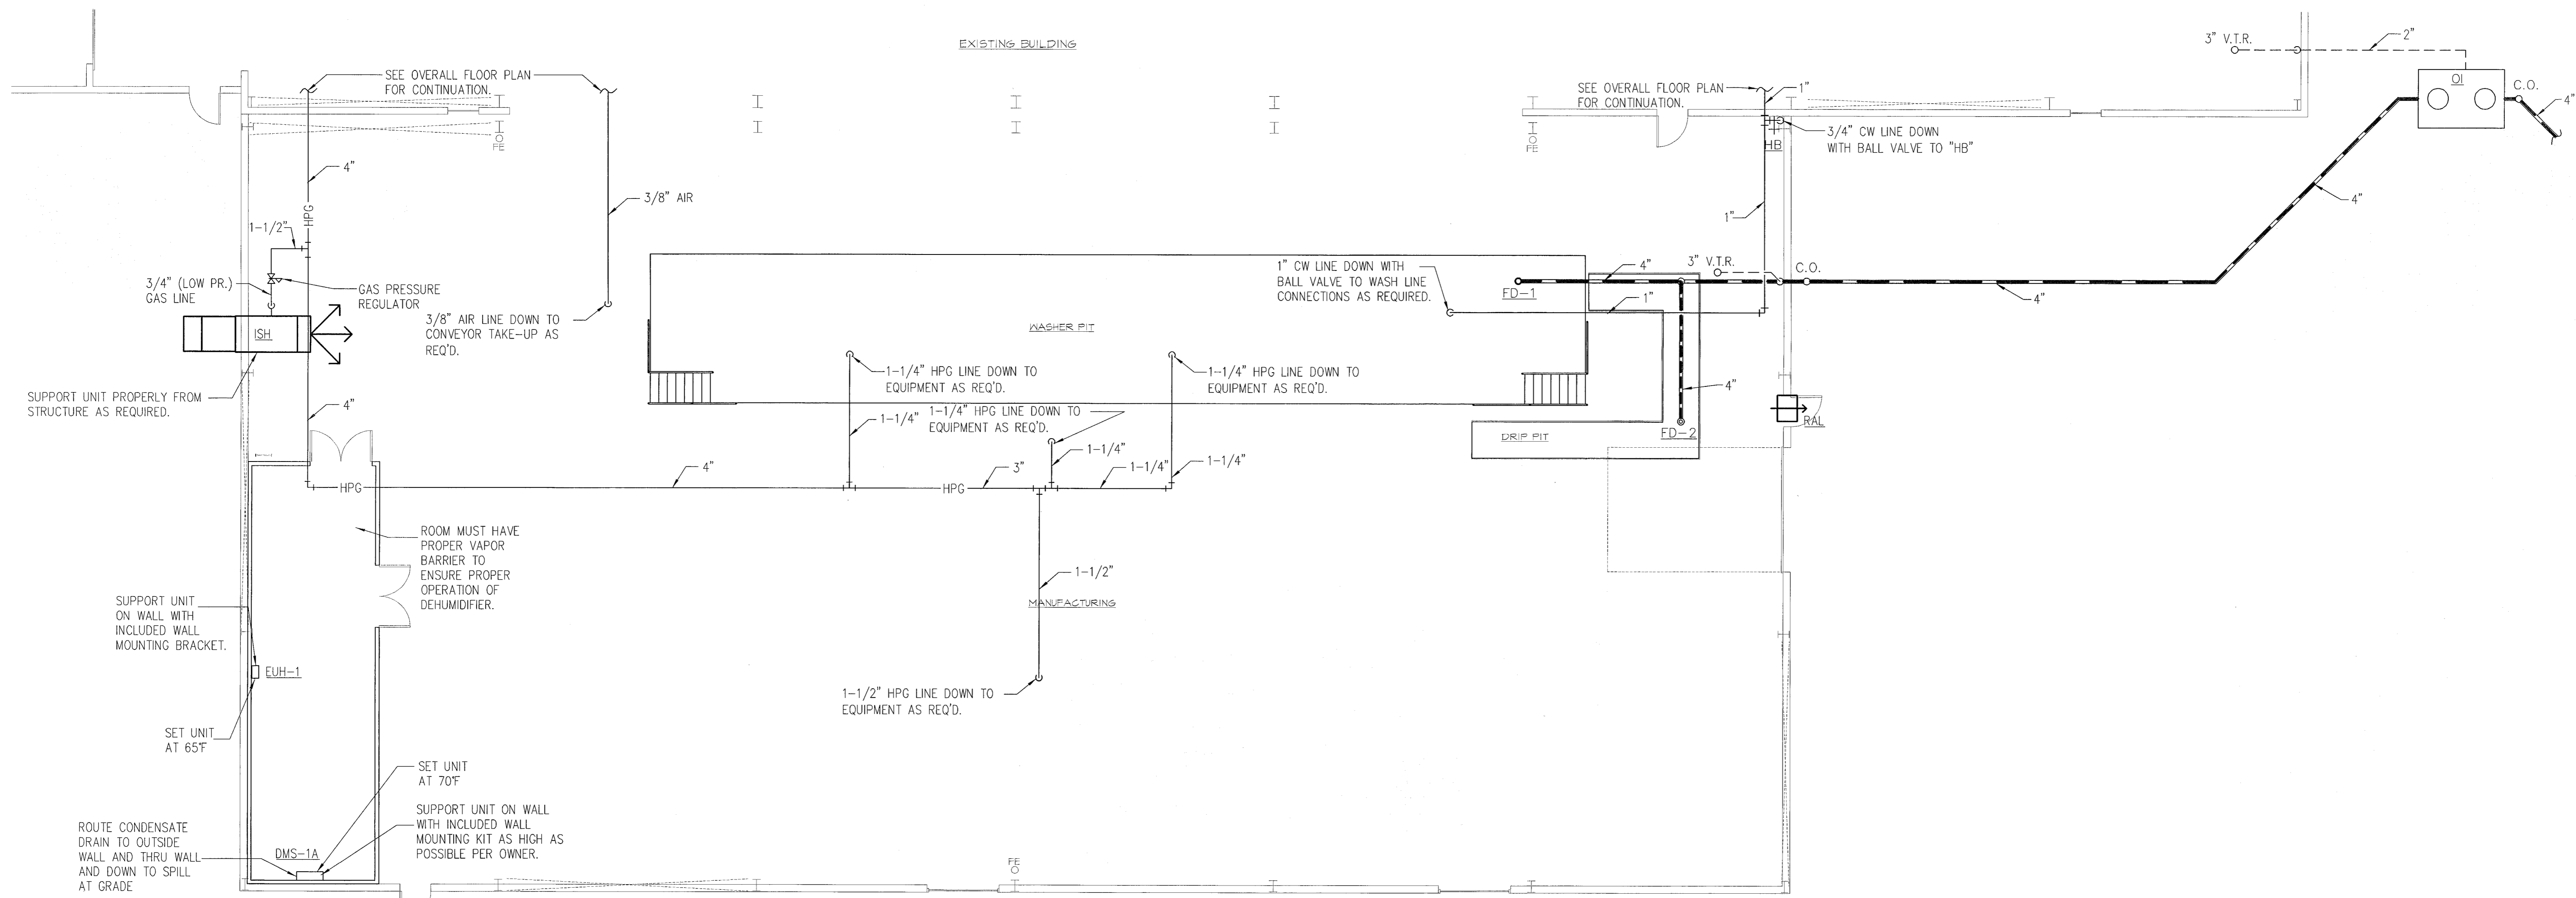

**ENLARGED MECHANICAL PLAN**  
SCALE 1/8" = 1'-0"


CONSTRUCTION SERVICES  
CONSTRUCTION MANAGEMENT  
DESIGN-BUILD SPECIALISTS • SINCE 1953

**Campbell**  
CONSTRUCTION

1159 BLANCHLEYVILLE RD., WOOSTER, OH 44691 330/262-5186


BUILDING ADDITION FOR  
CNC METAL PRODUCTS  
2061 SYLVAN ROAD  
WOOSTER, OHIO 44691

**ELECTRO-MECH ENGINEERING, INC.**  
311 High Street NE  
Canal Fulton, Ohio 44614  
(330) 854-0347 (voice)  
(330) 854-0492 (fax)  
1-877-277-8649 (toll free)  
design@electro-mech-engineers.com

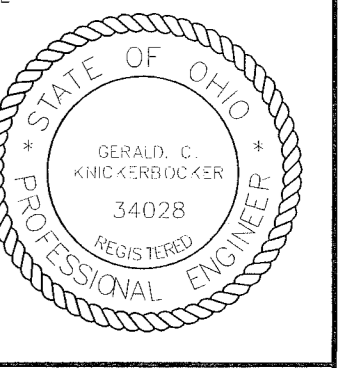


REVISIONS
FILE
...CONVINC
DRAWN BY
DATE
8-29-11
DRAWING NO.


**M-1**

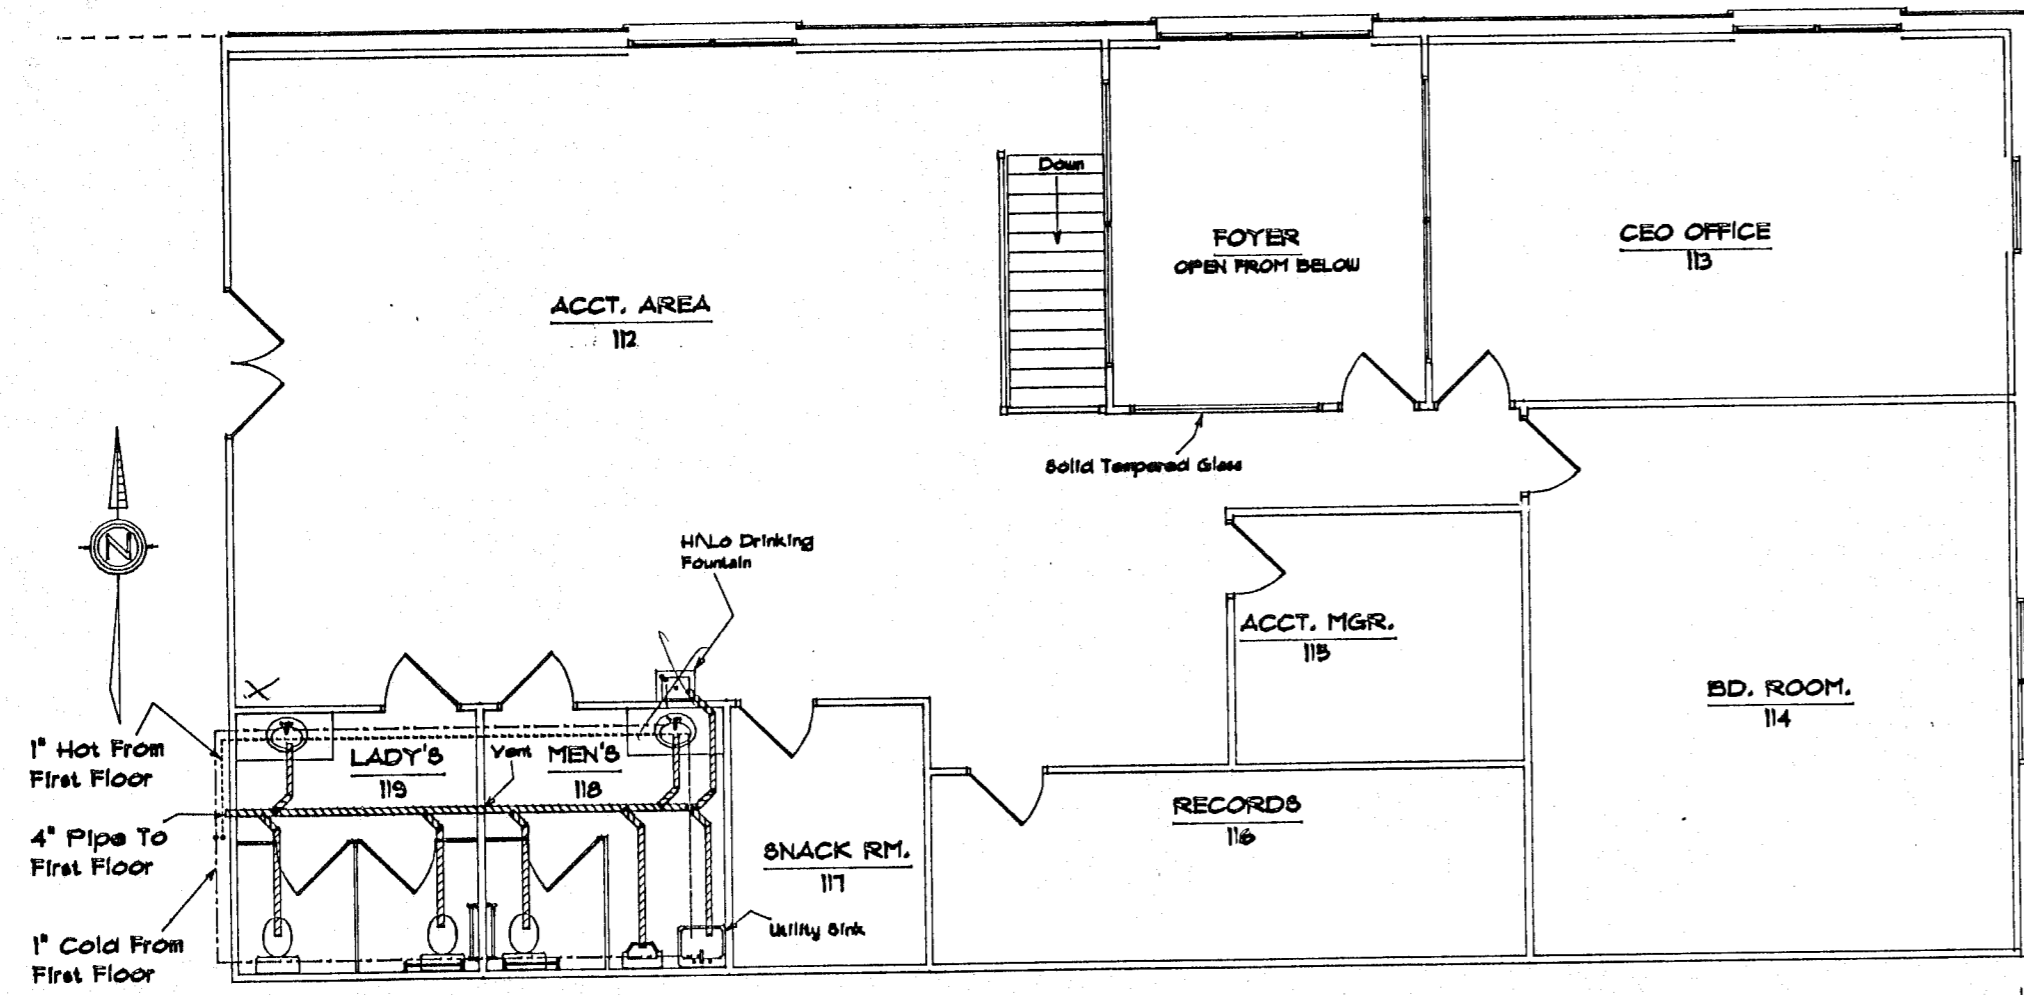

UPPER FLOOR PLUMBING

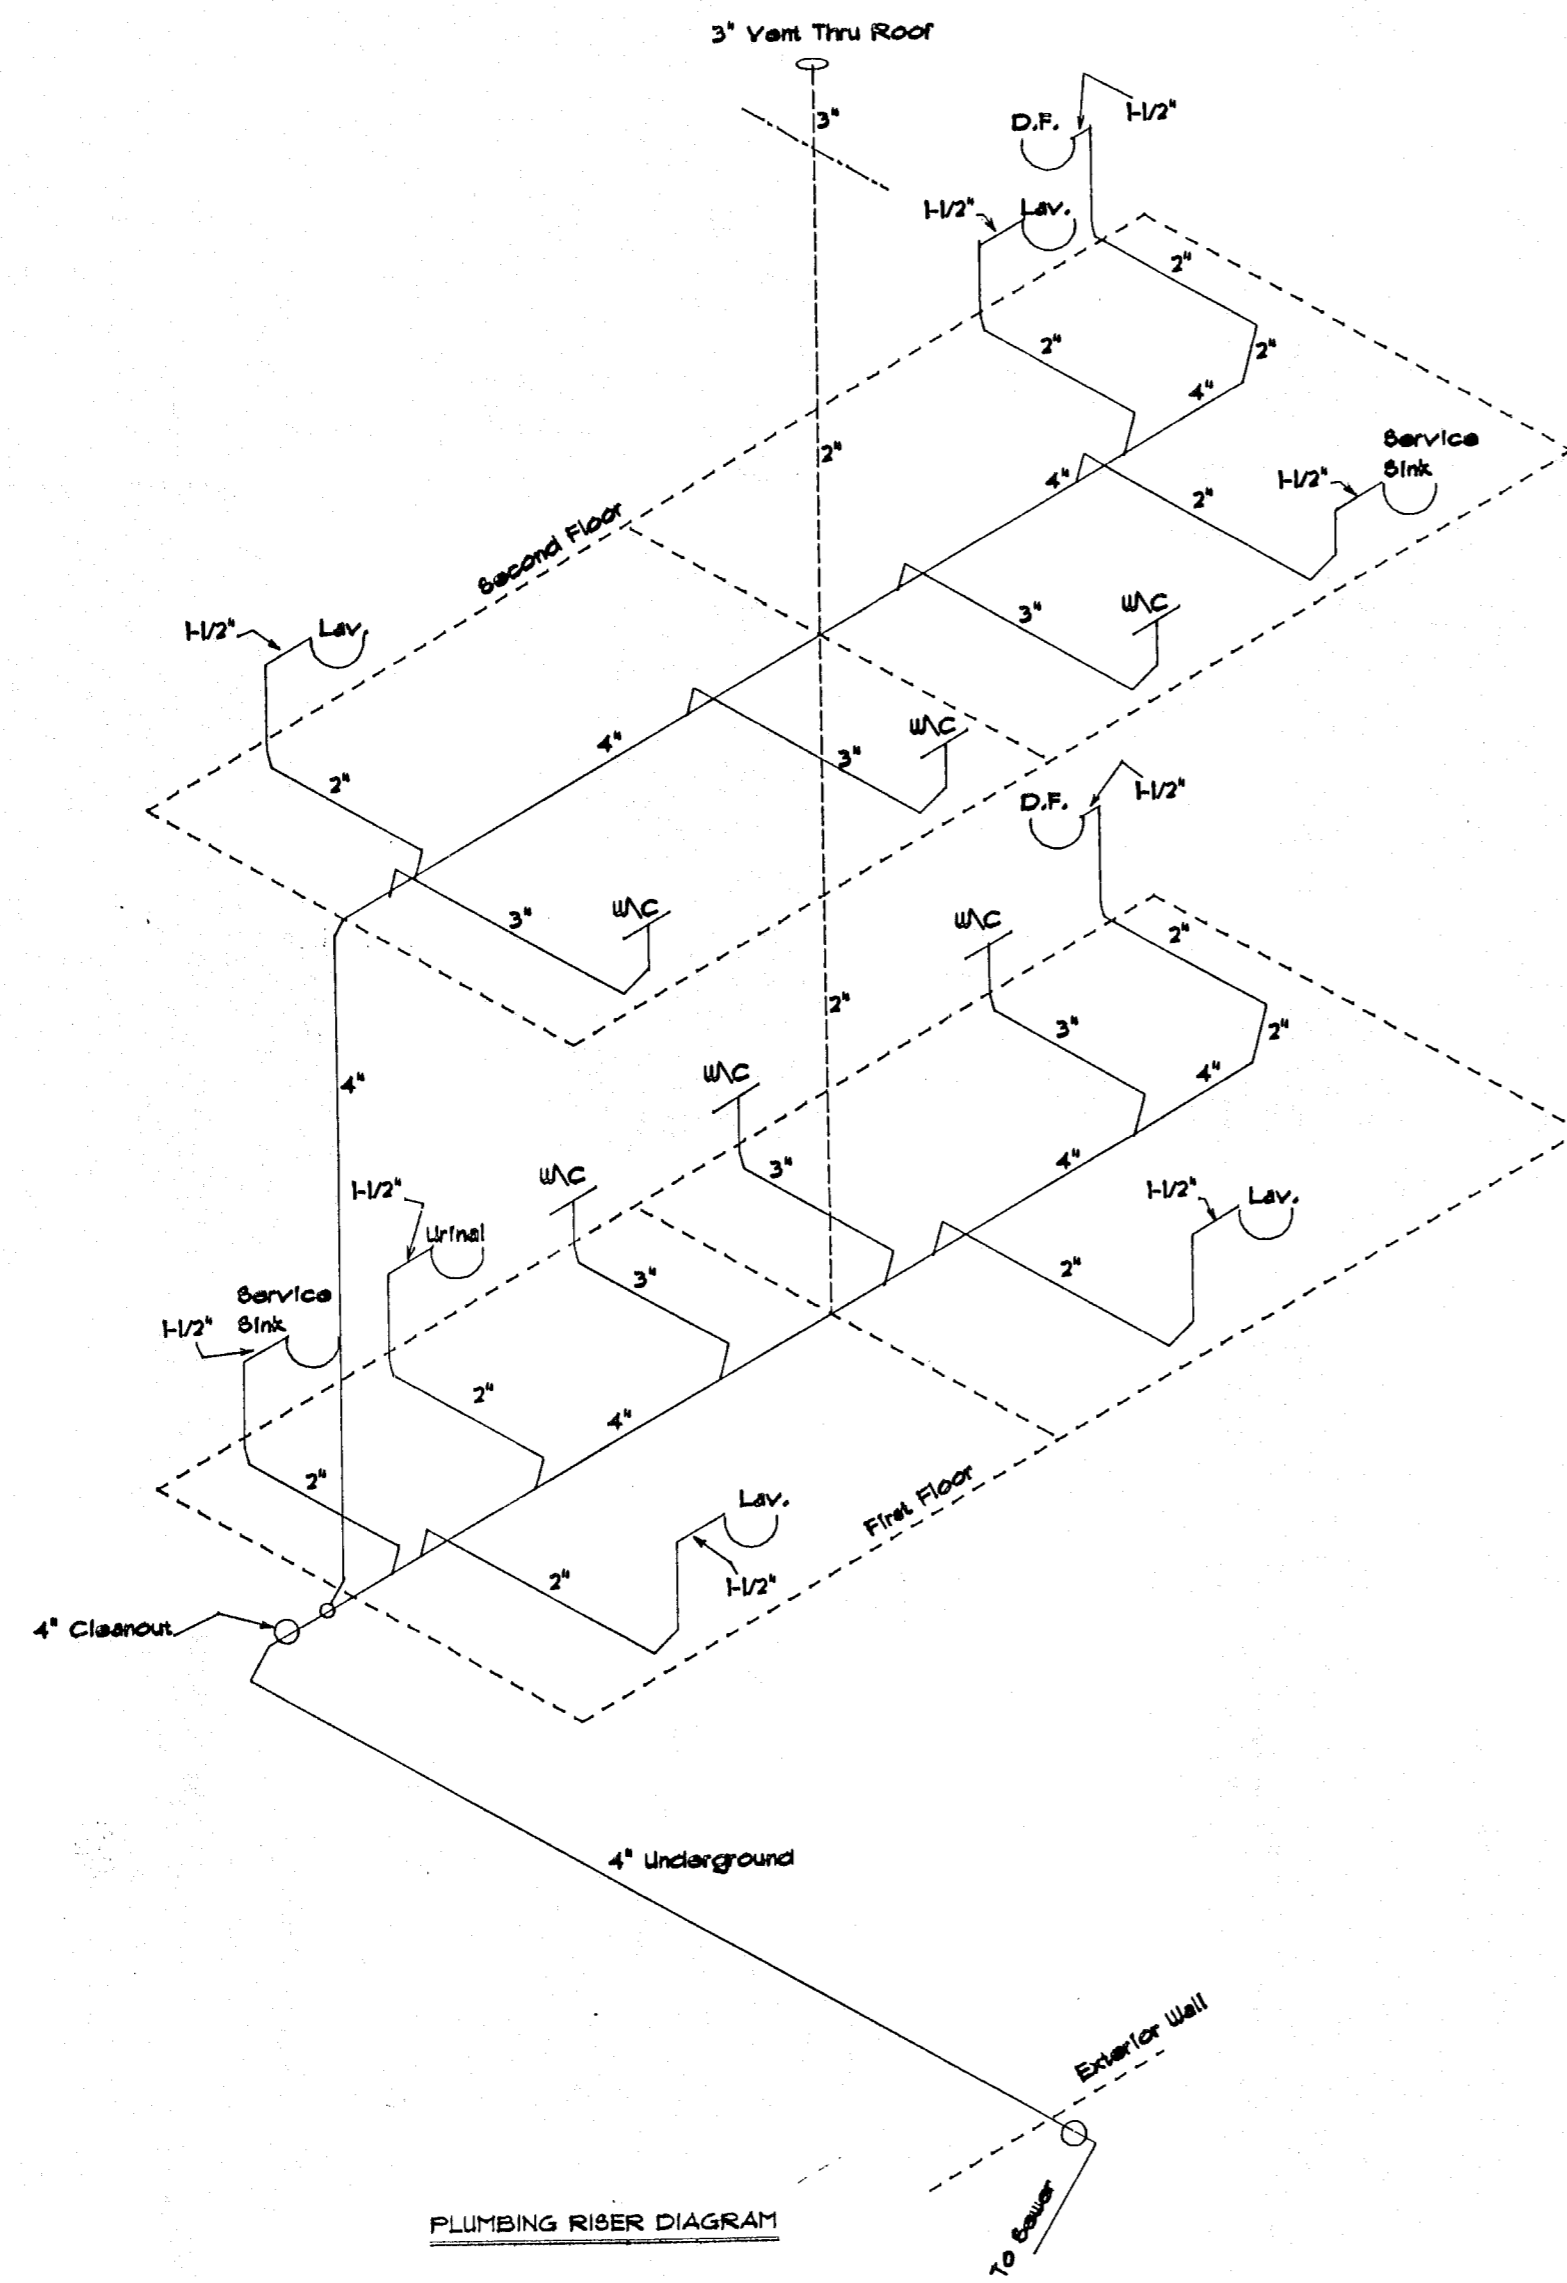

PLUMBING RISER DIAGRAM

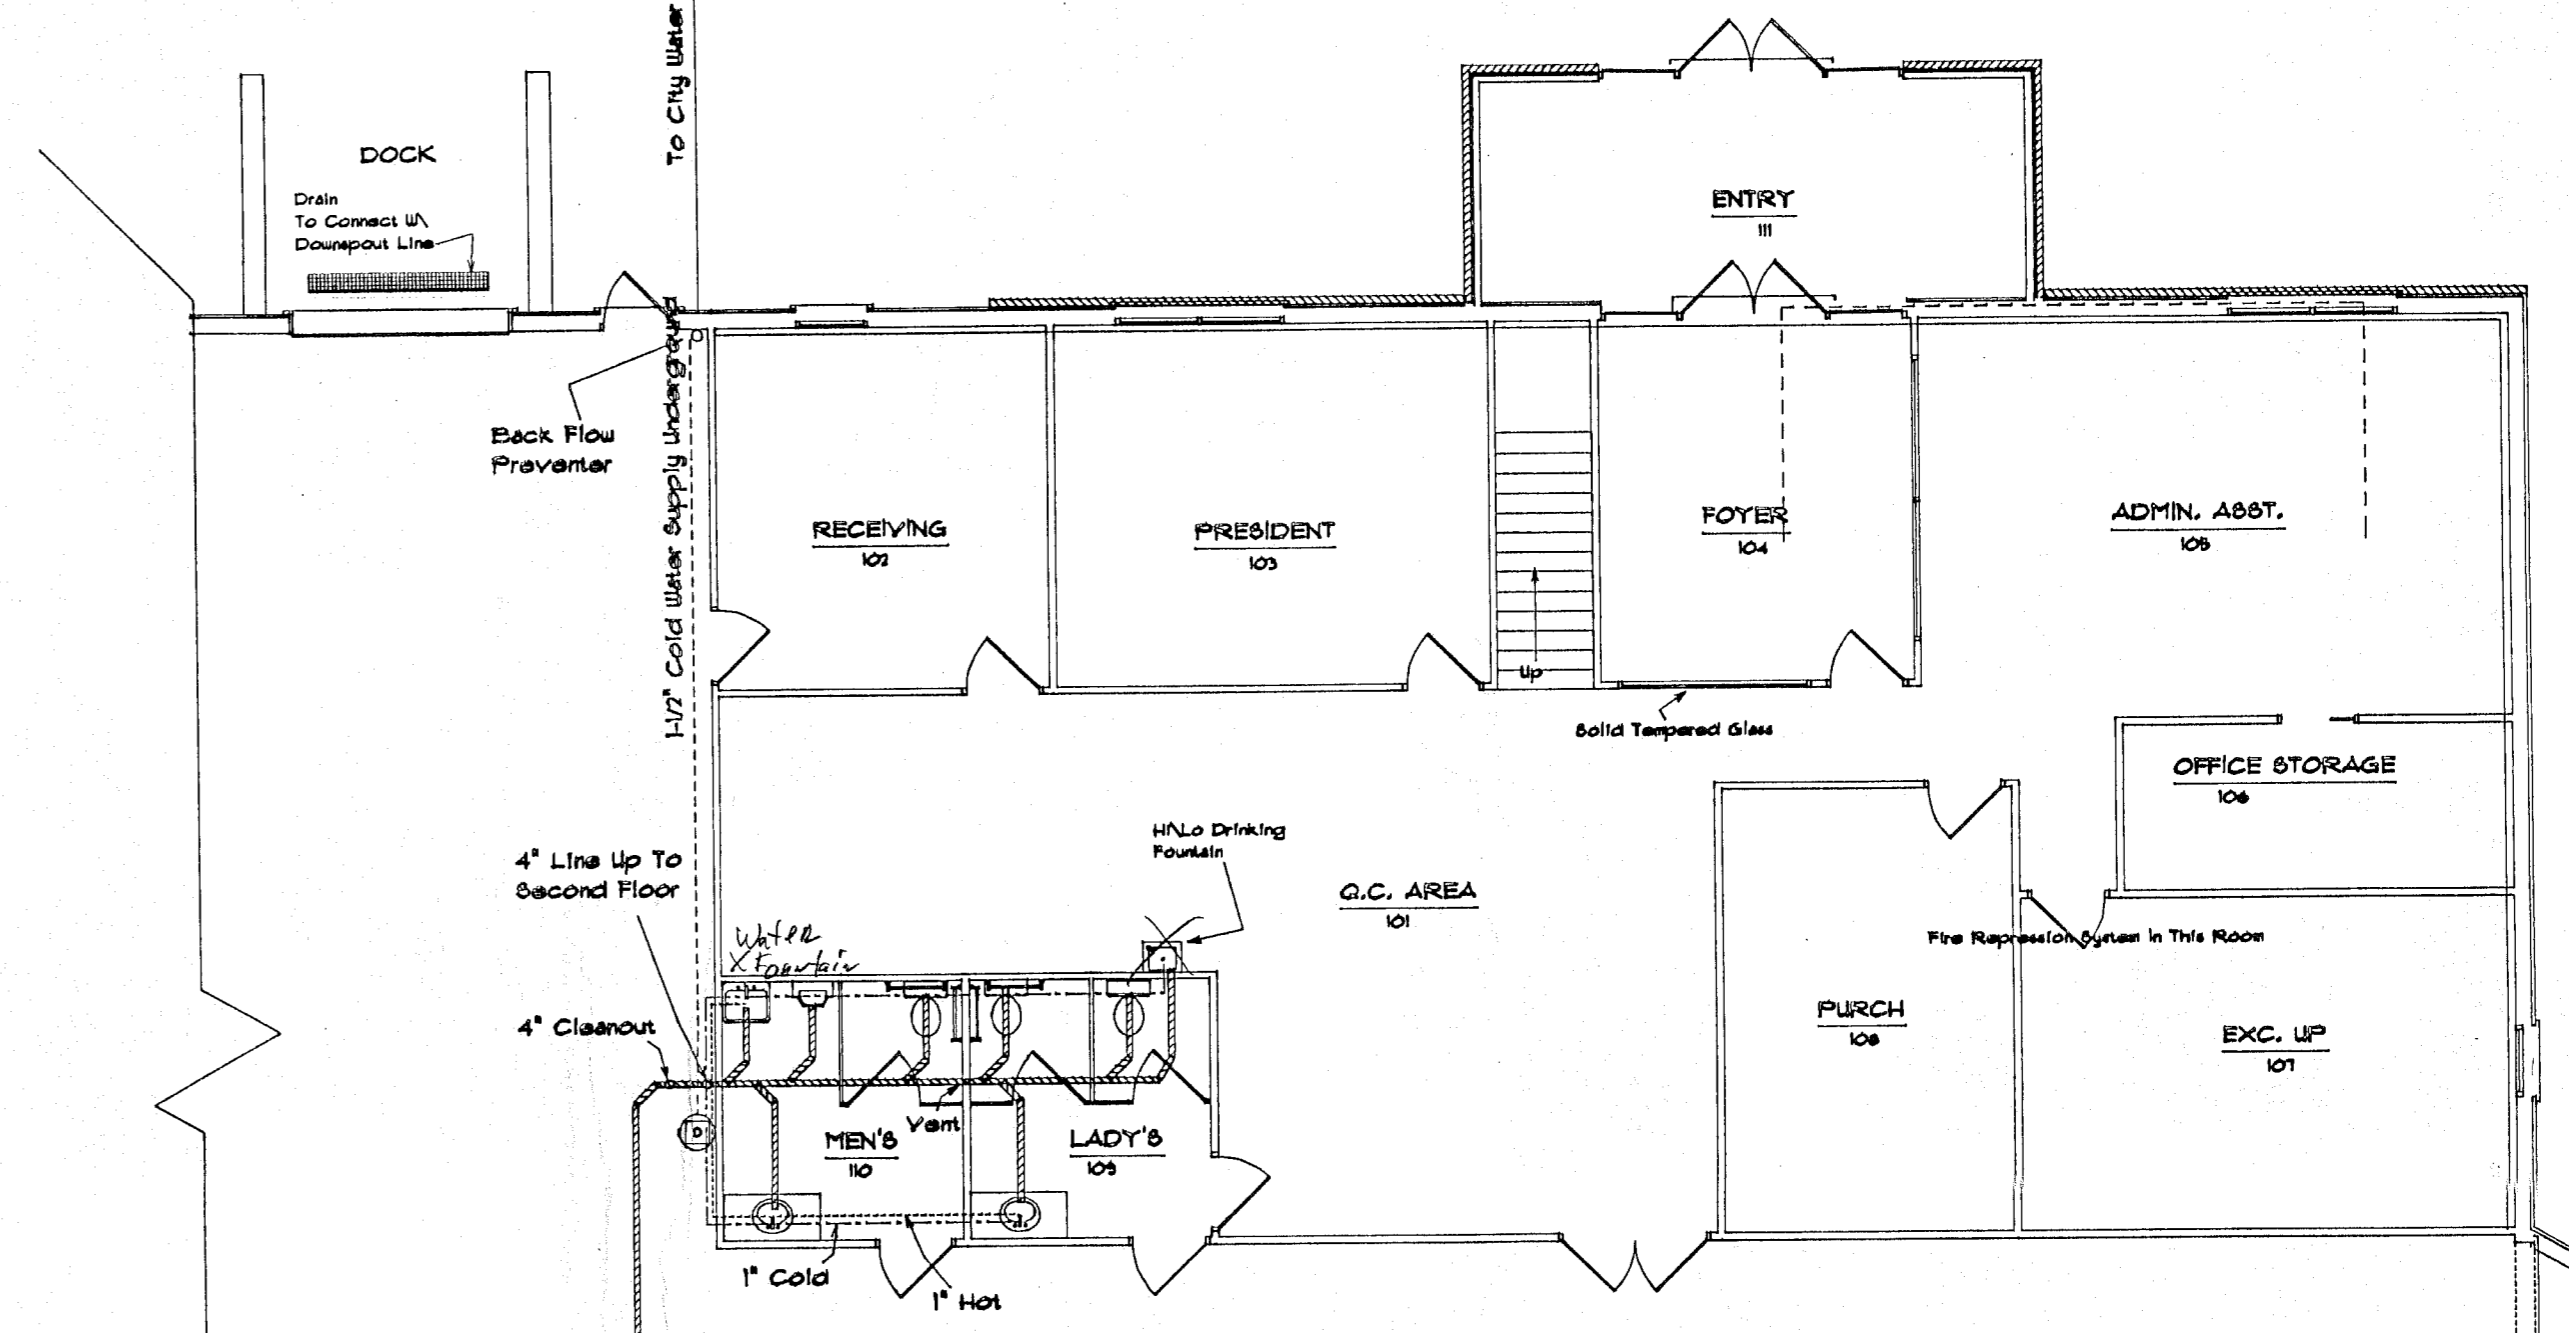

MAIN FLOOR PLUMBING

<b>CNC META</b>		
Drawn By:	Scale:	Date:
<i>BD</i>	1/8" = 1' 0"	07-16-99
Approved By:		
Subject:	MAIN FLOOR PL	
BUCKEYE DRAFTING (330) 614-DRAW		