


# Building Water shutoffs in Classroom basement

"Buildings in Ohio built prior to 1998 or that use plumbing material or solder manufactured before 1998 may have materials with greater than 8% lead and are at a higher risk of contributing lead to the drinking water than materials manufactured after 1998. In addition, buildings built and plumbing materials manufactured after 2014 were required to have less than 0.25% lead by weight and have the lowest risk for contributing lead to the drinking water. It should be noted however that, although prohibited, some use of leaded solder or leaded components may have occurred after the prohibitions became effective."

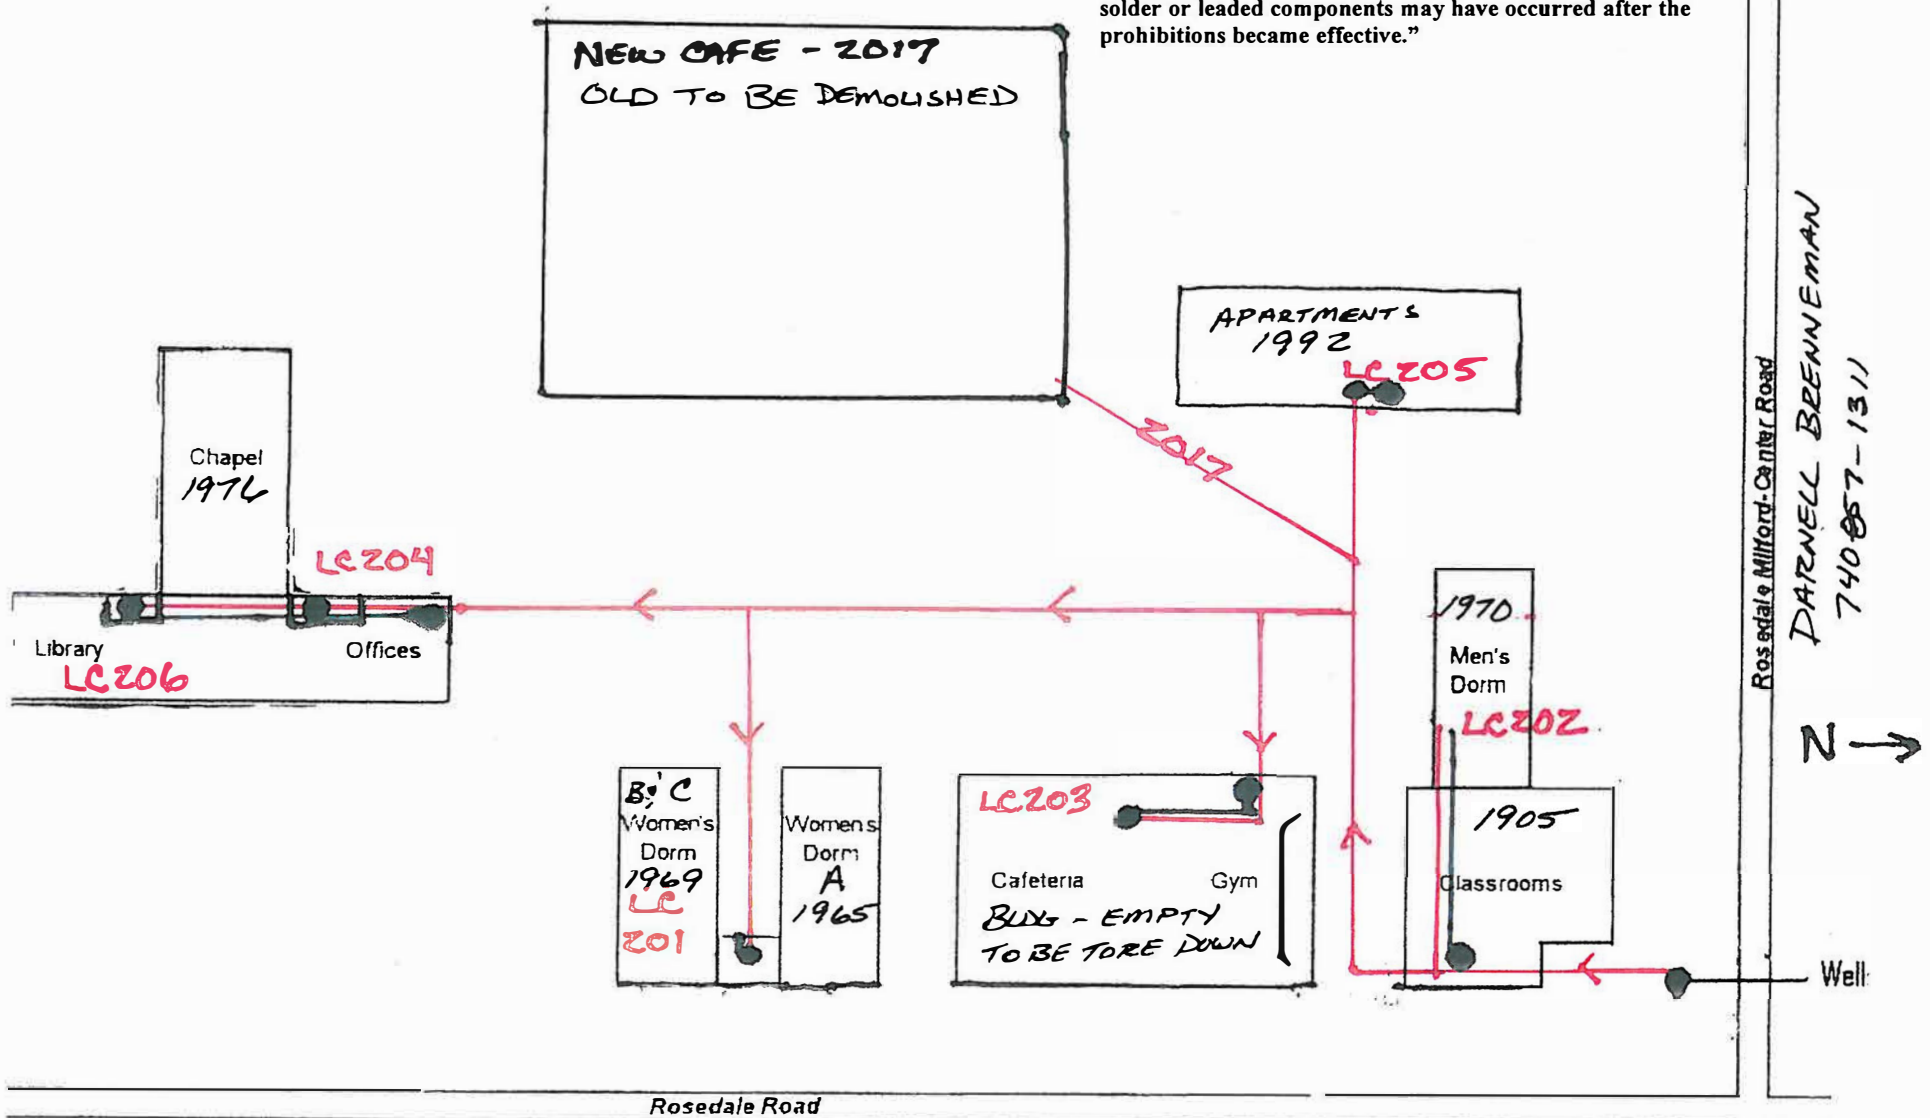

DARNELL BRENNEMAN  
740 857-1311


Well

● = WATER LINES

ROSEDALE BIBLE COLLEGE

PWS OH 490211Z MADISON COUNTY  
7770 ROSEDALE RD IRWIN, OH 43029

43029

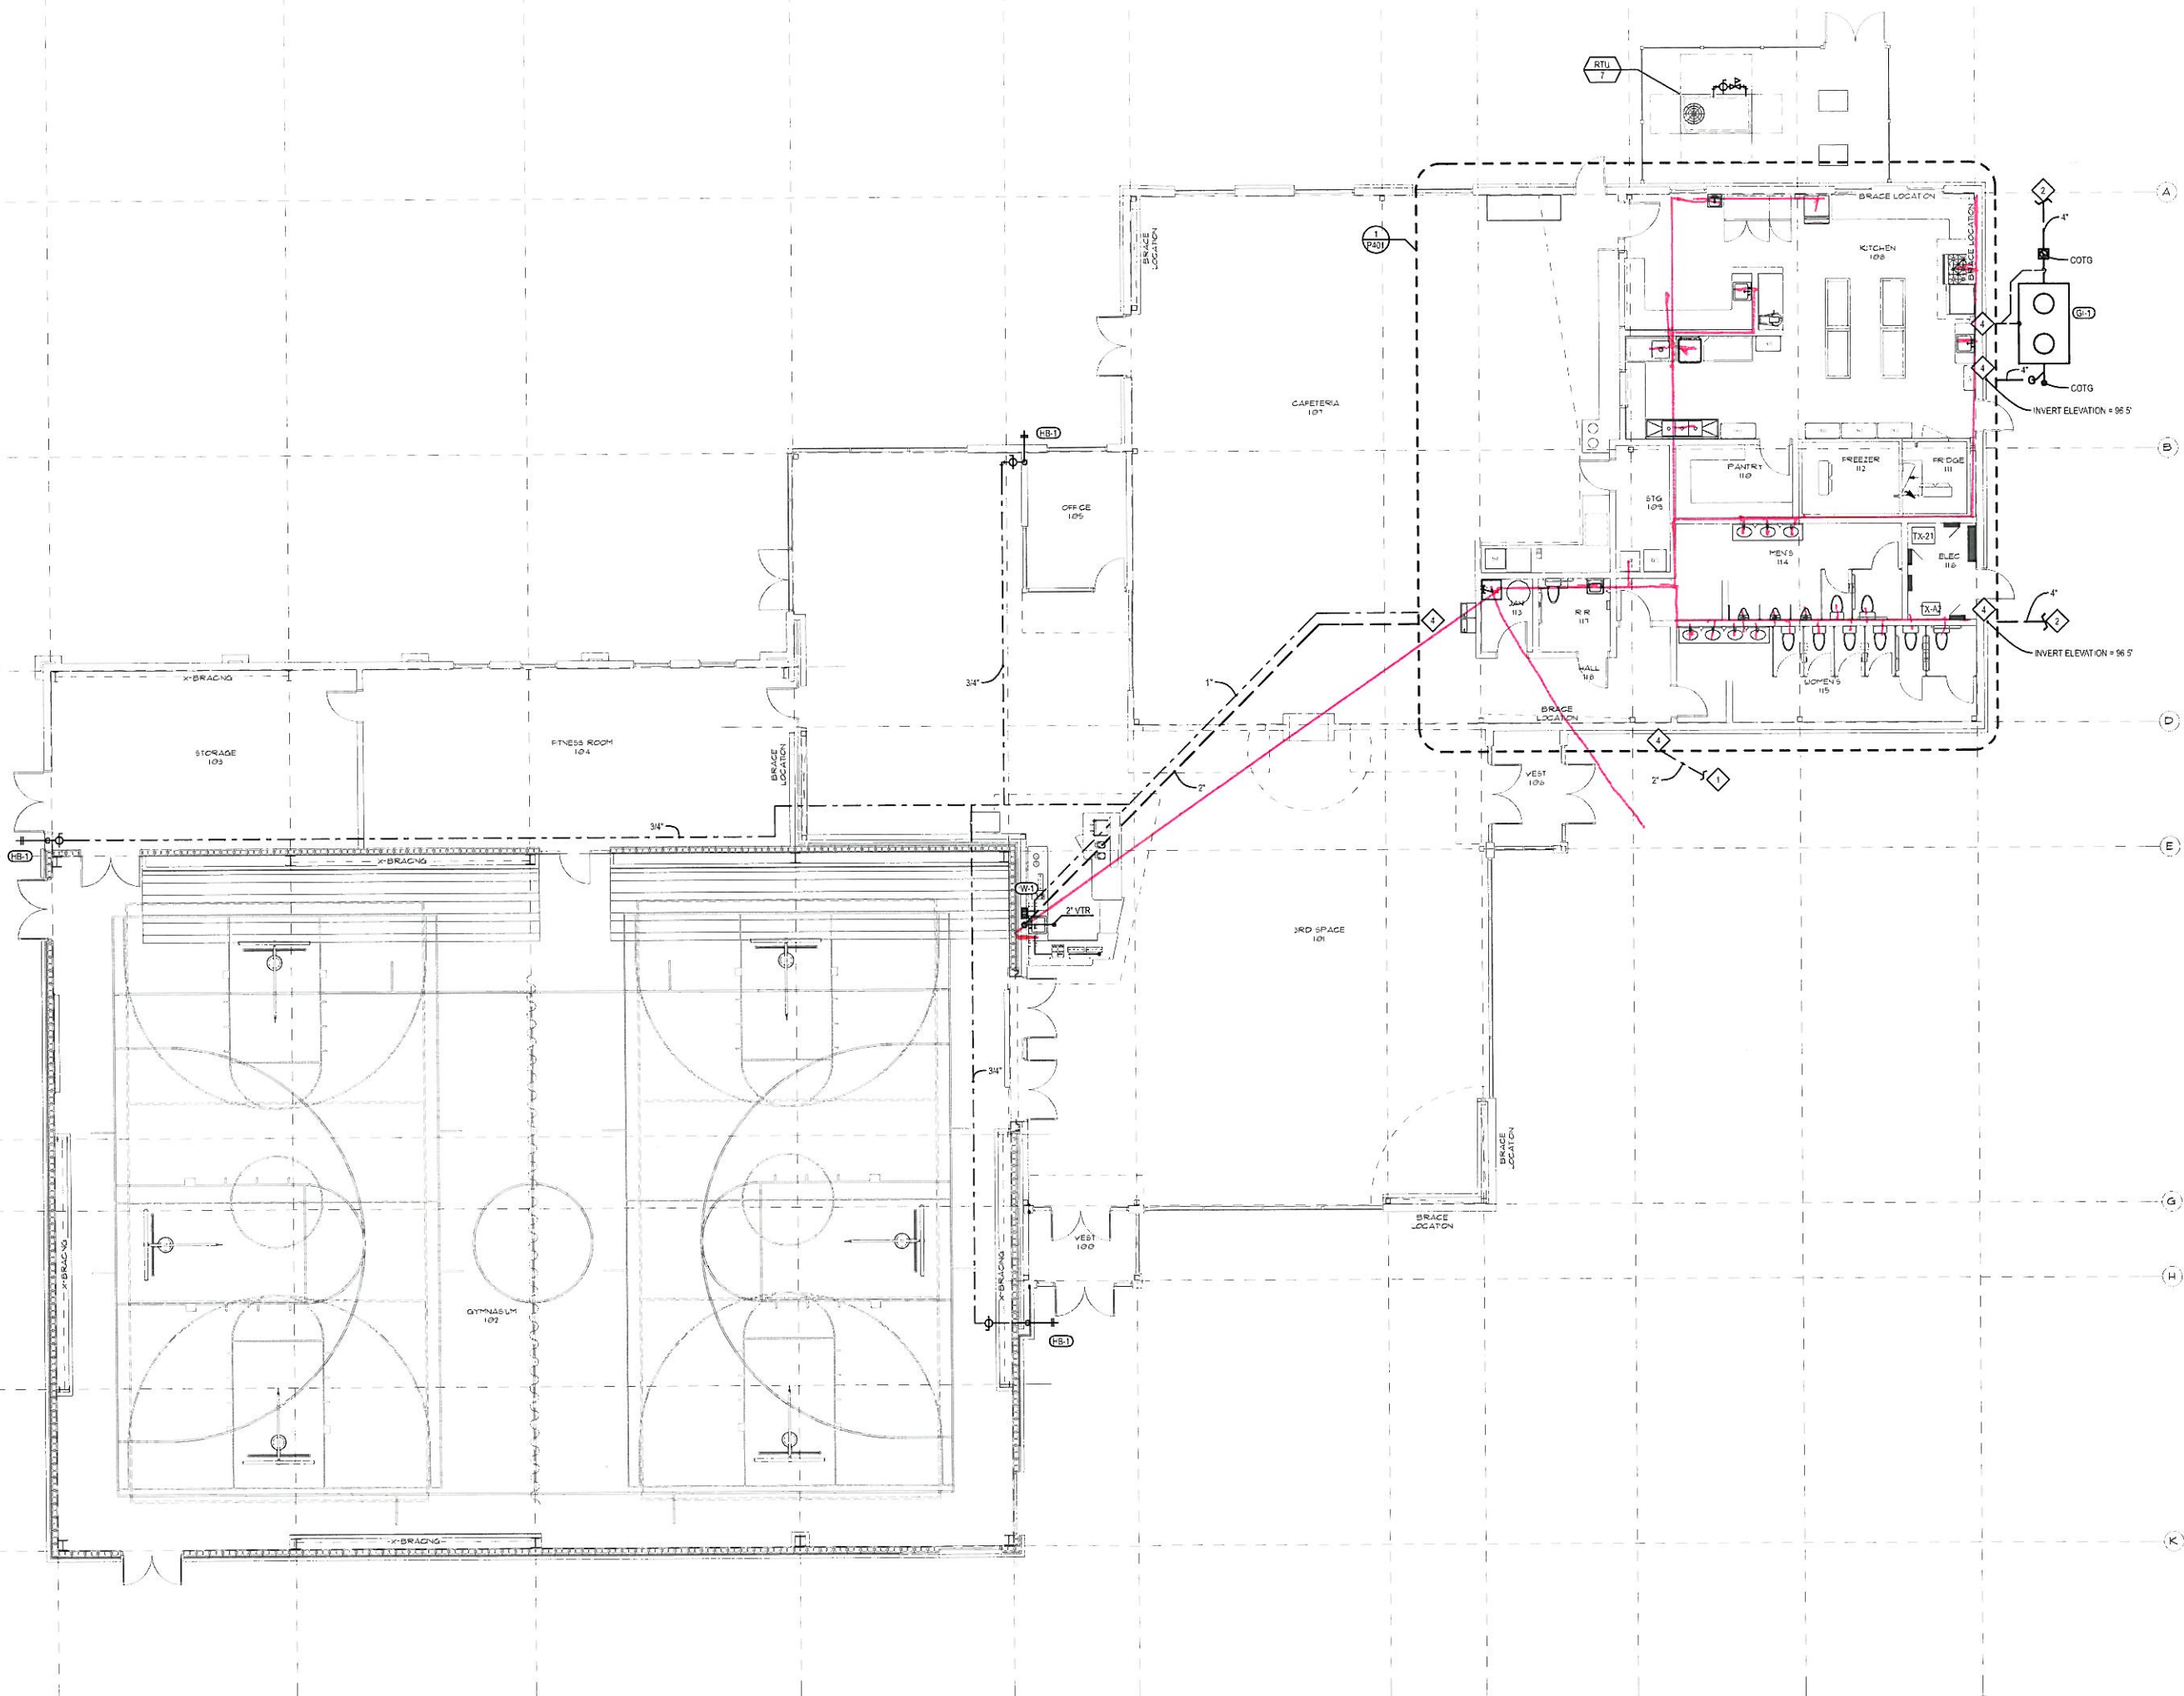

NOTE:  
FOR BRANCH SIZES TO INDIVIDUAL FIXTURES NOT  
SHOWN ON PLANS SEE PLUMBING FIXTURE  
SCHEDULE SHEET P001


#### KEYED NOTES

- 1 FOR CONTINUATION OF WATER SERVICE PIPING SEE SITE PLAN
- 2 FOR CONTINUATION OF WASTE LINE SEE SITE PLAN
- 3 FOR CONTINUATION OF GAS LINE SEE SITE PLAN
- 4 FOR CONTINUATION OF PIPING SEE PLUMBING ENLARGEMENTS SHEET P401
- 5 GAS METER SIZE FOR 1 101 CFH AT 2 PSIG METER AND YARD LINE BY GAS COMPANY
- 6 DROP A 3/4" GAS LINE DOWN AND TIE INTO WATER HEATER PROVIDE SHUT-OFF VALVE IN AN ACCESSIBLE LOCATION AND AS CLOSE TO WATER HEATER AS POSSIBLE ON OUTSIDE OF WATER HEATER CABINET
- 7 RISE GAS LINE UP TO ROOF FOR CONTINUATION OF PIPING SEE PLUMBING ROOF PLAN SHEET P102
- 8 RISE 3/4" LINE TO ROOF FOR HOSE BIBS
- 9 RUN PIPING ABOVE CEILING
- 10 EXTEND 3" PLENUM RATED CVPC EXHAUST AND INTAKE PIPES FROM WATER HEATER TO ROOF TERMINATE THRU ROOF WITH CONCENTRIC KIT
- 11 PROVIDE AND INSTALL GAS PRESSURE REDUCING VALVE VENT TO OUTSIDE AS REQUIRED
- 12 ROOF DRAIN LINE TO DAYLIGHT WITH DOWNSPOUT NOZZLE AT 12" ABOVE GRADE
- 13 FOR CONTINUATION OF ROOF DRAIN LINE SEE CIVL PLAN
- 14 RUN ROOF DRAINS @ 1/4" PER 12' SLOPE



B


PAVEASPH

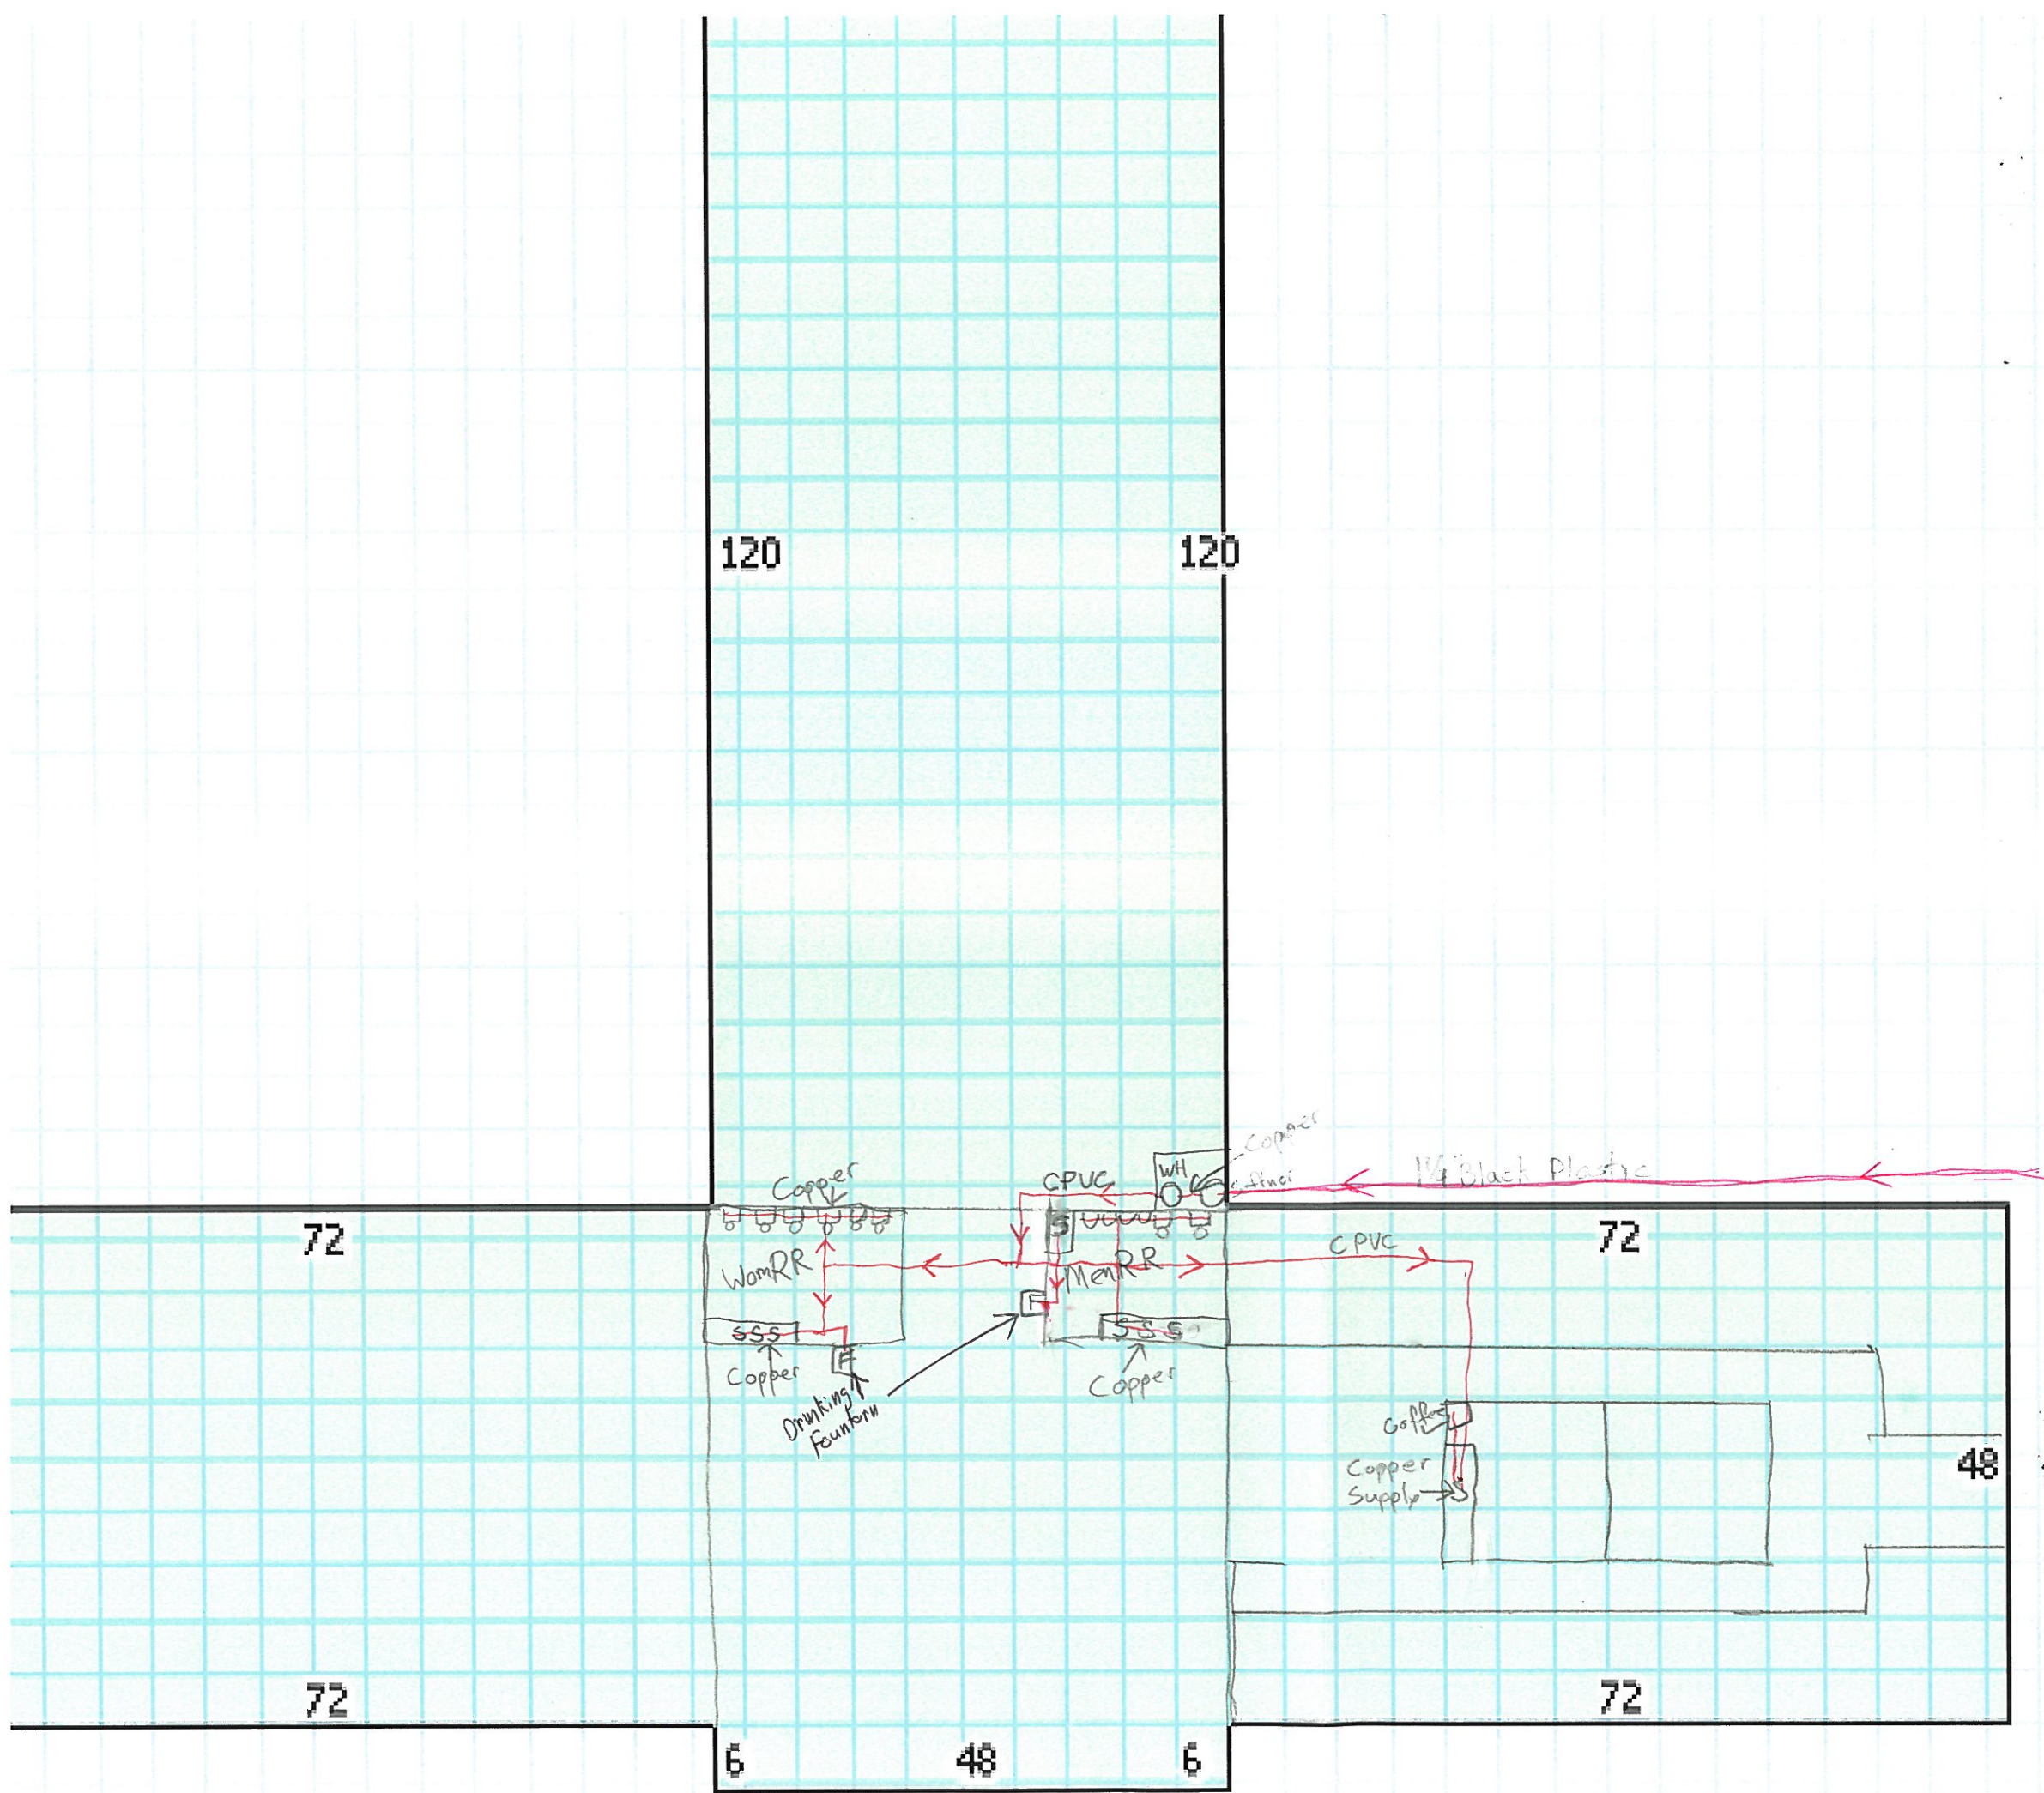

Chapel / library / Admin  
1976



1965 COPPER LINES

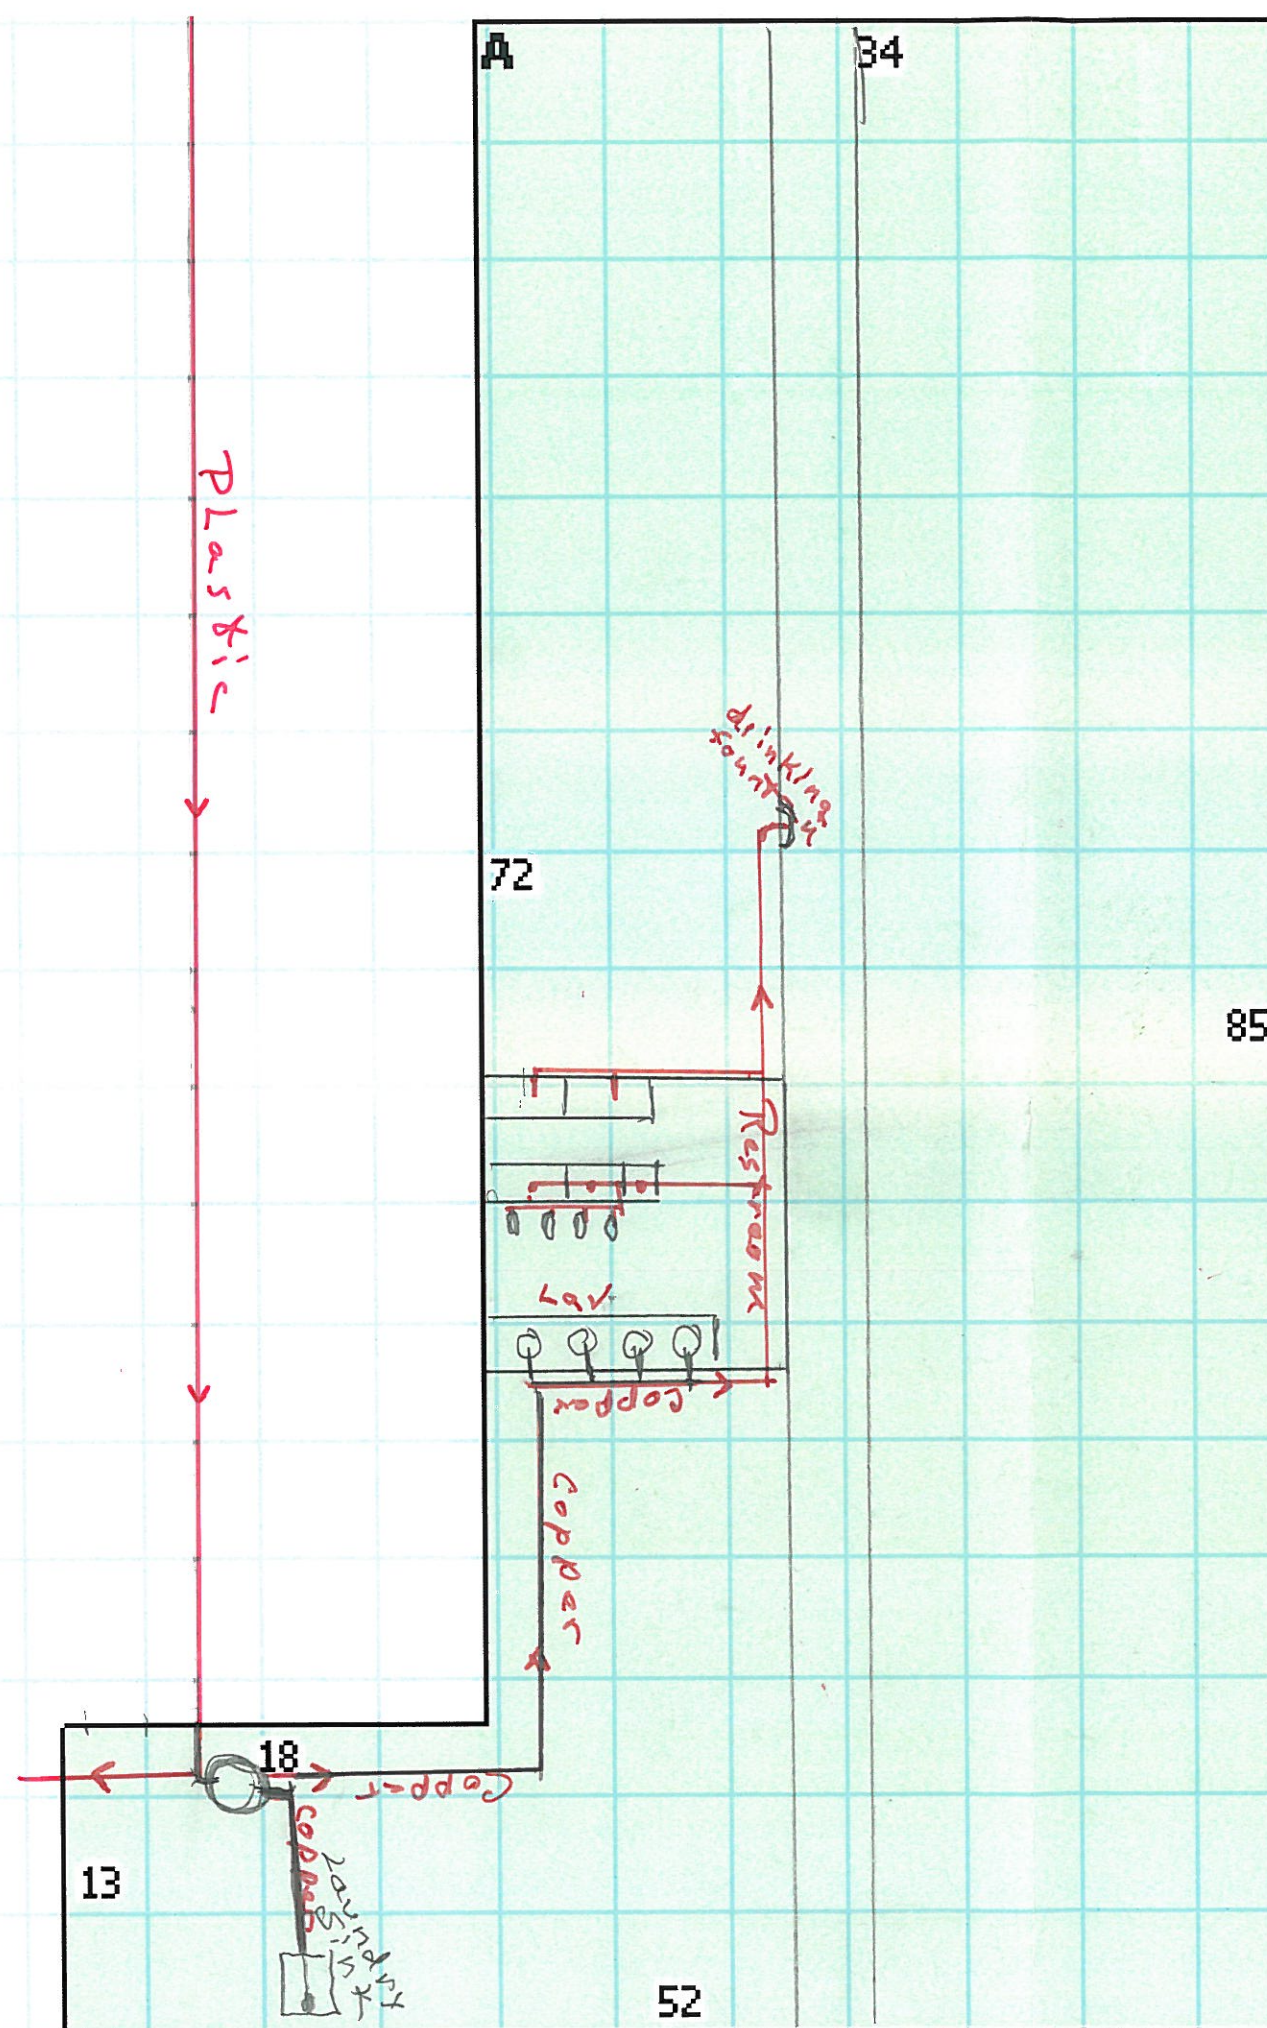



Scale: 1" = 10'

A GFA  
3094 sqft


Women's Dorm  
Hall B

↗ N


LOWER LEVEL  
1ST FLOOR

1969

COPPER LINES

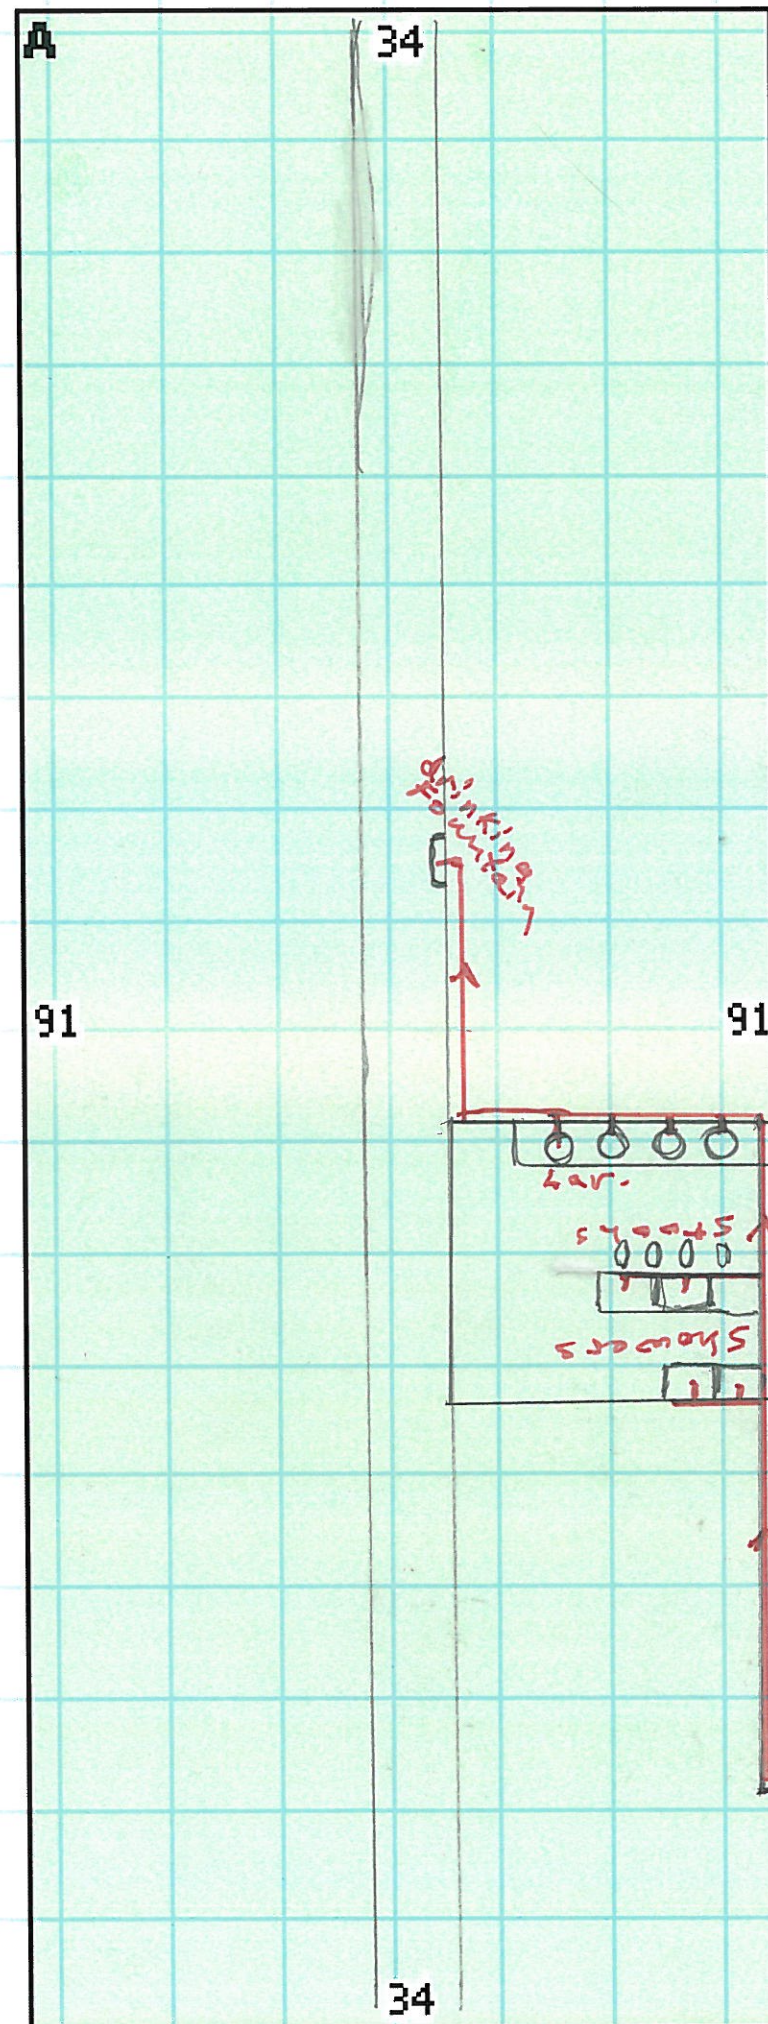



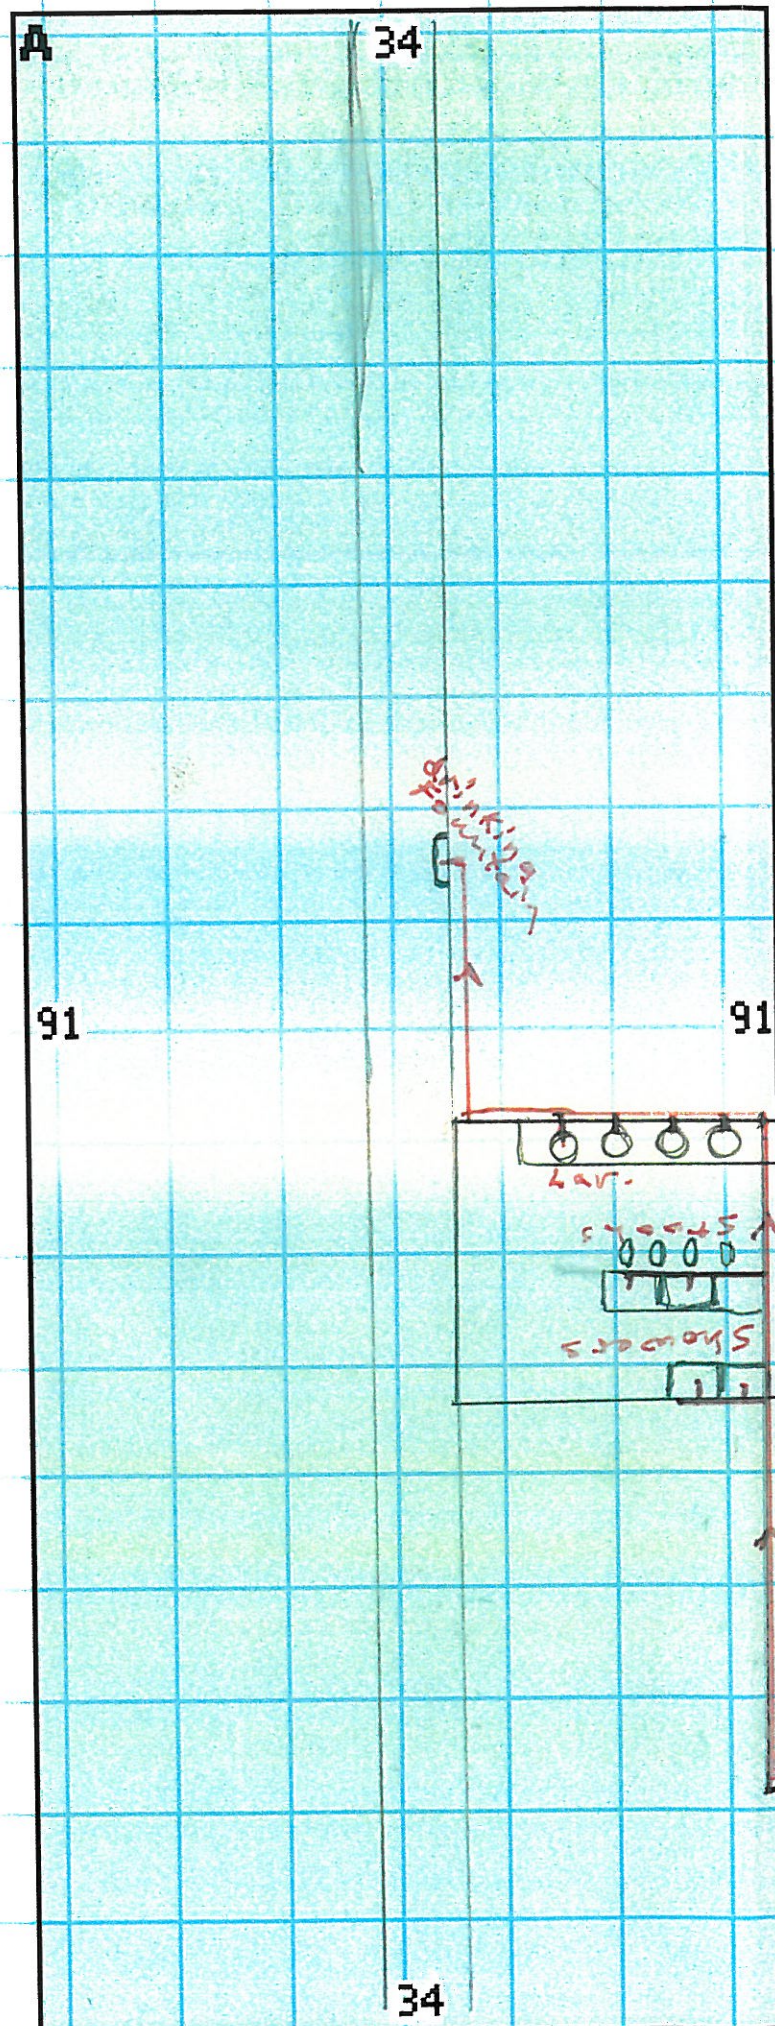

A GFA  
3094 sqft



Women's Dorm  
Hall C


UPPER LEVEL  
2ND FLOOR

1969


COPPER LINES




A GFA  
3372 sqft

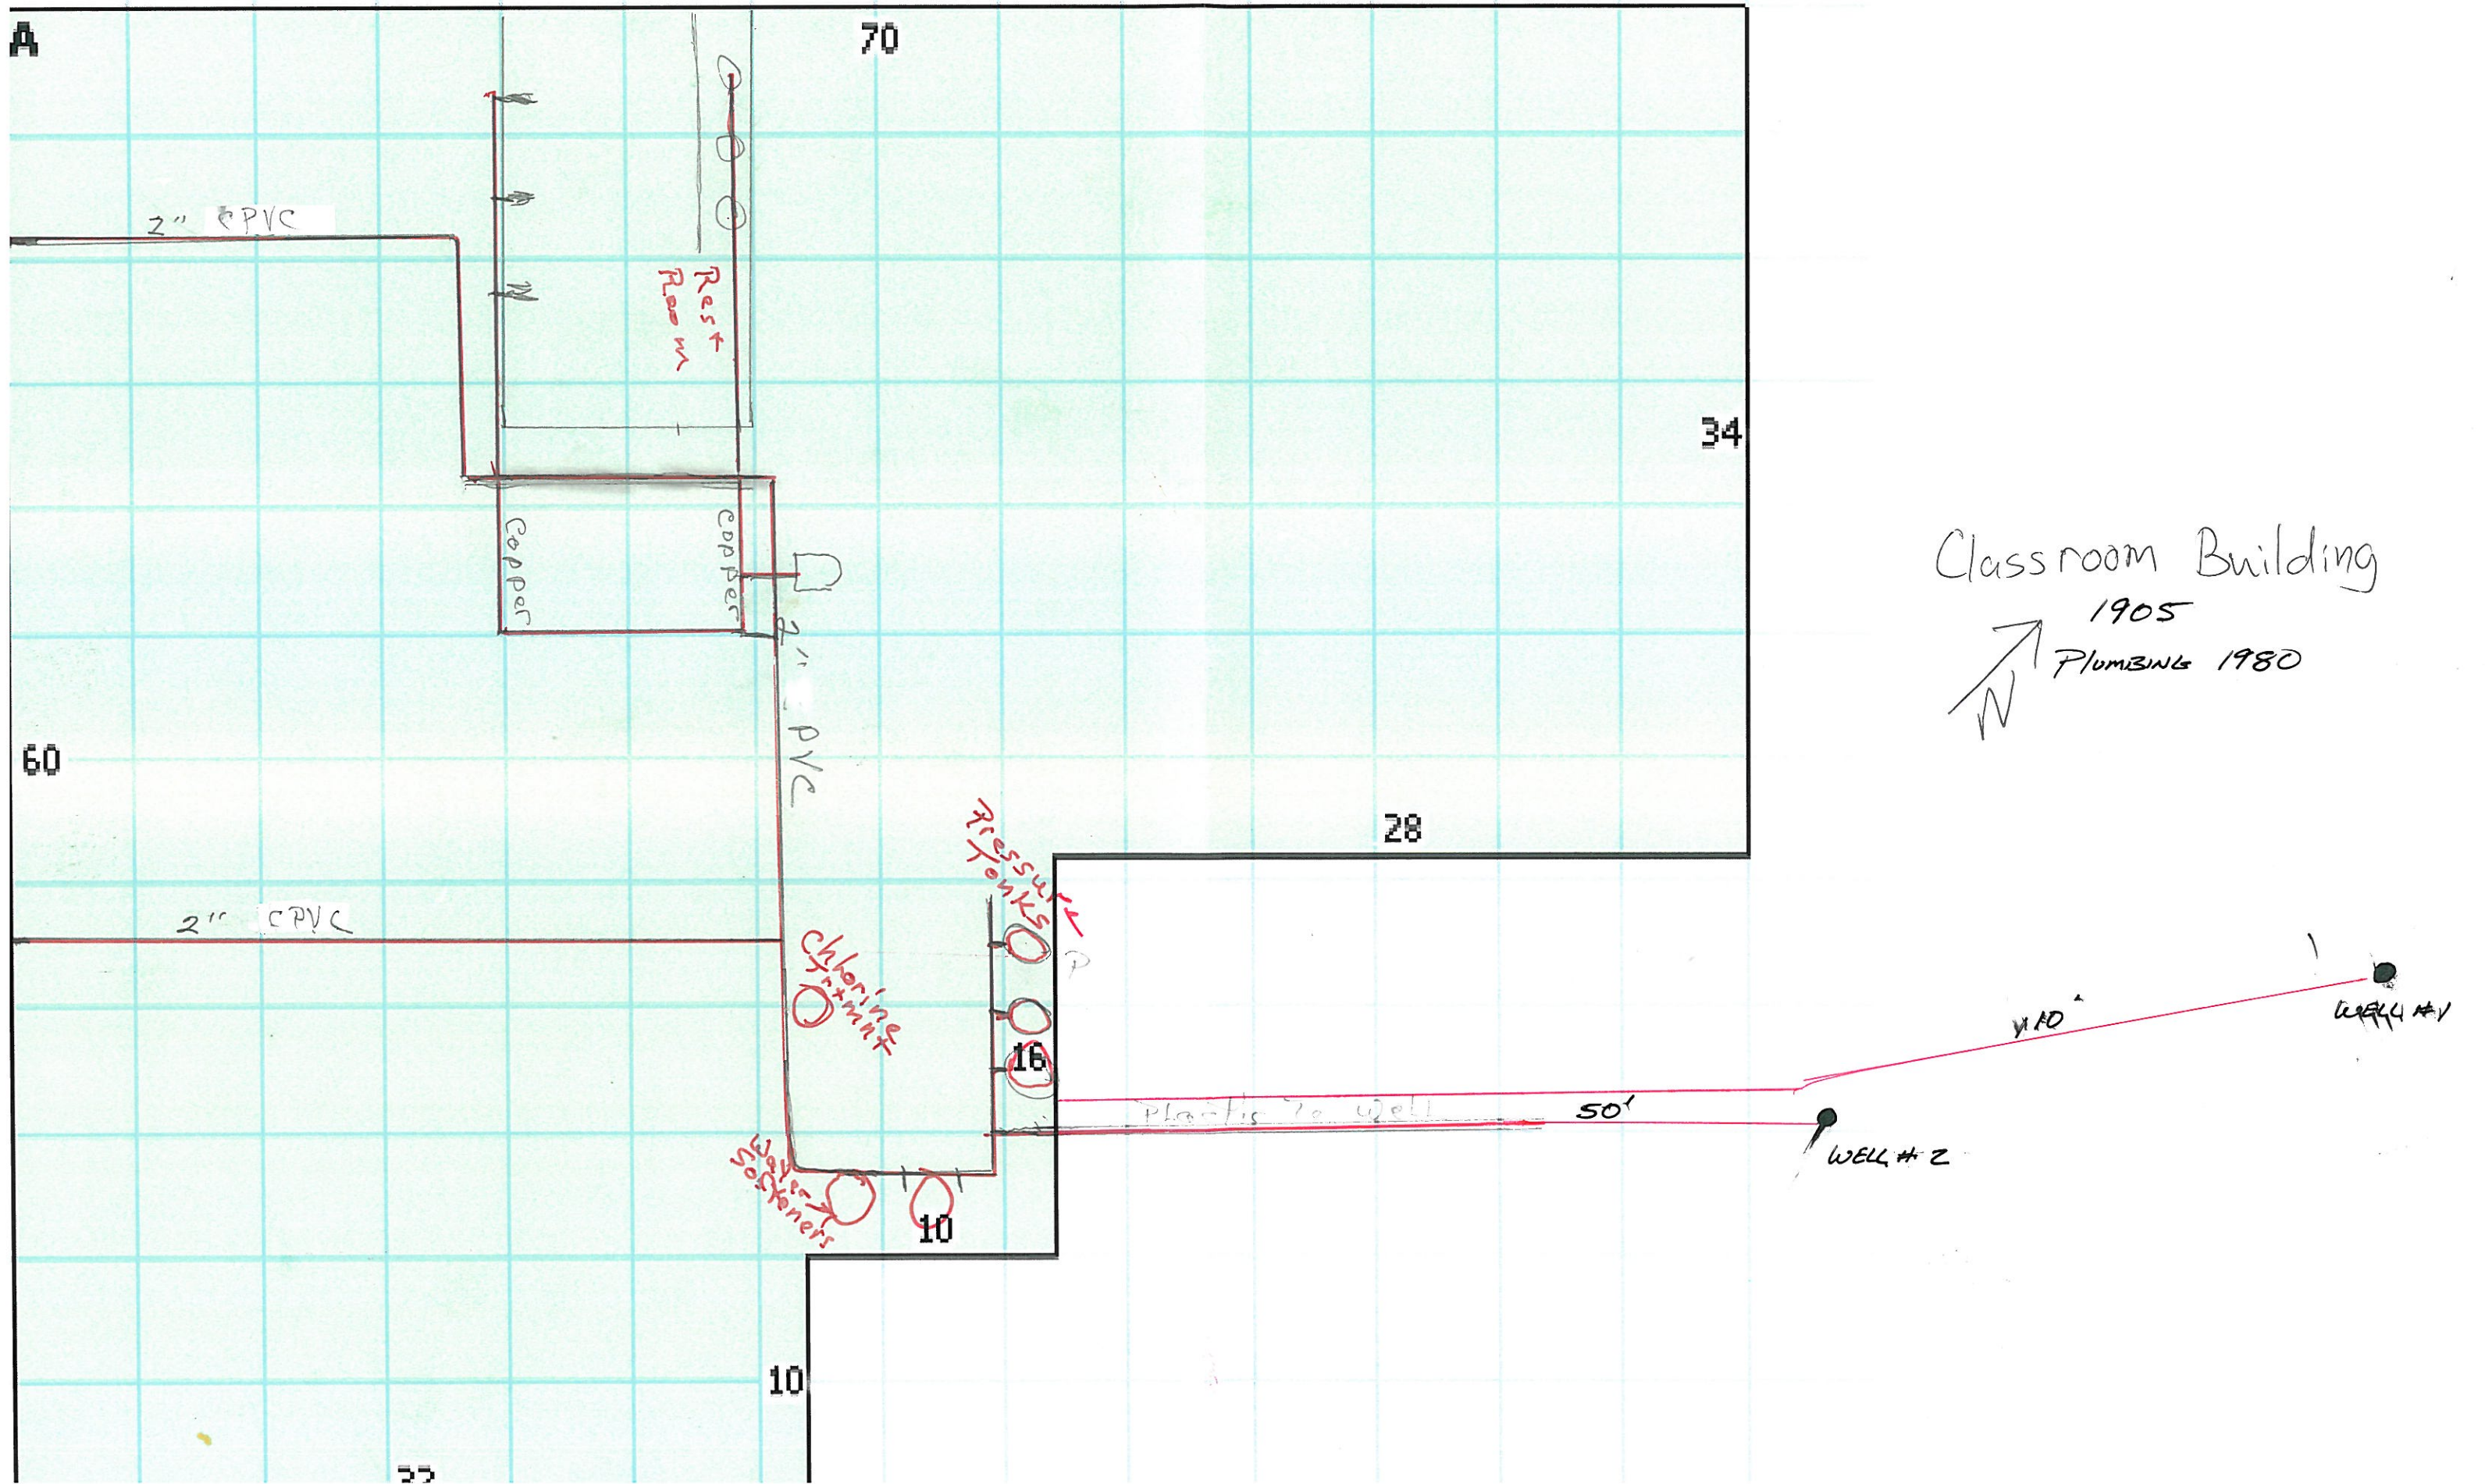



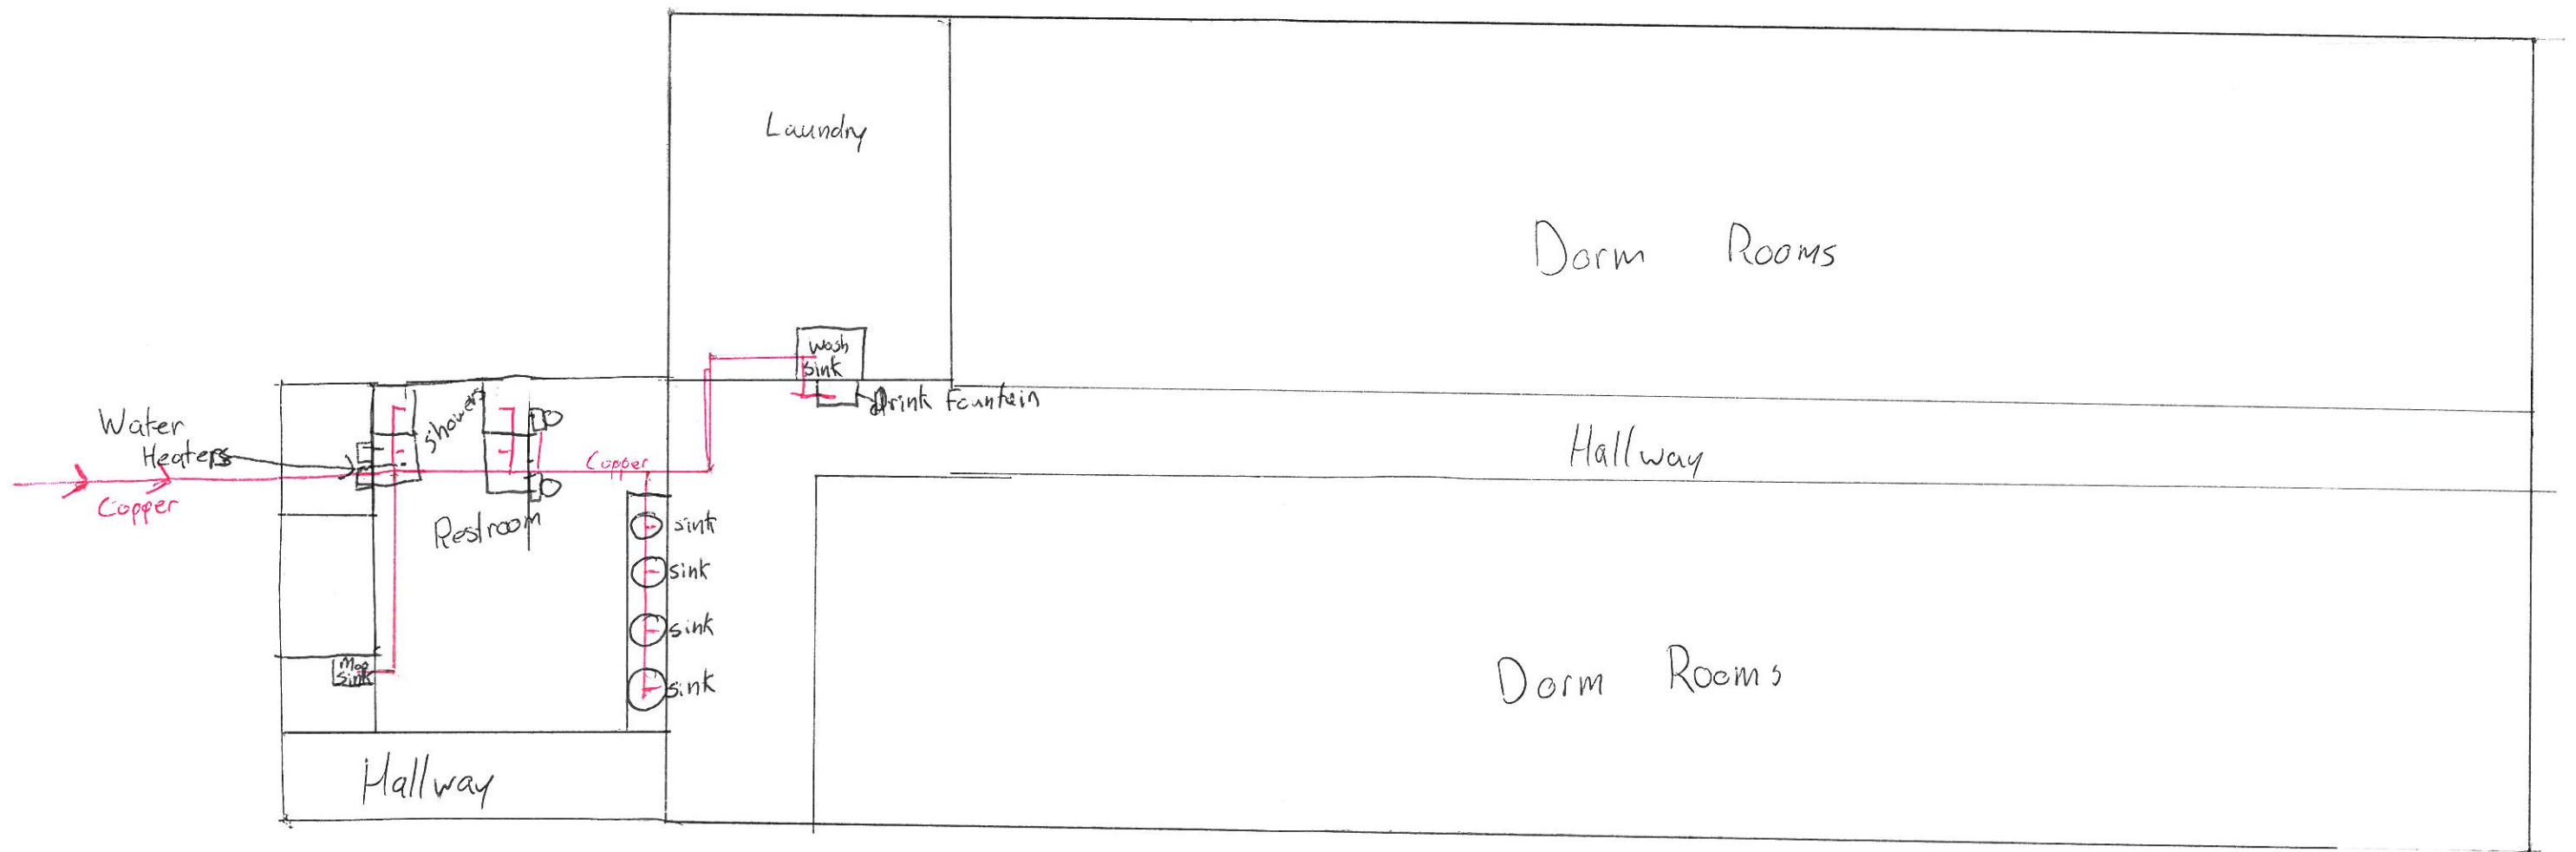




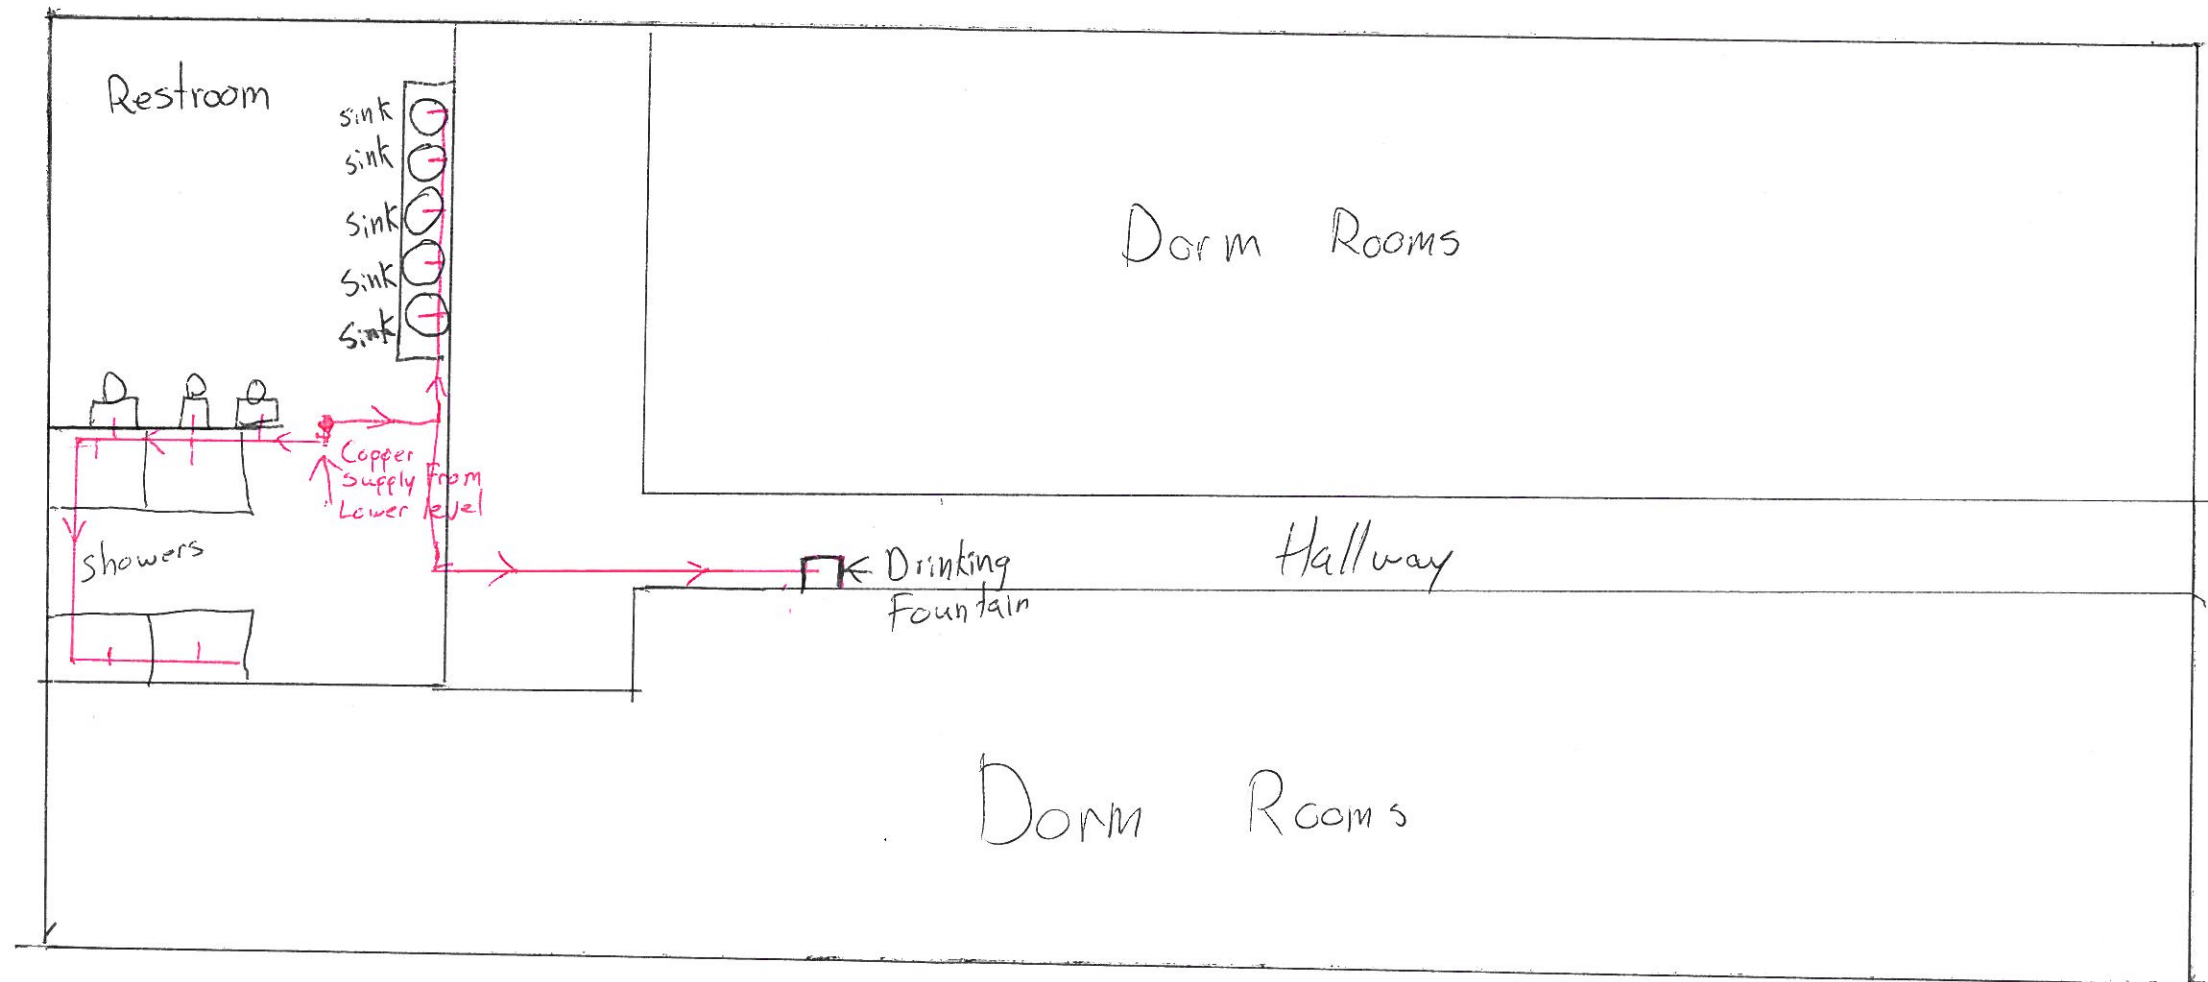

Men's Dorm  
Level 2  
2ND FLOOR





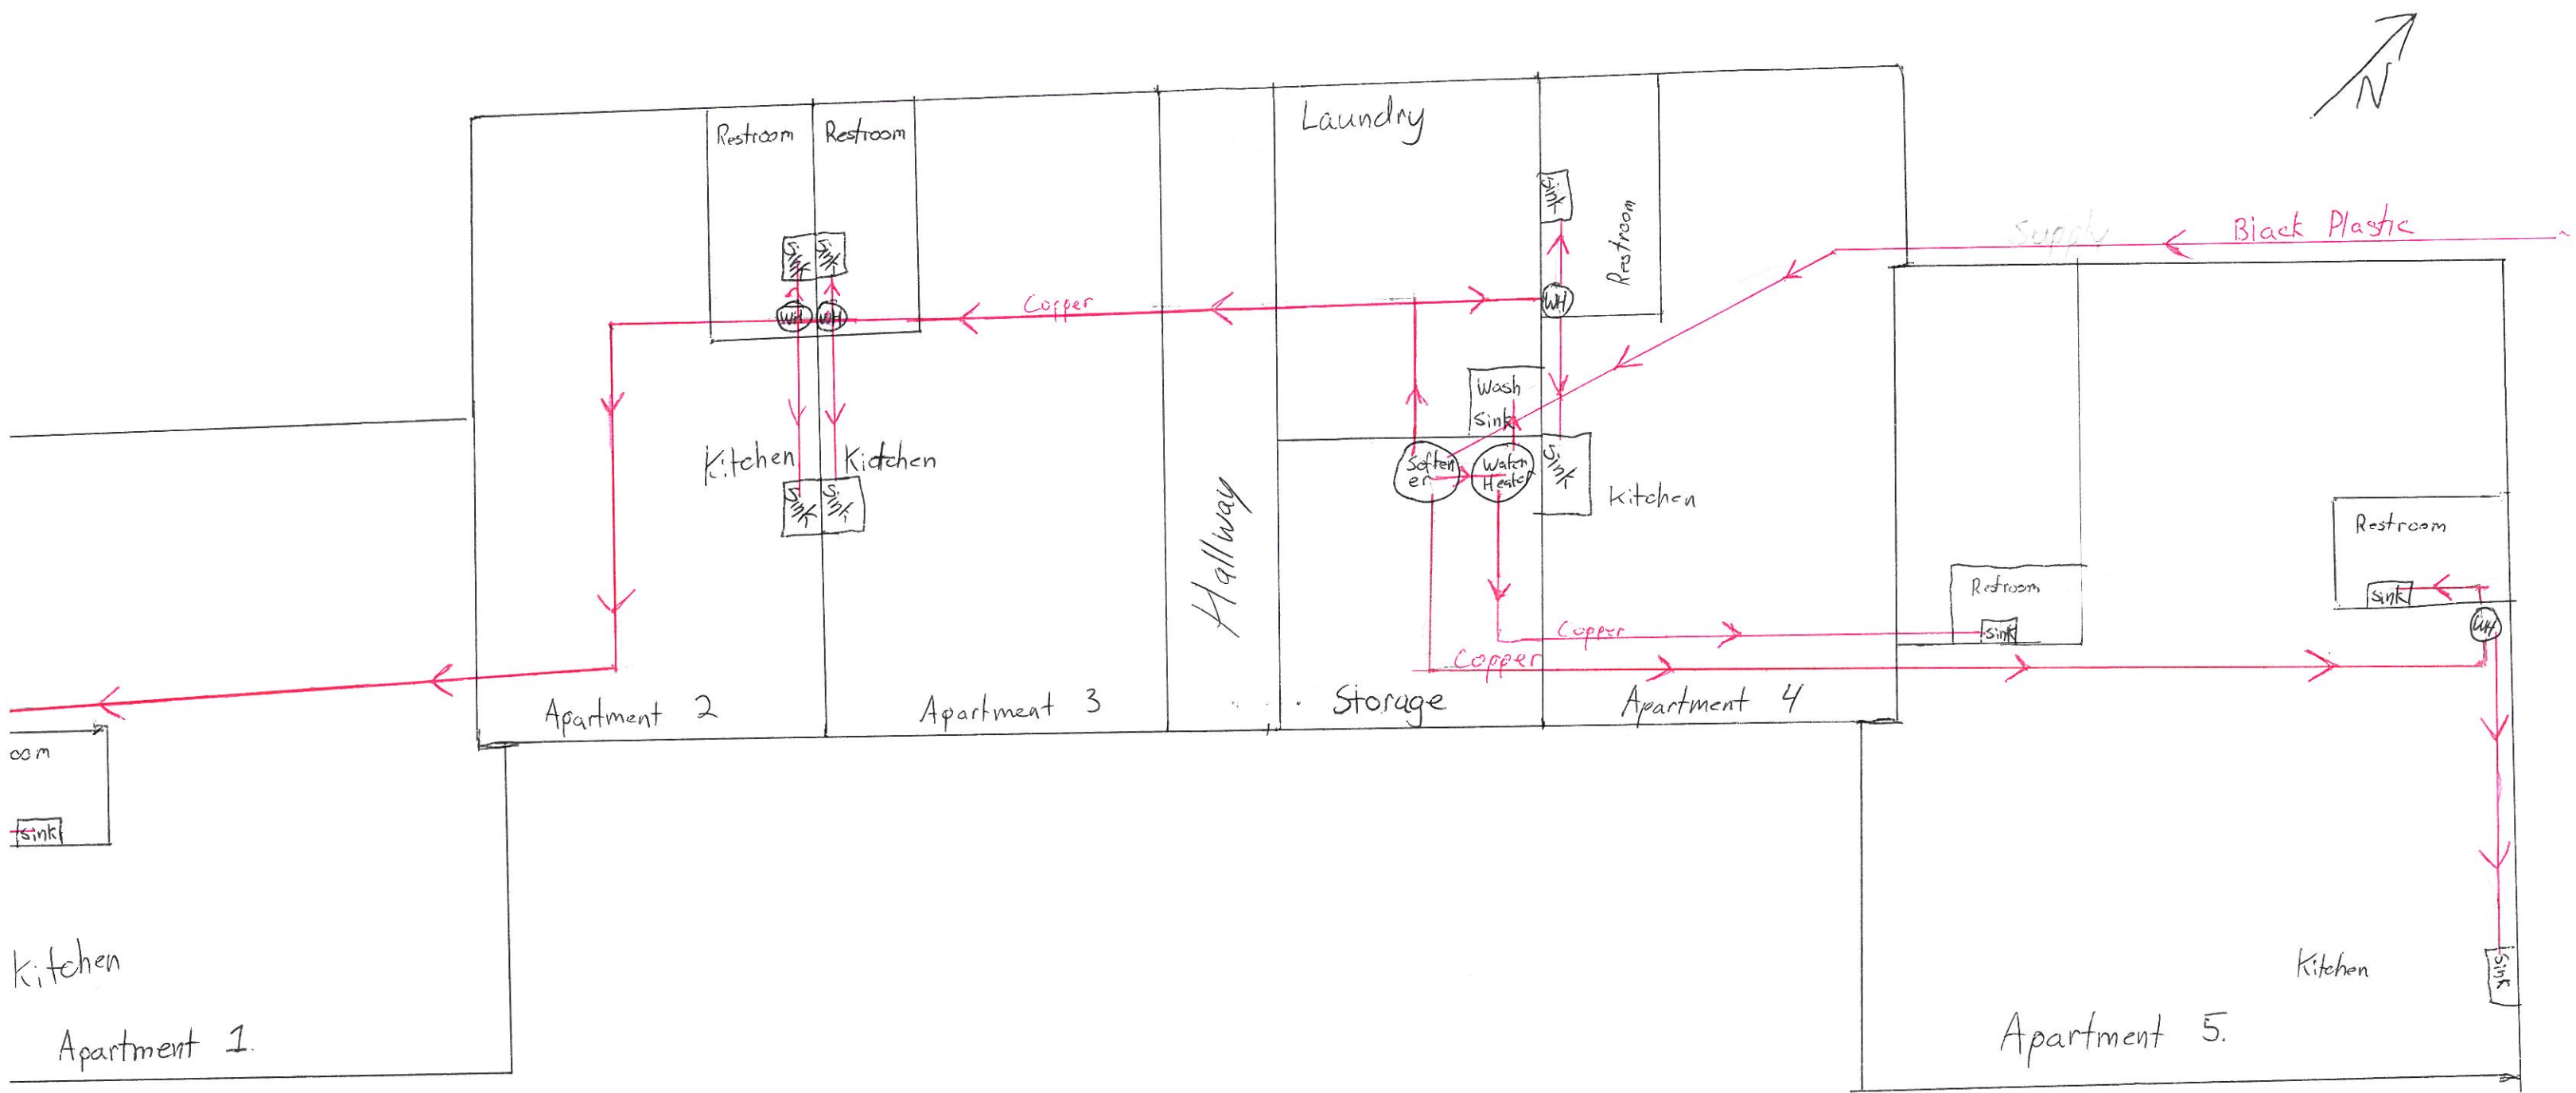

Apartments Level 1  
1<sup>ST</sup> FLOOR  
1992







