



**BUCKEYE TRANSFER, INC.  
PWS ID # OH 1566212  
FLOOR PLAN FOR OFFICE BLDG  
FACILITY ID# 1562492**

**All plumbing in this facility was replaced in 2004 with copper and schedule 80 pvc.  
All repairs in the building and underground have been done with schedule 80 pvc.  
All faucets in the restrooms and kitchens are lead free.**

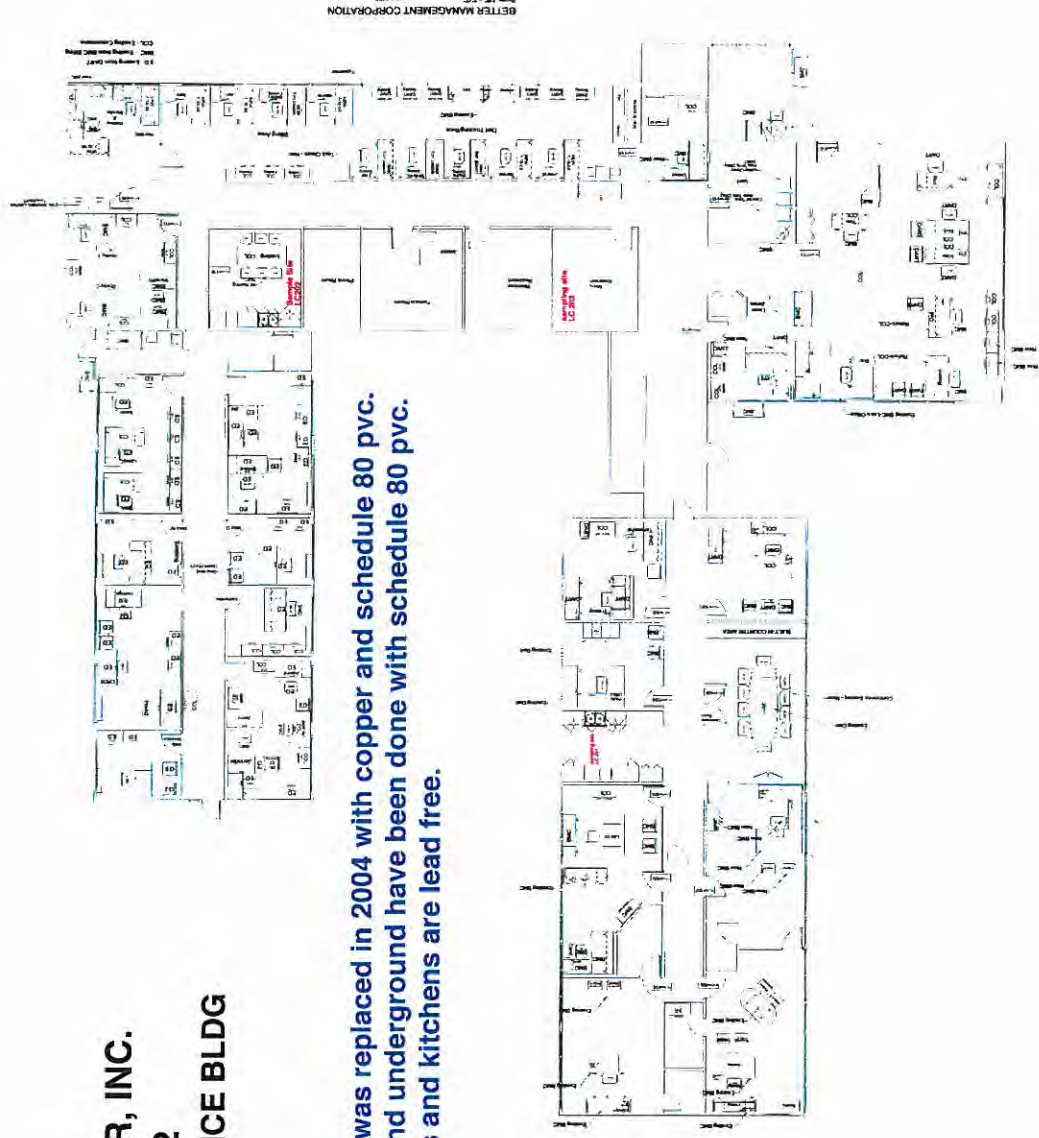

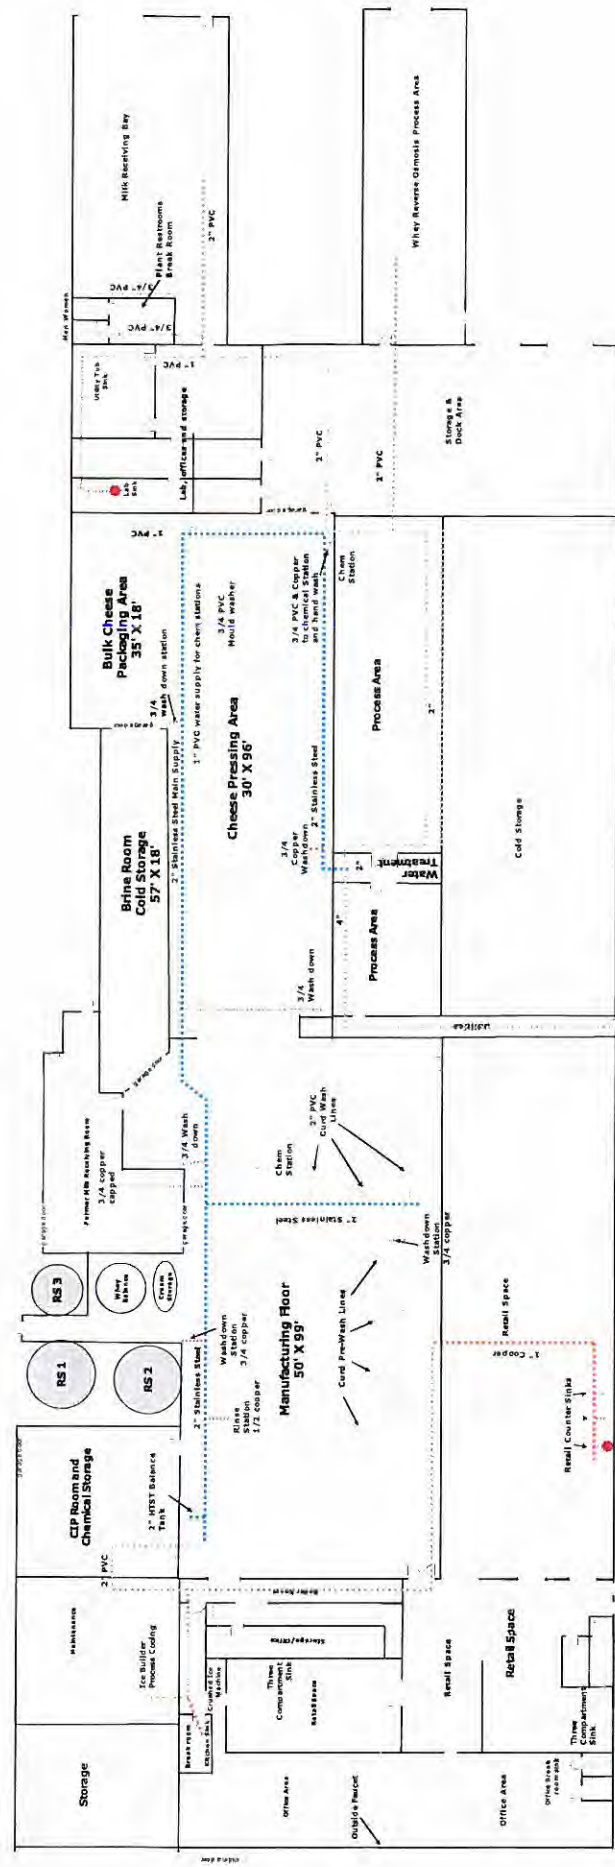

Prepared: 3/7/2017  
Prepared by: Robert Troyer



Legend  
 ● Tier 1 Sample Site  
 ..... PVC or Pexis  
 - - - - - Stainless Steel  
 ..... Copper  
 ..... Galvanized

Copper Copper installed from 1986 thru 2008



**BUCKEYE TRANSFER, INC.**  
**PWS ID # OH1566212**  
**FACILITY ID#S 1562492 & 1562493**

**All supply mains from water plant to facilities and fire hydrants is ductile iron.**

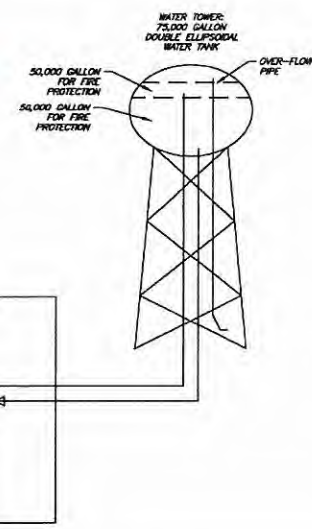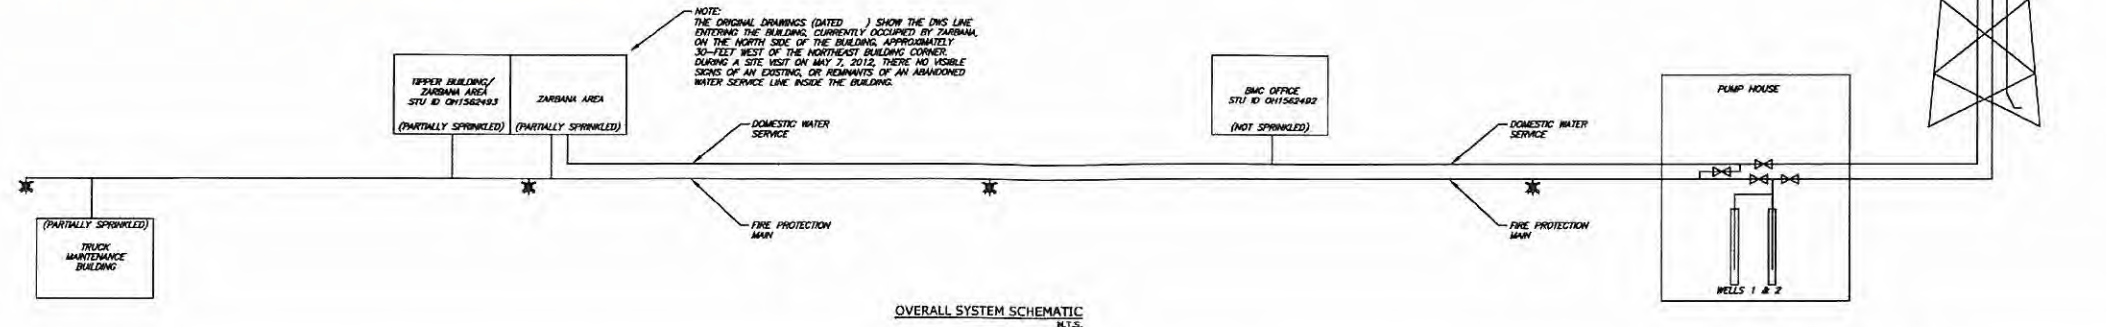

NOTE: THE ORIGINAL DRAWINGS (DATED ) SHOW THE DWS LINE ENTERING THE BUILDING CURRENTLY OCCUPIED BY ZARBANA ON THE NORTH SIDE OF THE BUILDING, APPROXIMATELY 30- FEET WEST OF THE NORTHEAST BUILDING CORNER. DURING A SITE VISIT ON MAY 7, 2012, THERE NO VISIBLE SIGNS OF AN EXISTING, OR REMAINS OF AN ABANDONED WATER SERVICE LINE INSIDE THE BUILDING.

PREPARED BY:  
**BUCKEYE CIVIL DESIGN, LLC**  
 "A Civil Engineering and Land Planning Company"  
 North Lima, Ohio 44452  
 P.O. Box 289  
 Phone: 330-949-9051 Fax: 330-949-9053

PREPARED FOR:  
**BUCKEYE TRANSFER, INC.**  
 C/O JERRY STONEBURNER  
 P.O. BOX 130  
 41738 ESTERLY DRIVE  
 COLUMBIANA, OHIO 44408  
 Ph 330-482-9073  
 Fx 330-482-9931

NO.	REVISIONS
1)	
2)	
3)	
4)	
5)	

DESIGNED BY: JMG  
 DRAWN BY: JPL  
 CHECKED BY: JPL  
 JOB NUMBER: 0331-12  
 DWG FILE: 0331-base.dwg  
 DATE: 03-29-2012


**BUCKEYE TRANSFER, INC.**  
 PUBLIC WATER SYSTEM  
**PRELIMINARY**  
 SCHEMATIC PLANS

SCALE  
 N.T.S.

SHEET NUMBER  
 2 OF ?




UPPER BUILDING/ZARBANA AREA  
 STU ID OH1562493

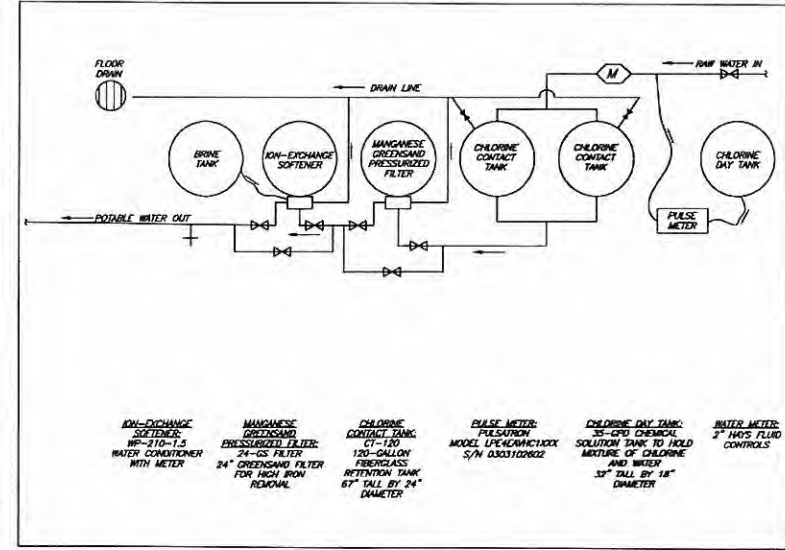

- IRON-EXCHANGE SOFTENER: WP-210-1.5 WATER CONDITIONER WITH METER
- MANGANESE GREENSAND PRESSURIZED FILTER: 24" CS FILTER
- CHLORINE CONTACT TANK: CT-120 120-GALLON FIBERGLASS RETENTION TANK 67" TALL BY 24" DIAMETER
- PULSE METER: MODEL UPE4CMCT100X S/N 0303120602
- CHLORINE DAY TANK: 35-GPD CHEMICAL SOLUTION TANK TO HOLD MIXTURE OF CHLORINE AND WATER 32" TALL BY 18" DIAMETER
- WATER METER: 2" HVS FLUID CONTROLS




SMC OFFICE  
 STU ID OH1562492

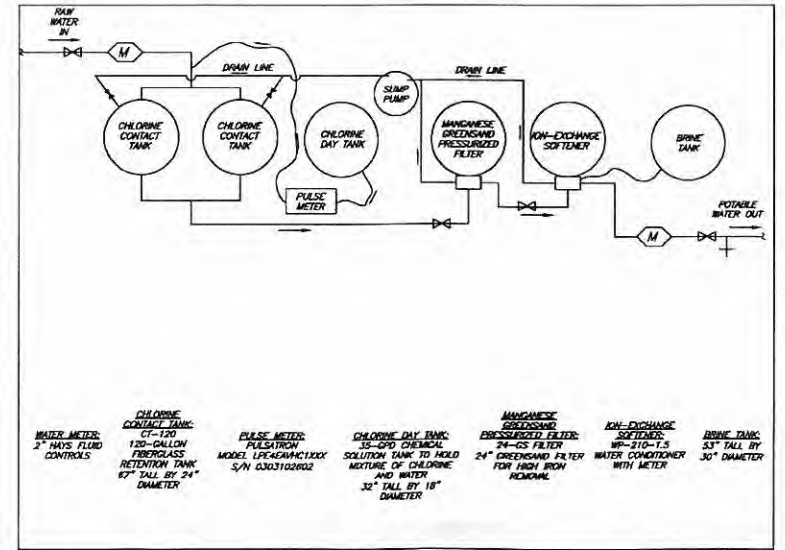

- CHLORINE CONTACT TANK: CT-120 120-GALLON FIBERGLASS RETENTION TANK 67" TALL BY 24" DIAMETER
- PULSE METER: PULSATRON MODEL UPE4CMCT100X S/N 0303120602
- CHLORINE DAY TANK: 35-GPD CHEMICAL SOLUTION TANK TO HOLD MIXTURE OF CHLORINE AND WATER 32" TALL BY 18" DIAMETER
- MANGANESE GREENSAND PRESSURIZED FILTER: 24" CS FILTER
- IRON-EXCHANGE SOFTENER: WP-210-1.5 WATER CONDITIONER WITH METER
- BRINE TANK: 30" TALL BY 30" DIAMETER



PUMP HOUSE

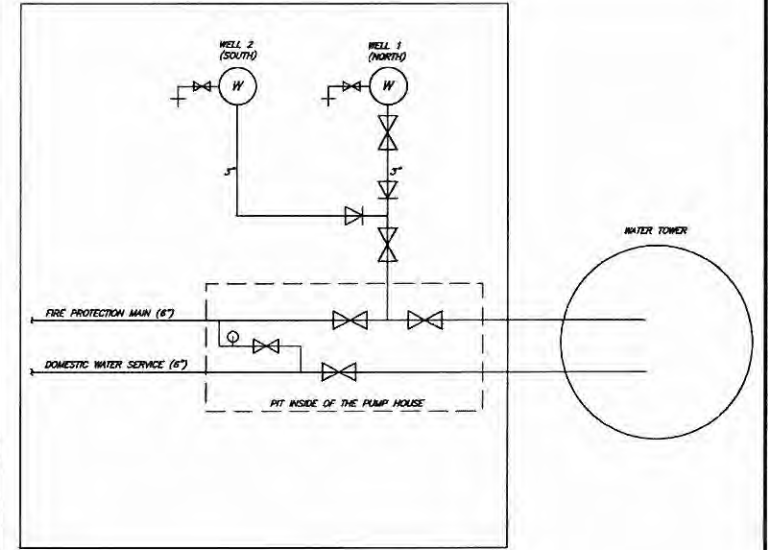

LEGEND

- WELL
- FIRE HYDRANT
- SAMPLE TAP
- VALVE
- CHECK VALVE
- AIR RELEASE VALVE
- METER

P:\Projects\2012\1566212\1566212.dwg (3/29/2012) 11:24 AM