


RE: Faith UM Church of Richland County
Report
Drinking Water Program
Richland County
PWS ID: OH7057112



FAITH UM CHURCH

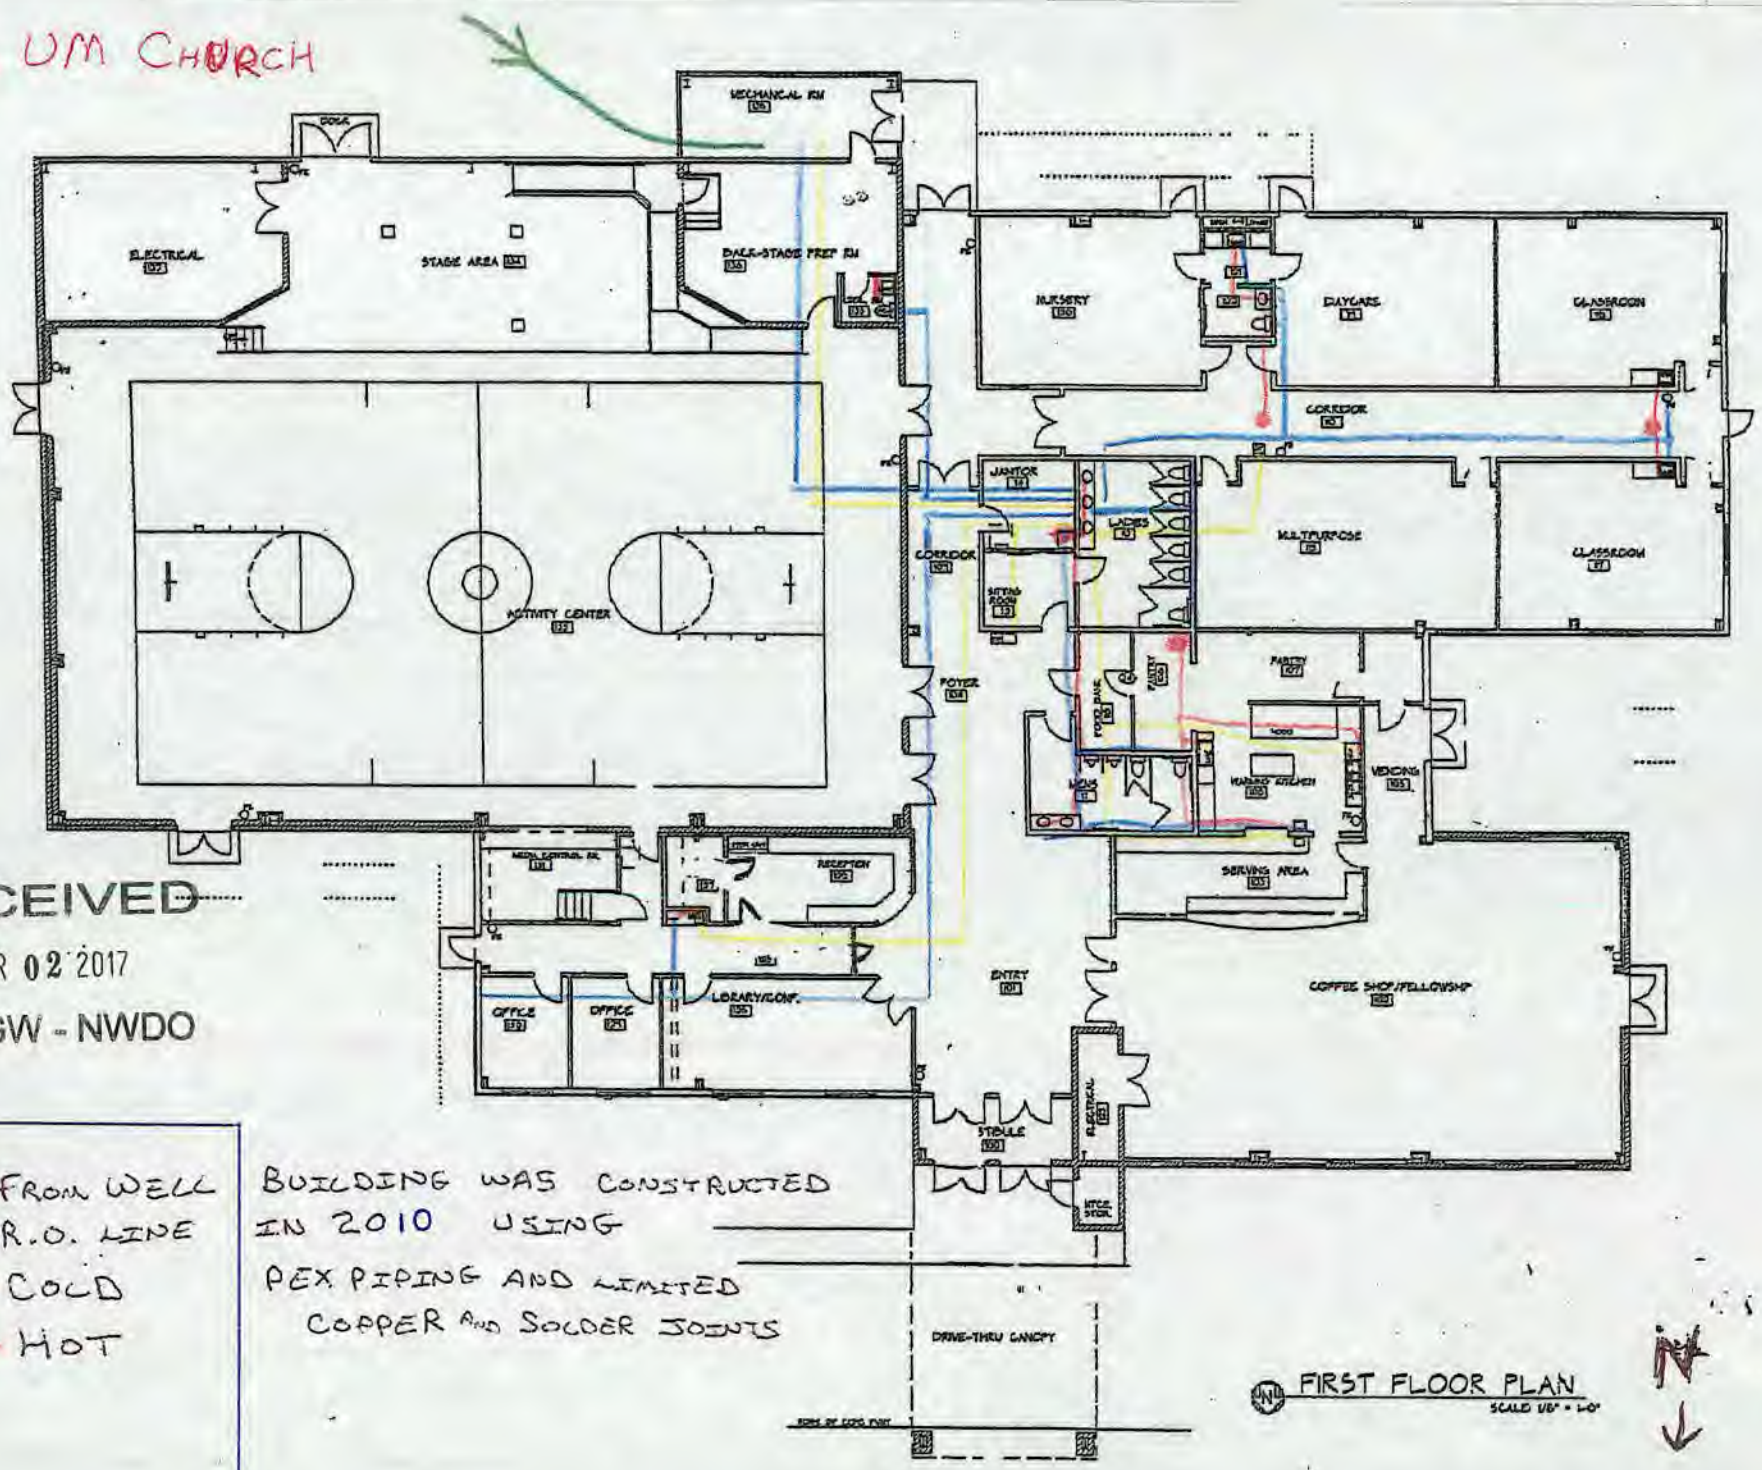

RECEIVED

MAR 02 2017

DDAGW - NWDO

- FROM WELL
- R.O. LINE
- COLD
- HOT

BUILDING WAS CONSTRUCTED
 IN 2010 USING
 PEX PIPING AND LIMITED
 COPPER AND SOLDER JOINTS

FIRST FLOOR PLAN
 SCALE 1/4" = 1'-0"




RECEIVED

MAR 02 2017

DDAGW - NWDO

RO Water Note:

- RO conditioned water to run to:
 - Drinking Fountains: DF1 & DF-2
 - Prep Sink in Kitchen (KKS-1)
 - 3 Clean Sinks in Kitchen
 - Small sink in Office Area: L-5
 - Fountain Drink Mix Manifold in Kitchen Storage
 - Ice Machine in Room 103

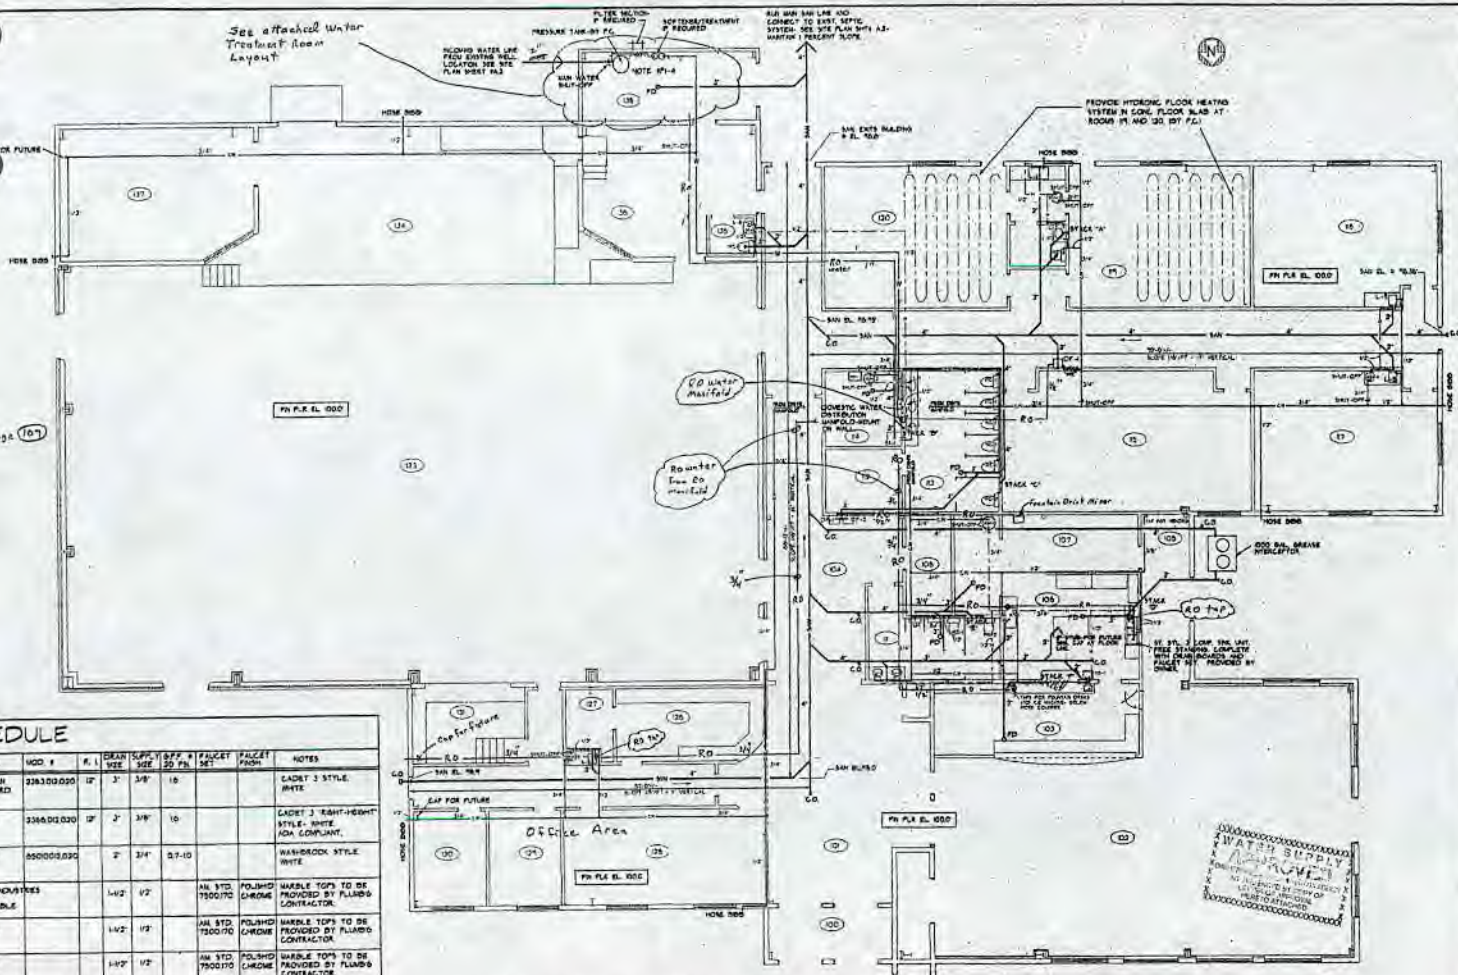

PLUMBING FIXTURE SCHEDULE

FN #	DESCRIPTION	QTY.	LOCATION	MANUF.	MOD #	R. I.	FIN. SIZE	SPR. #	FAUCET SET	FAUCET FINISH	NOTES
WC-1	VT. CHINA WATER CLOSET, P.L.R. MOUNT, TANK TYPE, ELONGATED	6	RUMBLE 12 02	AMERICAN STANDARD	326300000	12	3"	3/8"	18		CADET 3 STYLE, WHITE
WC-2	VT. CHINA WATER CLOSET, P.L.R. MOUNT, TANK TYPE, ELONGATED	3	RUMBLE 12 18	D.O.	326600000	12	3"	3/8"	18		CADET 3 "RIGHT-HAND" STYLE, WHITE FOR COMPLIANT
U-1	VT. CHINA URINAL, WALL MOUNT, ELONGATED RIM TOP MOUNT	3	RUM 9	D.O.	850000000	2	3 1/4"	5/8-10			WASH-BACK STYLE, WHITE
L-1	CULTURED MARBLE WINDUDED LAV. SINKS AND BACKSPASH 32" X 22"	1	RUM 12	TOWNE INDUSTRIES OR R.D. MARBLE		1 1/2"	1 1/2"	1/2"		ALL STD. POLISHED CHROME	MARBLE TOPS TO BE PROVIDED BY PLUMBING CONTRACTOR
L-2	CULTURED MARBLE WINDUDED LAV. SINKS AND BACKSPASH 32" X 22"	1	RUM 8	D.O.		1 1/2"	1 1/2"	1/2"		ALL STD. POLISHED CHROME	MARBLE TOPS TO BE PROVIDED BY PLUMBING CONTRACTOR
L-3	CULTURED MARBLE WINDUDED LAV. SINKS AND BACKSPASH 32" X 22"	1	RUM 02	D.O.		1 1/2"	1 1/2"	1/2"		ALL STD. POLISHED CHROME	MARBLE TOPS TO BE PROVIDED BY PLUMBING CONTRACTOR
L-4	ST. STEEL UTILITY SINK-SINKLE BOWL- 29" X 22" X 8 1/2"	1	RUM 10	DAYTON	ONE-1032-A	2	1 1/2"	1/2"		ALL STD. POLISHED CHROME	
L-5	ST. STEEL HOSPITALITY SINK SINKLE BOWL- 12" X 8"	4	MUSKIE 07 18	DAYTON	D-103-1	2	1 1/2"	1/2"		ALL STD. POLISHED CHROME	
L-6	VT. CHINA LAVATORY, WALL MOUNT	3	RUM 10 02	AMERICAN STANDARD	038800000	1 1/2"	1 1/2"	1/2"		ALL STD. POLISHED CHROME	LUCERNE STYLE, WHITE FAUCET 10-83 X 4" C.
H-1	VT. CHINA HAND SINK, WALL MOUNT	1	RUM 100	D.O.	032100000	2	1 1/2"	1/2"		ALL STD. POLISHED CHROME	DELTA STYLE, WHITE FAUCET 10-83 X 4" C.
K-1	ST. STEEL KITCHEN SINK SINKLE BOWL- 32" X 22"	1	RUM 80	EMT0769		1 1/2"	1 1/2"	1/2"		ALL STD. POLISHED CHROME	SINK UNIT & SINKS PROVIDED BY OWNER
PR-1	UTILITY WOP BATH- FLOOR TYPE 24" X 24" X 1 1/4"	1	RUM 14	GLAZIER	F 03	2	1 1/2"	1/2"		ALL STD. BRASS-004	
DF-1	WALL MOUNTED, BARRIER-FREE WATER COOLER W/UPH DIAL AND BACK SPASH	3	LORES 10	ELKAY	HEM-5	2	1 1/2"	1/2"			ADA RECOMMENDED MTD HEIGHT 33" AFF. STD. DEW/DRESE FINISH
DF-2	WALL MOUNTED, CONTACT WATER COOLER	1	RUM 104	ELKAY	HEM-6-B	2	1 1/2"	1/2"			STANDARD MTD. HT. 36" AFF. STD. BRASS/BRASS FINISH

PROPOSED PLUMBING PLAN

SCALE: 1/8" = 1'-0"

PLUMBING EQUIPMENT SCHEDULE

MARK	DESCRIPTION	MANUF.	MODEL #	RATG	VOLTS	HP	REMARKS
W-1	30 GAL. ELEC. WATER HTR	WHEN	WHS-PRO-NO-2	450	208-3PH		
W-2	30 GAL. ELEC. WATER HTR	WHEN	SOV2-1	450	208-3PH		
W-3	6 GAL. ELEC. WATER HTR	WHEN	WH08	2000	208-3PH		INSTALL UNDER SINK CABINET
W-4	35 GAL. ELEC. WATER HTR	WHEN	WH25	1440	20-PH		INSTALL UNDER SINK CABINET
W-5	25 GAL. ELEC. WATER HTR	WHEN	WH25	1440	20-PH		INSTALL UNDER SINK CABINET
H-1	HYDRONIC BOILER-ELEC.						MOUNT ON WALL

GENERAL PLUMBING NOTES:

- ALL WORK TO BE DONE IN ACCORDANCE WITH 2008 OHIO PLUMBING CODE, 2007 OHIO CHAPTER 21 AND DEPARTMENT OF HEALTH REGULATIONS, AND THE RICHLAND COUNTY HEALTH DEPARTMENT REQUIREMENTS.
- THREE DIMENSIONS INDICATE GENERAL PLUMBING FIXTURES REQUIRED AND THE APPROXIMATE LOCATION. IT WILL BE THE PLUMBING CONTRACTOR OR SUB-CONTRACTOR RESPONSIBILITY TO CORRECT ALL FIXTURES AND LOCATIONS, FITS, ROUTING, NEEDS, ETC.
- IT IS THE INTENT TO FURNISH AND INSTALL NEW ELECTRIC HOT WATER HEATERS AT LOCATIONS INDICATED. PLUMBING CONTRACTOR SHALL SUBMIT APPROPRIATE EQUIPMENT DATA AND SPECIFICATIONS FOR WATER HEATERS SELECTED FOR OWNER REVIEW AND RECORD.
- PLUMBING CONTRACTOR SHALL DETERMINE SIZE OF RECYCLED WATER LINE FROM EXISTING WELL LOCATION AND SIZE OF NEW PRESSURE TANK, BASED ON P.A. WELL TESTER.

THIS DRAWING MAY BE USED AS A BASIS REPRESENTATION OF CONTRACTOR'S DESIGN AND SHALL BE REPRODUCED OR ADAPTED BY CONTRACTOR. IT IS THE CONTRACTOR'S OBLIGATION TO VERIFY ALL CONDITIONS WITH ALL RECORD DRAWINGS AND LOCAL LAWS OF JURISDICTION. PLUMBING CONTRACTOR IS RESPONSIBLE FOR REVIEW AND REVISIONS OF ALL RECORD DRAWINGS, PERMITS AND INSPECTIONS TO VERIFY FROM PERMITS AND LOCAL LAWS. THE DESIGN DRAWING SHALL BE THE PROPERTY OF G.A. OSWALT PROFESSIONAL DRAFTING AND SHALL BE KEPT IN THE OFFICE OF THE ARCHITECT.

REV. 1/1/04 FOR KITCHEN CHANGES

G. A. OSWALT
PROFESSIONAL DRAFTING
P.O. BOX 1774 - WAREHOUSING, OHIO 44781 - 748.932.8239
DATE: 04/24/08 DRAWN BY: GAO
SCALE: AS SHOWN ACCEPTED BY:
FILE NAME: 07070-PLUM-PC



REVISIONS
NO. DESCRIPTION
DATE BY

ISSUED SHEET TITLE: **PROPOSED PLUMBING PLAN**
PROJECT TITLE: **NEW CHURCH FACILITY FOR FAITH UNITED METHODIST CHURCH**
DATE: 07/15/08
DRAWN BY: GAO



PROJECT # **P-07912B**
DRAWING SHEET # **P.1B**