

**VERIFICATION FORM FOR COMMUNITY PUBLIC WATER SYSTEMS
CLAIMING NO LEAD SERVICE LINES**

The owner or operator of all community public water systems must identify and map areas of their distribution system that are known or are likely to contain lead service lines. Systems must submit a copy of the applicable map to the Ohio Department of Health and the Ohio Department of Job and Family Services. Systems must also submit a report to the director containing at least both of the following: (1) The applicable map with narrative, and (2) A list of sampling locations used to collect samples as required by Ohio Revised Code (ORC) Section 6109.121 and any rules adopted thereunder, including contact information for the owner and occupant of each sampling site.

Should a water system determine no lead service lines exist in their distribution system, they must provide information stating they reviewed, at the minimum, historical permit records and local ordinances, distribution maintenance records and information pertaining to installation dates or materials for all services lines. This information must be verified below.

I HEREBY CERTIFY THAT THE FOLLOWING METHOD(S) WERE USED TO DETERMINE NO LEAD SERVICE LINES EXIST IN THIS WATER SYSTEM'S DISTRIBUTION SYSTEM, AS REQUIRED BY ORC 6109.121(F):

LEAD SERVICE LINE VERIFICATION
<p>This PWS states they have no lead service lines and has reviewed the following information (select one or more of the following):</p> <ul style="list-style-type: none"> <input type="checkbox"/> Historical permit records and/or local ordinances <input type="checkbox"/> Distribution maintenance records (i.e. meter replacement, waterline break repairs) <input type="checkbox"/> Information pertaining to installation dates for all service lines (i.e. after 1986 when lead services lines were banned) <input checked="" type="checkbox"/> Service line material of all service lines is known (i.e. all service lines are known to be PVC)

Dale Rufener 3/8/17
 Signature of Responsible Person Date
DALE RUFENER - OWNER + PRESIDENT
 Printed Name and Title of Responsible Person


PWS NAME: Farr Hill MHP, Inc
 PWS ID: 1503312
 OH Wellsville
 COUNTY: Columbiana

<p>For Ohio EPA use only:</p> <p>Date Verification Rec'd: _____</p>
--

Entity: Farr Hill MHP
 Doc Type: REPORT
 Doc Subtype: _____
 Program: DDAGW
 County: Columbiana
 Secondary ID: OH/1503312

SITE PLAN

75 LOTS

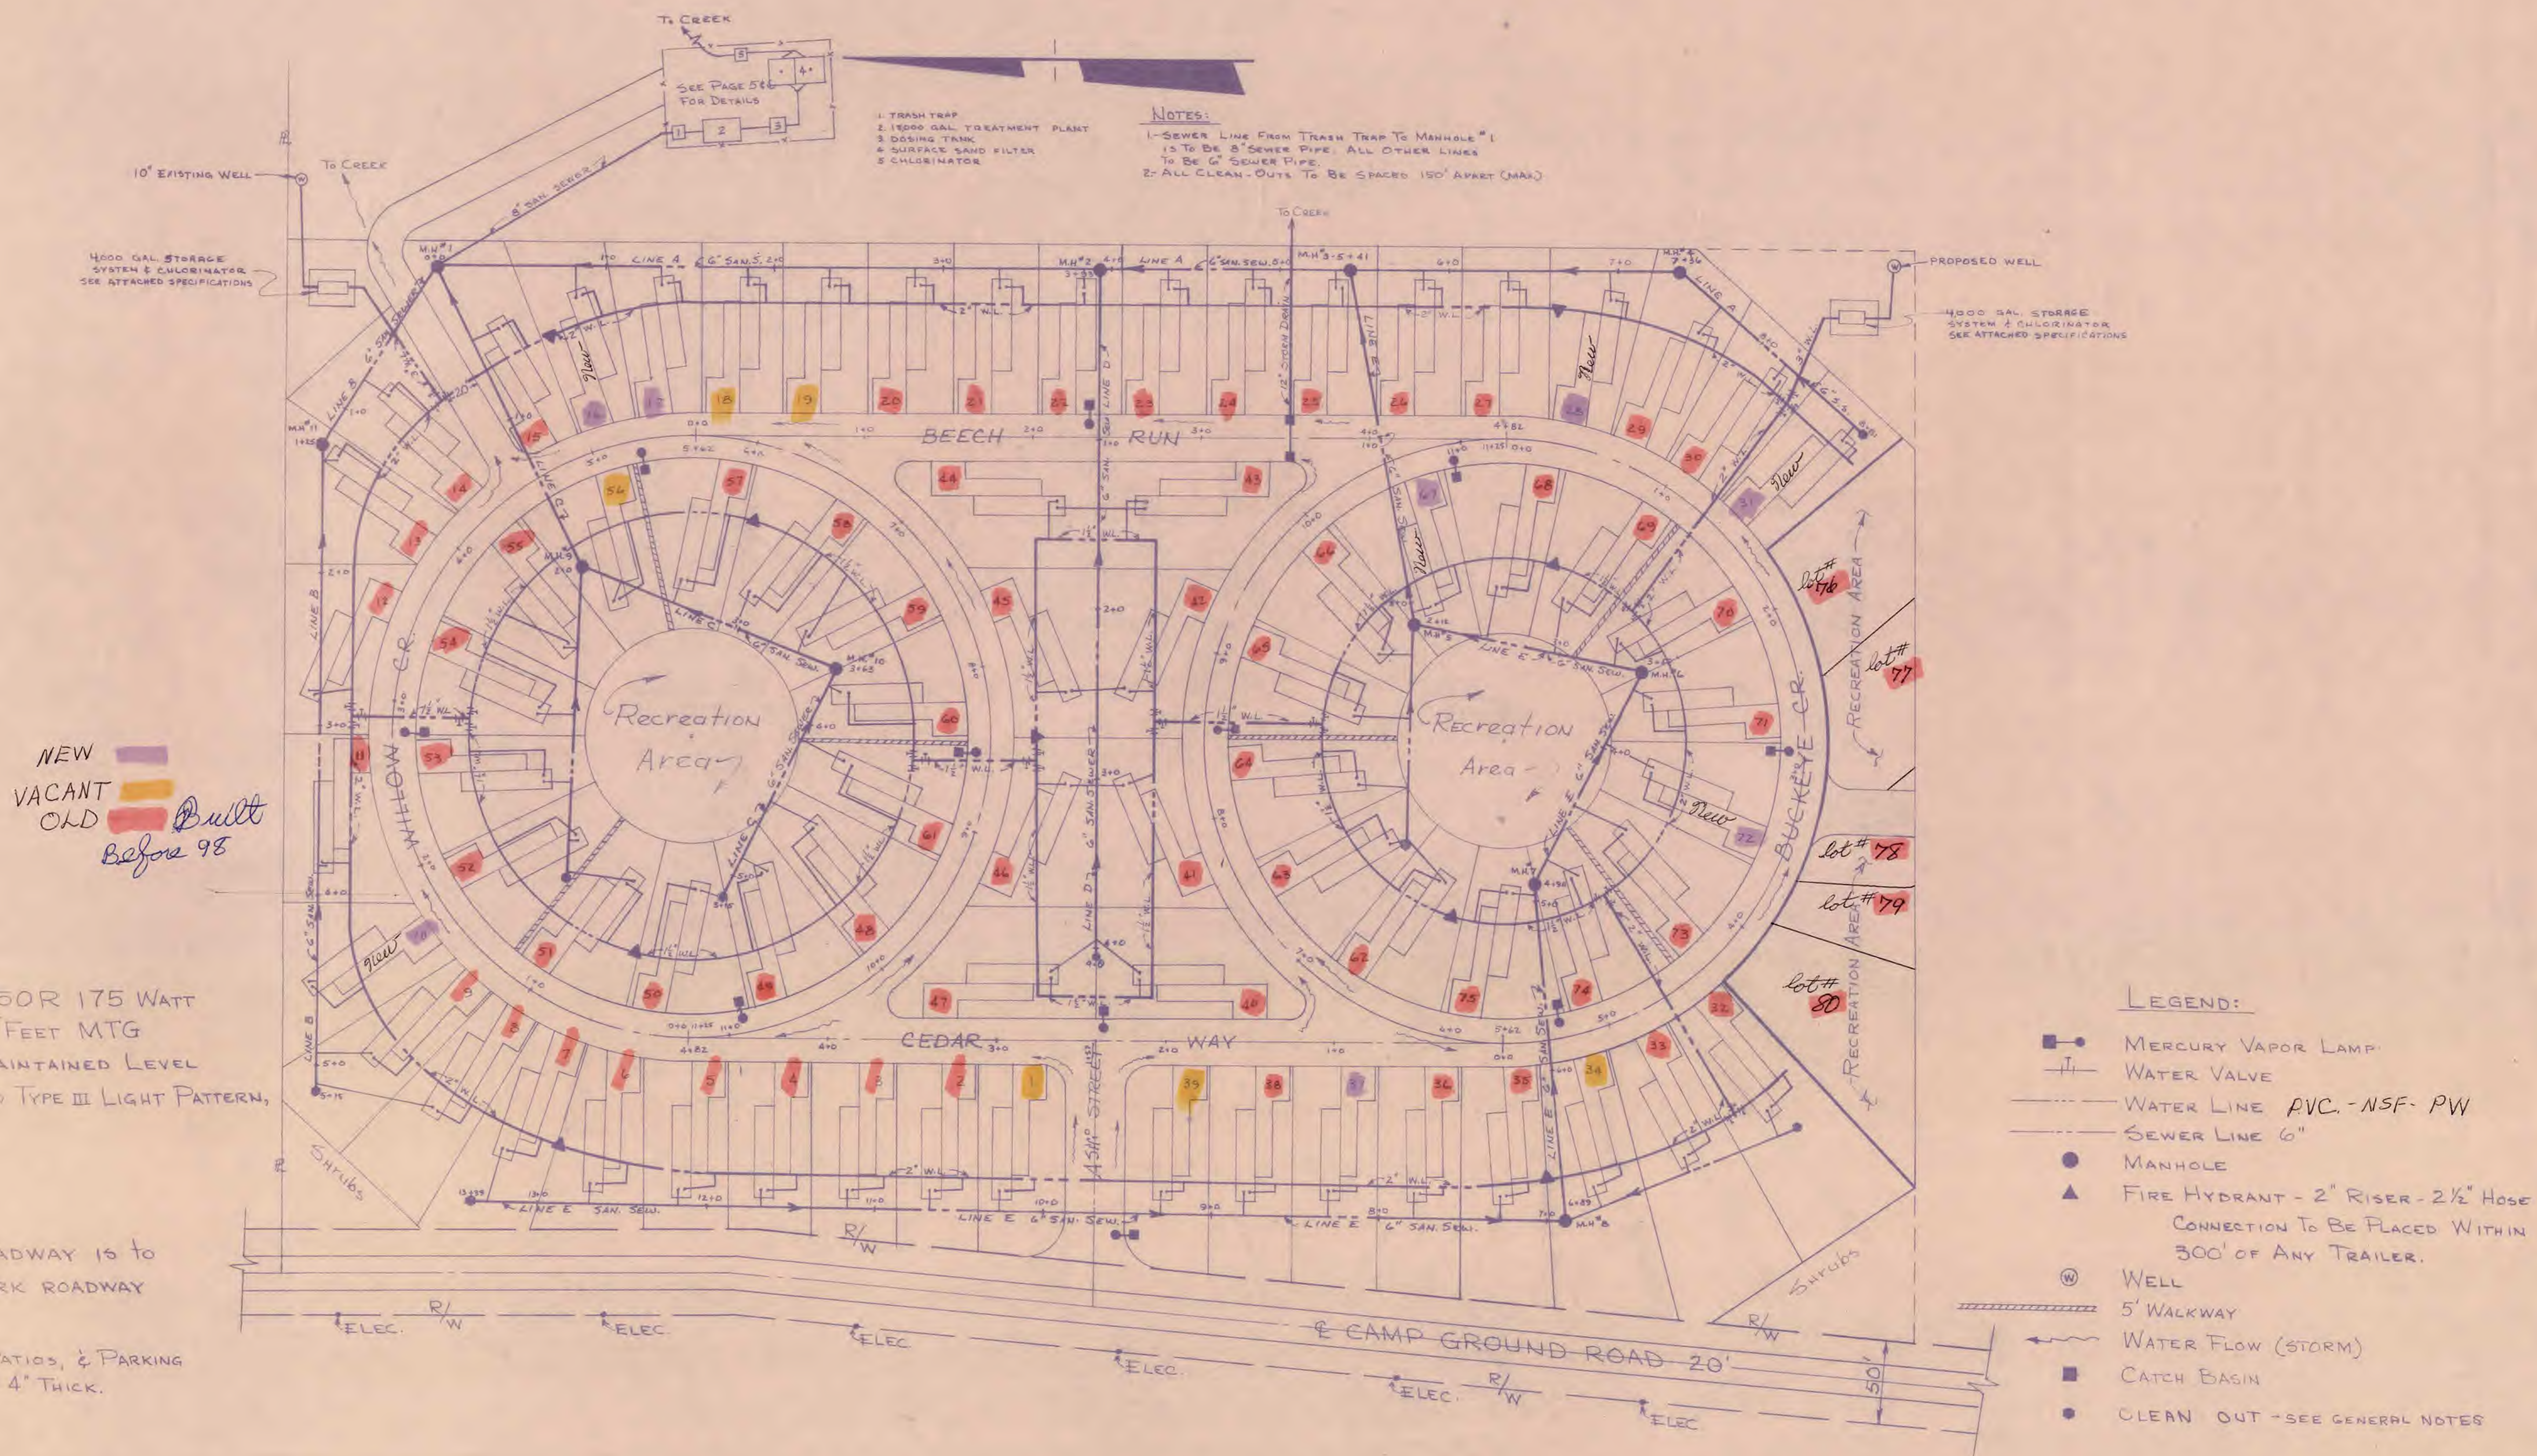

NOTES:
 1- SEWER LINE FROM TRASH TRAP TO MANHOLE #1 IS TO BE 8" SEWER PIPE. ALL OTHER LINES TO BE 6" SEWER PIPE.
 2- ALL CLEAN-OUTS TO BE SPACED 150' APART (MAX)

NEW
 VACANT
 OLD Built Before 98

LIGHTING
 GE. LUMINAIR M250R 175 WATT MERCURY LAMP 25 FEET MTG
 HEIGHT AVERAGE MAINTAINED LEVEL = 0.3 FC USE IES TYPE III LIGHT PATTERN, OR EQUAL.

NOTES:
 1. MAIN ENTRANCE ROADWAY IS TO BE 35' & ALL IN PARK ROADWAY IS TO BE 28'.
 2. ALL TRAILER SLABS, PATIOS, & PARKING SLABS TO BE CONCRETE 4" THICK.

LEGEND:

- MERCURY VAPOR LAMP
- ⊥ WATER VALVE
- WATER LINE PVC-NSF-PW
- SEWER LINE 6"
- MANHOLE
- ▲ FIRE HYDRANT - 2" RISER - 2 1/2" HOSE CONNECTION TO BE PLACED WITHIN 300' OF ANY TRAILER.
- ⊙ WELL
- 5' WALKWAY
- ~ WATER FLOW (STORM)
- CATCH BASIN
- CLEAN OUT - SEE GENERAL NOTES

SCALE - 1" = 50'