

MAR 08 2017

OHIO EPA NEDO

Happy Day School PWS # OH6773412 Facility ID # 6757453

2500 Brady Lake Rd.

Ravenna, Ohio 44266

330-678-2400

Maintenance Office 330-296-8870 Marco Condos: Facility Supervisor

The building was built in 1973-74 and opened in 1974. It is a one story building that has a well feeding a 10,000 gallon storage tank. The line from the well to storage tank is 2 inch plastic and copper. The line from storage tank into the building is 6 inch copper that feeds two circulating pumps and pressure tank to distribute water throughout the building.

The supply lines are copper throughout the building with solder joints of unknown lead contents. The area of rooms 7, 8, 13, 14 & 15 were remodeled in 1993 so they should be lead free solder.

We have 78 fixtures that are of mixed variety, with most material unknown:

Central Faucet- 8 hot & cold fixtures, 2 mixed single faucets-1993 or newer

Central Faucet-1 mop sink faucet- 1974

Chicago Faucet-13 hot & cold fixtures- 1993 or newer

Chicago Faucet- 1 Pot filling fixture-1974

Delta Faucet- 16 hot & cold fixtures-1993 or newer

Elkay Faucet-4 hot & cold fixtures- 1974

Elkay Drinking Fountain-1974

Kohler Faucet-7 hot & cold fixtures-1993 or newer


Kohler Faucet-2 tub fixtures-1974

Kohler faucet-1 shower head-1974

Moen Faucet-13 hot & cold fixtures-1993 or newer

Wizard Faucet-9 shower heads-1974

Entity: Happy Day Sch
Doc Type: REPORT
Doc Subtype: DDAGW
Program: Part 3
County: 016773412
Secondary ID: 016773412

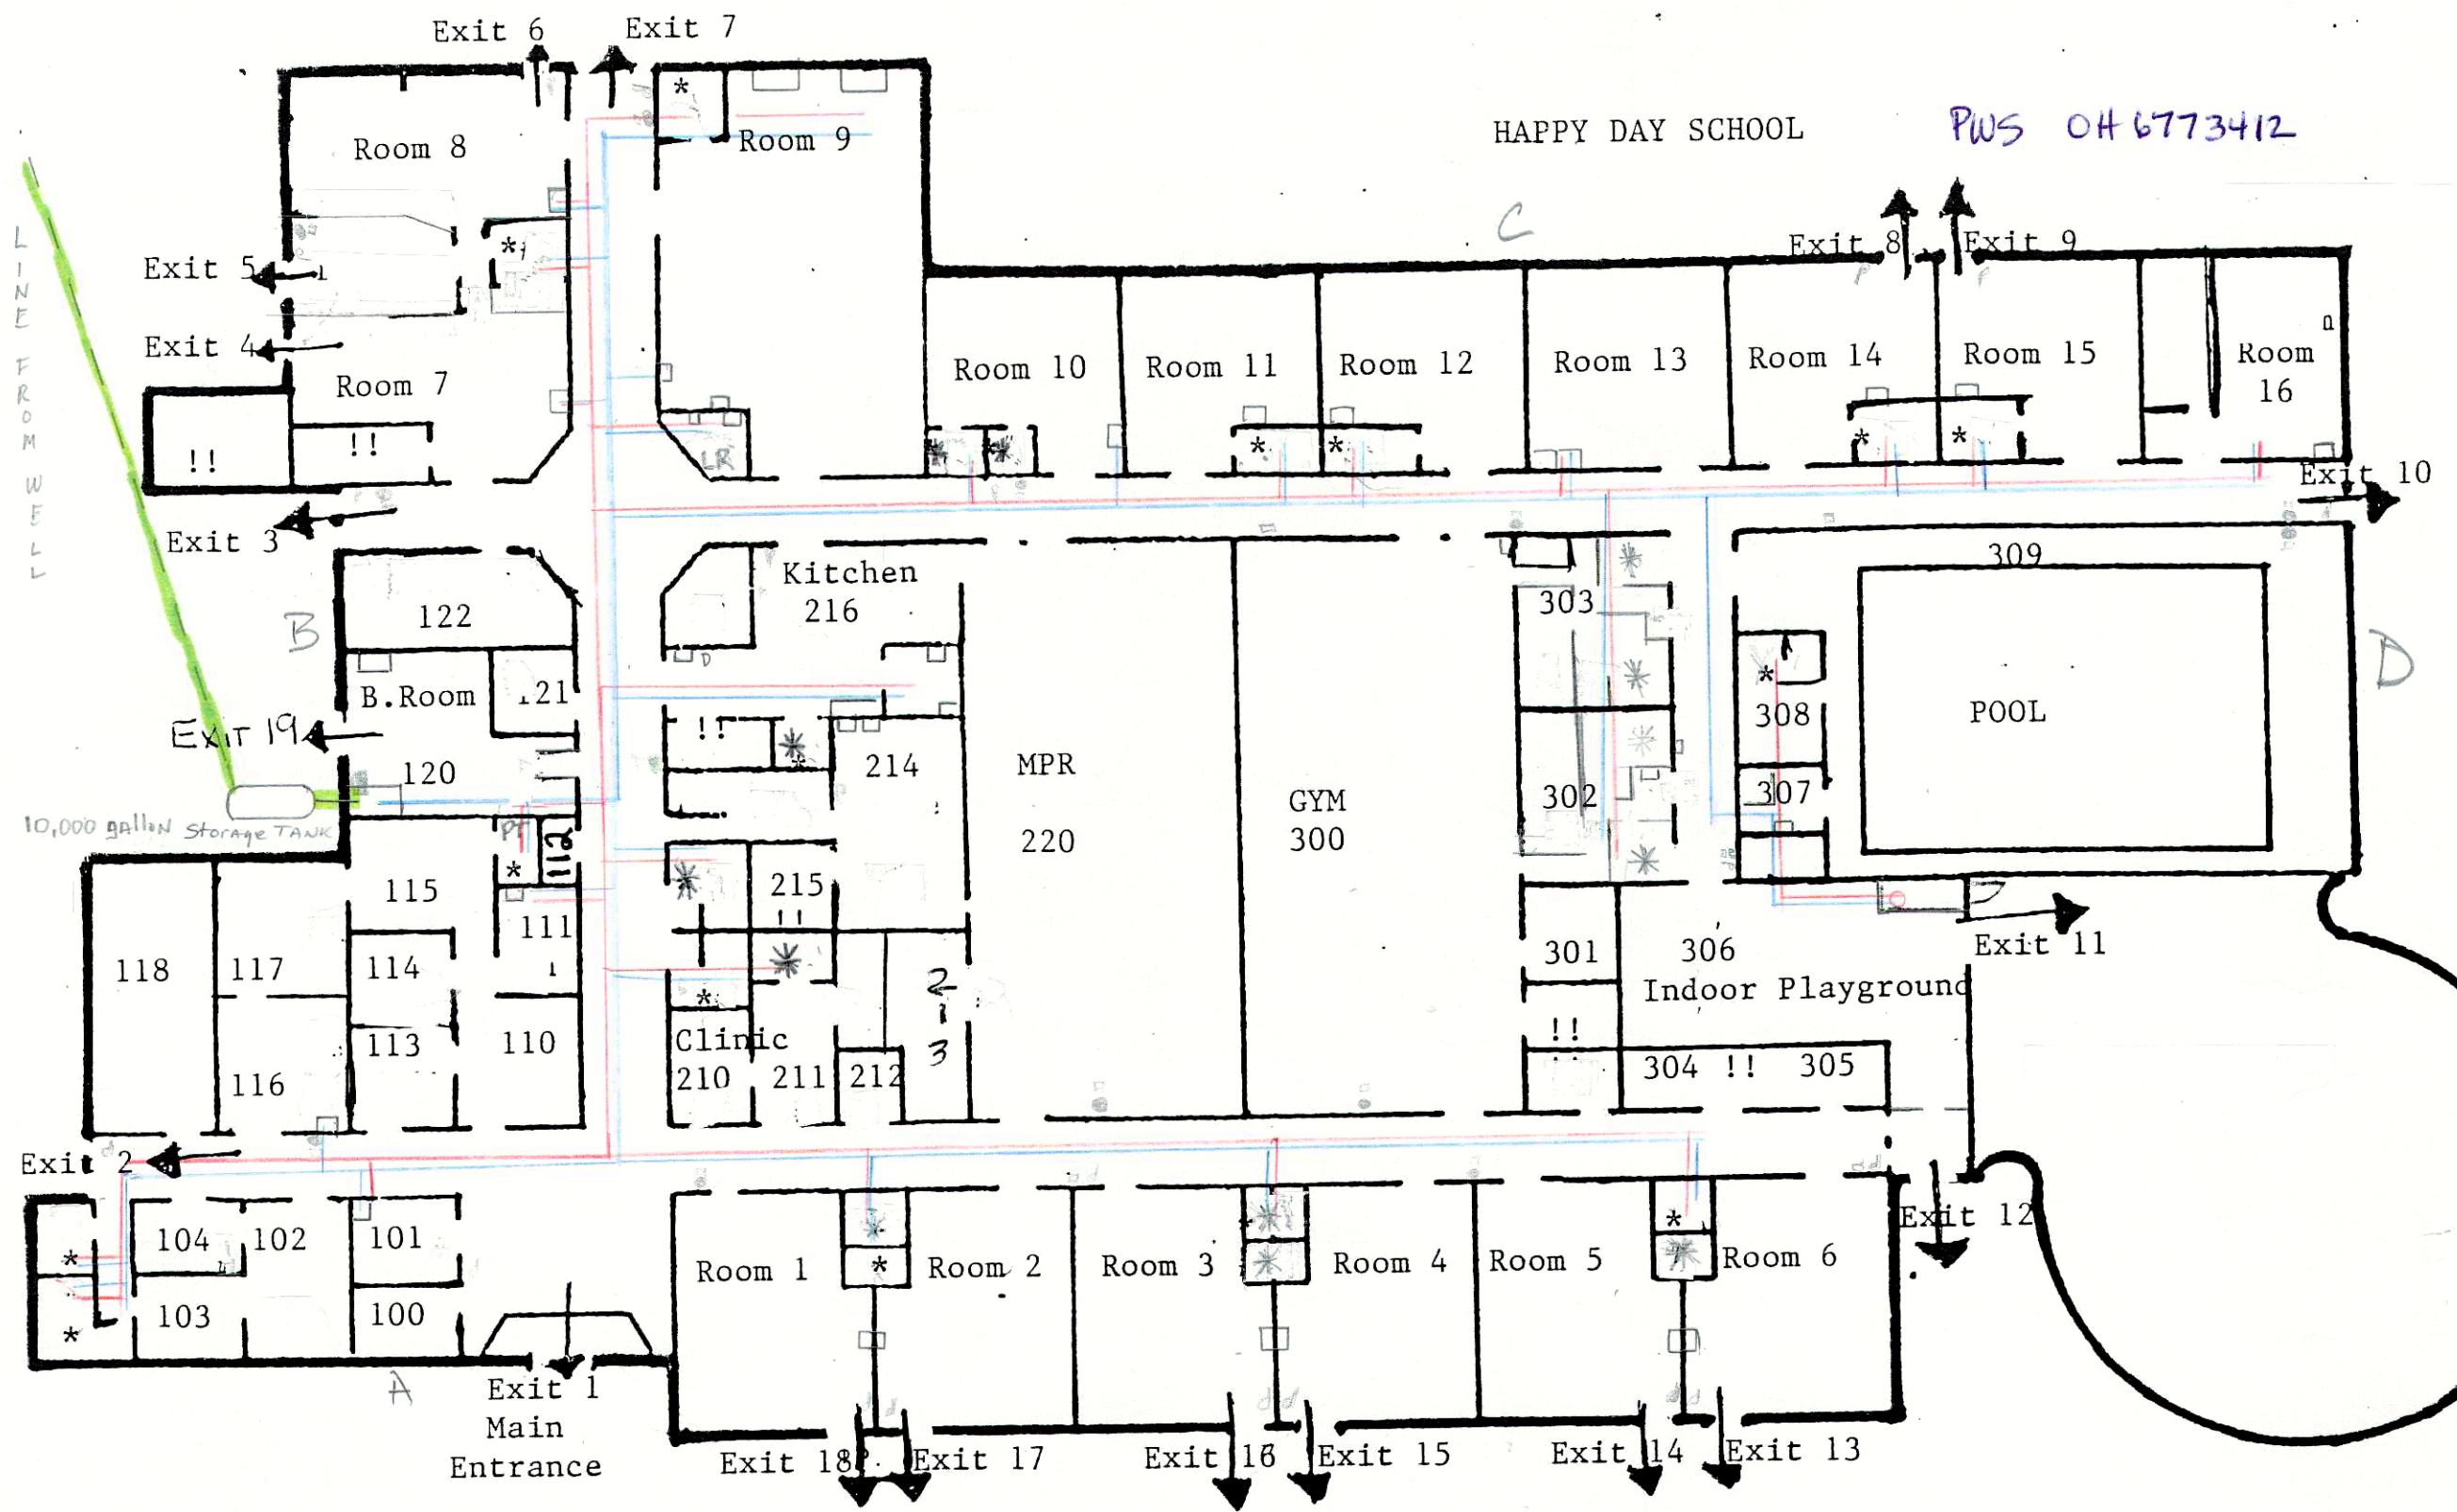

HAPPY DAY SCHOOL

PWS OH 6773412

- 24 RESTROOMS
- 3 MOP SINKS - □
- 1 LAUNDRY TUB - □
- 29 SINKS - □
- 2 BATHTUBS
- 3 SHOWERS
- 2 WASHER OUTLETS - □
- 2 DRINKING FOUNTAINS

115 RESTROOM PLANTTAP
Kitchen HAND SINK
DISTRIBUTION

120 PRESSURE TANK
& DISTRIBUTION
PUMPS


HOT & MIXED
COLD
WATER LINES

Storage Areas !!
Restrooms *

MPR- Room 10	1-8/10-15 Classrooms	112- Equipment Room	121- Psych. Office	220- MPR
GYM- Room 12	16- Snoozelen Room	114- File/Server Room	122- Lending Library	300- Gym
Indoor play-13	9- Therapy Skills+ LAUNDRY ROOM	115- Director	210/211- Clinic & Office	301- APE Office
Kitchen- 121	102- EI Offices	116/117- Lounge/Conf.Rm	213- Archives/Storage	302/303- Locker Rooms + SHOWERS
Stage- Steps	100/101/104- Lang.Offices	118- OT/PT Office	214- Staff Work Room	306- Indoor Playground
	110-113- Clerical Office	120- Boiler Room	216- Kitchen	309- Pool

308 POOL OFFICE & SHOWER
307 POOL PUMP ROOM & WASHER

← BRADY LAKE RD. →

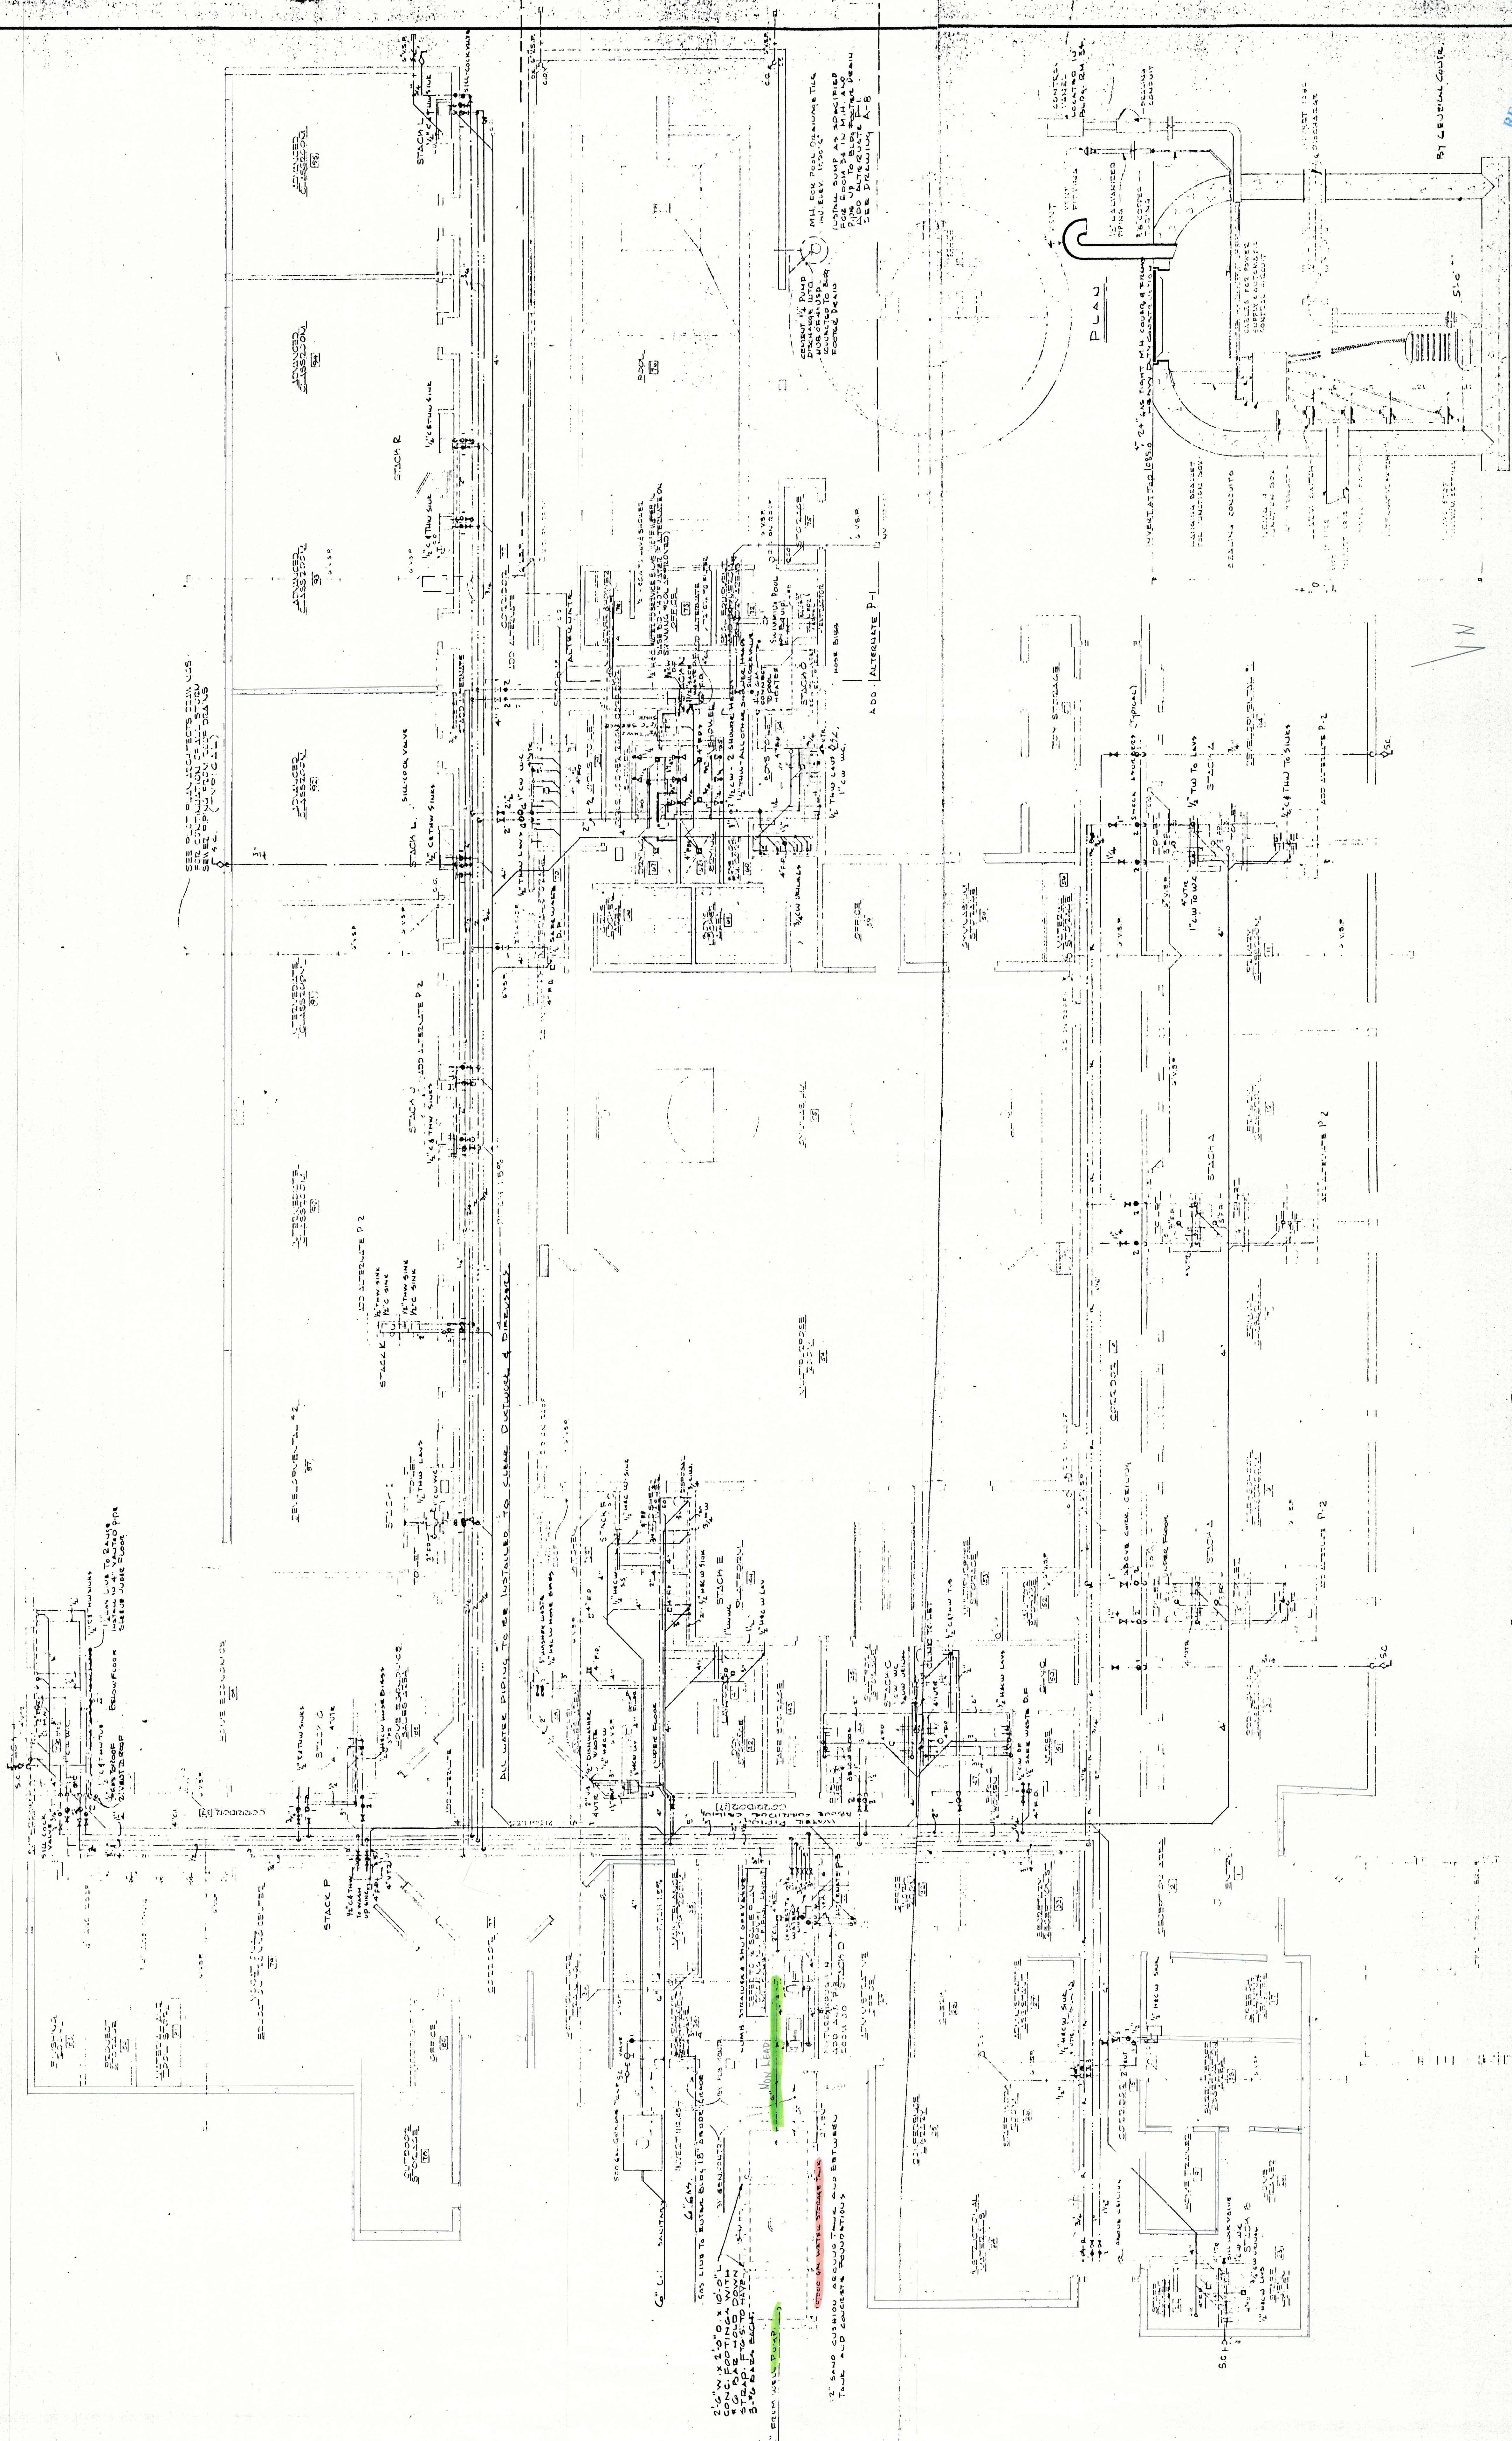











PLUMBING PLAN

SCALE: 1/8" = 1'-0"

RECEIVED
MAR 08 2017
OHIO
MAIL ROOM
SERVICES COLLECTION SECTION

Happy Day School PWS 016773412

		5-30-75	REVISIONS	PLUMBING PLAN - SUMPAGE LIFT-STATION DETAILS	SHEET NO. P-1
		5-30-75	REVISIONS	PLUMBING PLAN - SUMPAGE LIFT-STATION DETAILS	SHEET NO. P-1
		5-30-75	REVISIONS	PLUMBING PLAN - SUMPAGE LIFT-STATION DETAILS	SHEET NO. P-1
		5-30-75	REVISIONS	PLUMBING PLAN - SUMPAGE LIFT-STATION DETAILS	SHEET NO. P-1
		5-30-75	REVISIONS	PLUMBING PLAN - SUMPAGE LIFT-STATION DETAILS	SHEET NO. P-1