


RE: TIFFIN LOADER CRANE
COMPANY

Report
Drinking Water Program
Seneca County
PWS ID: OH7449412


0217

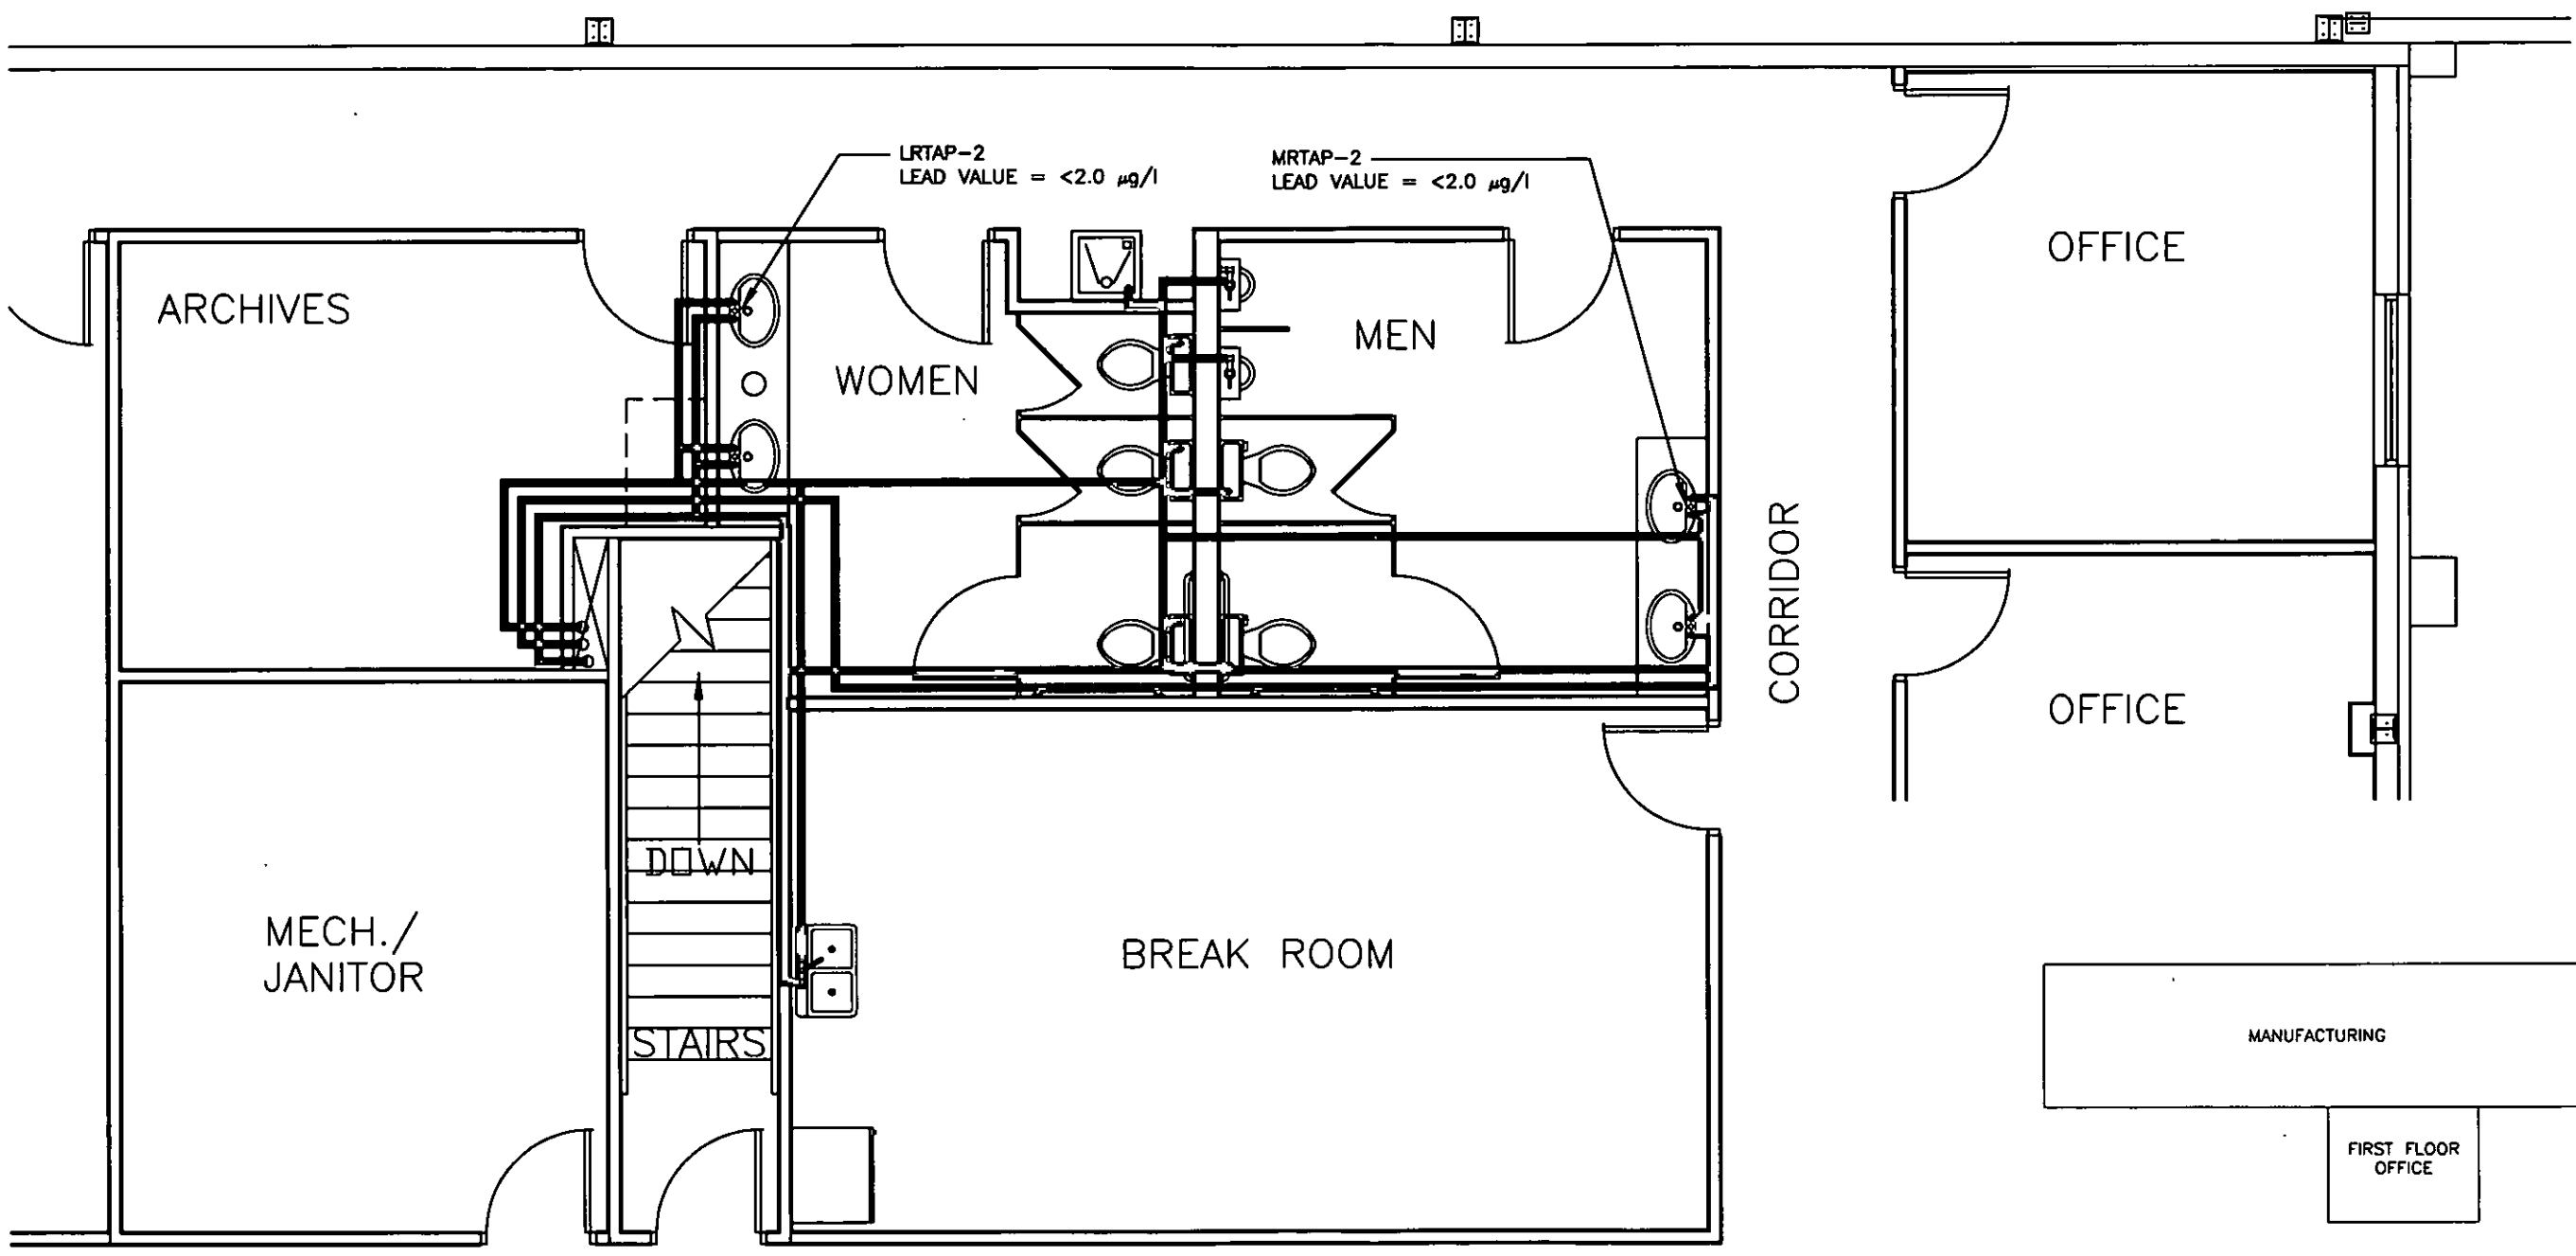

SECOND FLOOR PLUMBING PLAN

SCALE: 3/8" = 1'-0"

NORTH

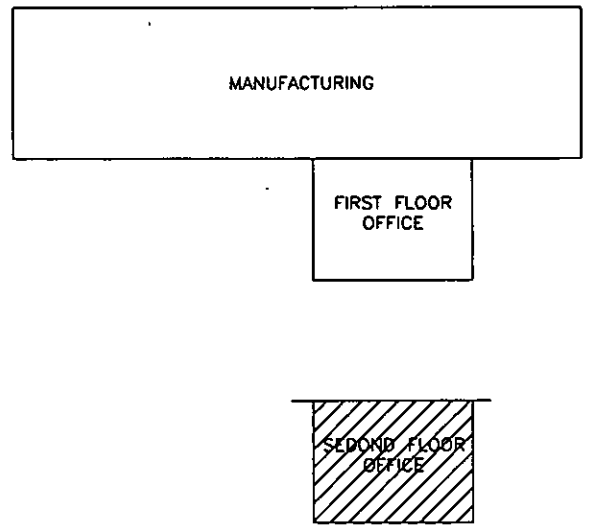

KEY PLAN

NTS

ENCOMPASS
ENGINEERS-ARCHITECTS-POWER



271 S. MAIN ST.
Tiffin, OH 44880
PH. 419.427.8119
ENCOMPASS-USA.COM

LEAD MAPPING
PALFLEET TRUCK EQUIPMENT

4151 OH-18
TIFFIN, OHIO 44883


| MARK | DATE | DESCRIPTION |
|------|------|-------------|
| | | |
| | | |
| | | |
| | | |

PROJECT NO: 17-0184
DRAWN BY: P.J.Q.
CHECKED BY: R.A.P.
STATUS: Preliminary
DATE: 03/01/17
FULL SIZE SHEET: 11" x 17"

SECOND FLOOR OFFICES PLUMBING PLAN

P-1002


9/27/2007 3:58:11 PM

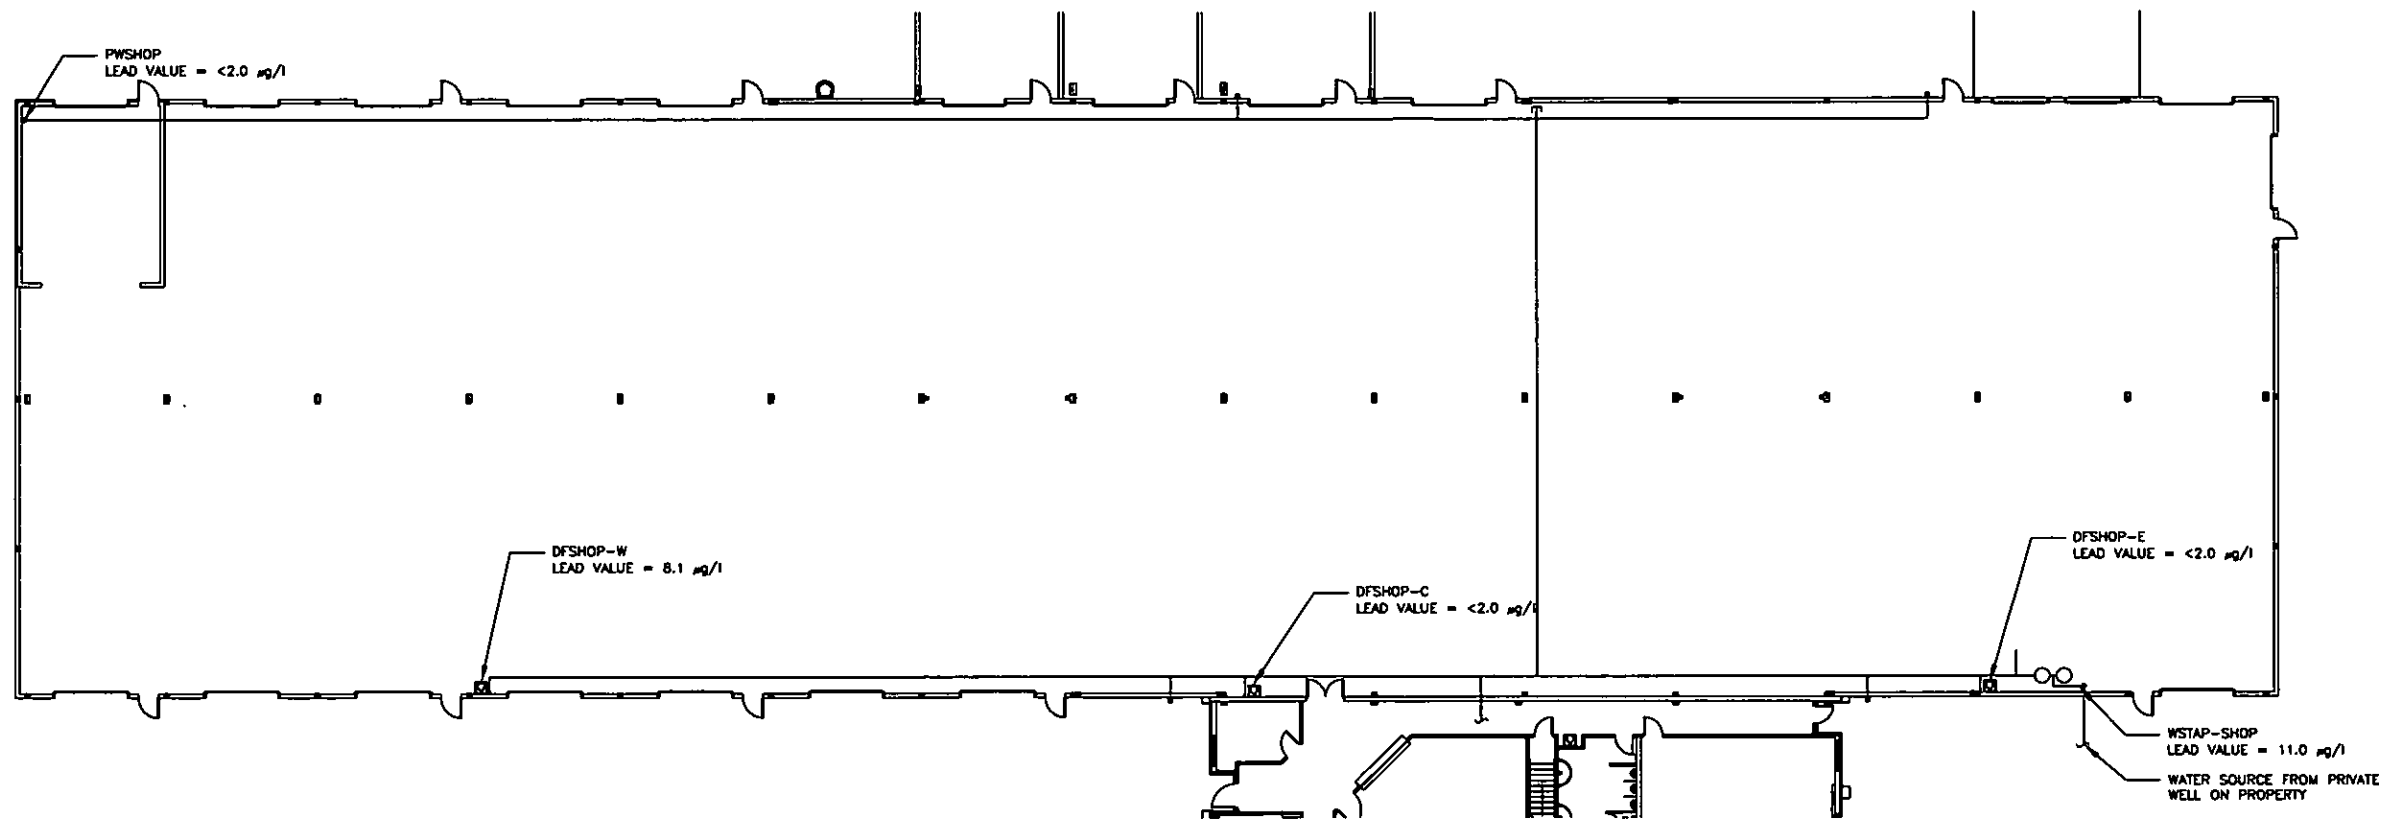

MANUFACTURING PLUMBING PLAN

SCALE: 1/32" = 1'-0"


NORTH

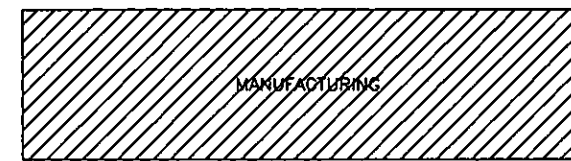

MANUFACTURING



FIRST FLOOR OFFICE

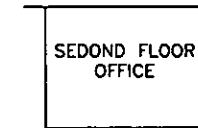

SECOND FLOOR OFFICE

KEY PLAN

NTS

LEAD MAPPING
PALFLEET TRUCK EQUIPMENT

4151 OH-18
 TIFFIN, OHIO 44883


| MARK | DATE | DESCRIPTION |
|------|------|-------------|
| | | |
| | | |
PROJECT NO: 17-0184
 DRAWN BY: P.J.Q.
 CHECKED BY: R.A.P.
 STATUS: Preliminary
 DATE: 03/01/17
 FULL SIZE SHEET: 11" X 17"

MANUFACTURING PLUMBING PLAN

P-1000

LEAD MAPPING IN DISTRIBUTION SYSTEMS PALFLEET TRUCK EQUIPMENT COMPANY LLC TIFFIN, OHIO

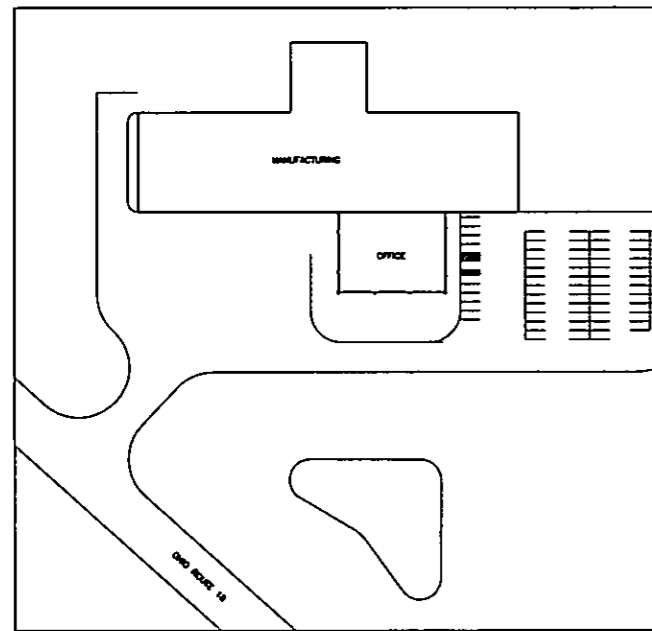

SITE PLAN



VICINITY MAP
WEST OF TIFFIN, OHIO
NO SCALE

CONTACTS:
XXXXXXX
PALFLEET TRUCK EQUIPMENT COMPANY LLC
PH: 419-448-8156

MIKE ARNOLD, ARCHITECT
ENCOMPASS ENGINEERS AND ARCHITECTS
521 SOUTH MAIN STREET
FINDLAY, OHIO 45840
PH: 419-427-1819

| INDEX OF DRAWINGS | | DATE | REVISED |
|-------------------|----------------------------------|---------|---------|
| T-1000 | TITLE SHEET | 2/22/17 | |
| P-1000 | MANUFACTURING PLUMBING PLAN | 2/22/17 | |
| P-1001 | FIRST FLOOR OFFICE PLUMBING PLAN | 2/22/17 | |
| P-1002 | SECOND FLOOR PLUMBING PLAN | 2/22/17 | |

NOTE
BUILDING WAS BUILT AFTER 1998

COLORS
LEAD =
NON-LEAD =
NO INFORMATION =

ABBREVIATIONS
 FIRST FLOOR BREAK ROOM TAP - BRTAP-1
 FIRST FLOOR MENS ROOM SINK - MRTAP-1
 FIRST FLOOR LADIES ROOM SINK - LRTAP-1
 FIRST FLOOR DRINKING FOUNTAIN - DF-1
 FIRST FLOOR INDUSTRIAL HAND WASHER - IHW-1
 SECOND FLOOR MENS ROOM - MRTAP-2
 SECOND FLOOR LADIES ROOM - LRTAP-2
 MANUFACTURING, TAP BY WATER SYSTEM - WSTAP-SHOP
 MANUFACTURING, DRINKING FOUNTAIN TO WEST - DFSHOP-E
 MANUFACTURING, DRINKING FOUNTAIN CENTRAL - DFSHOP-C
 MANUFACTURING, DRINKING FOUNTAIN TO EAST - DFSHOP-W
 MANUFACTURING, PAINT WASHER - PWSHOP

ENCOMPASS
ENGINEERS-ARCHITECTS-POWER
521 S. MAIN ST.
FINDLAY, OH 45840
PH: 419-427-1819
ENCOMPASS-EO.COM

LEAD MAPPING
PALFLEET TRUCK EQUIPMENT
4151 OH-18
TIFFIN, OHIO 44883

RECEIVED
MAR 09 2017
OHIO E.P.A.
N.W.D.O.

| MARK | DATE | DESCRIPTION |
|------|------|-------------|
| | | |
| | | |
| |
|----------------------------|
| PROJECT NO: 17-0184 |
| DRAWN BY: P.J.Q. |
| CHECKED BY: R.A.P. |
| STATUS: Preliminary |
| DATE: 03/01/17 |
| FULL SIZE SHEET: 11" X 17" |

TITLE PAGE

T-1000