


OVER HEAD DOOR W/D HEADQUARTERS
 PWS #D: OH 3843612

OLIVER
 DESIGN
 GROUP


One Park Plaza Cincinnati, Ohio 45266
 (513) 233-2200

Contractor shall verify all dimensions and existing conditions in the field and shall advise the Oliver Design Group of any discrepancies, omissions, questions or alterations at all conditions prior to proceeding with any phase of the work.
 Do not scale drawings.

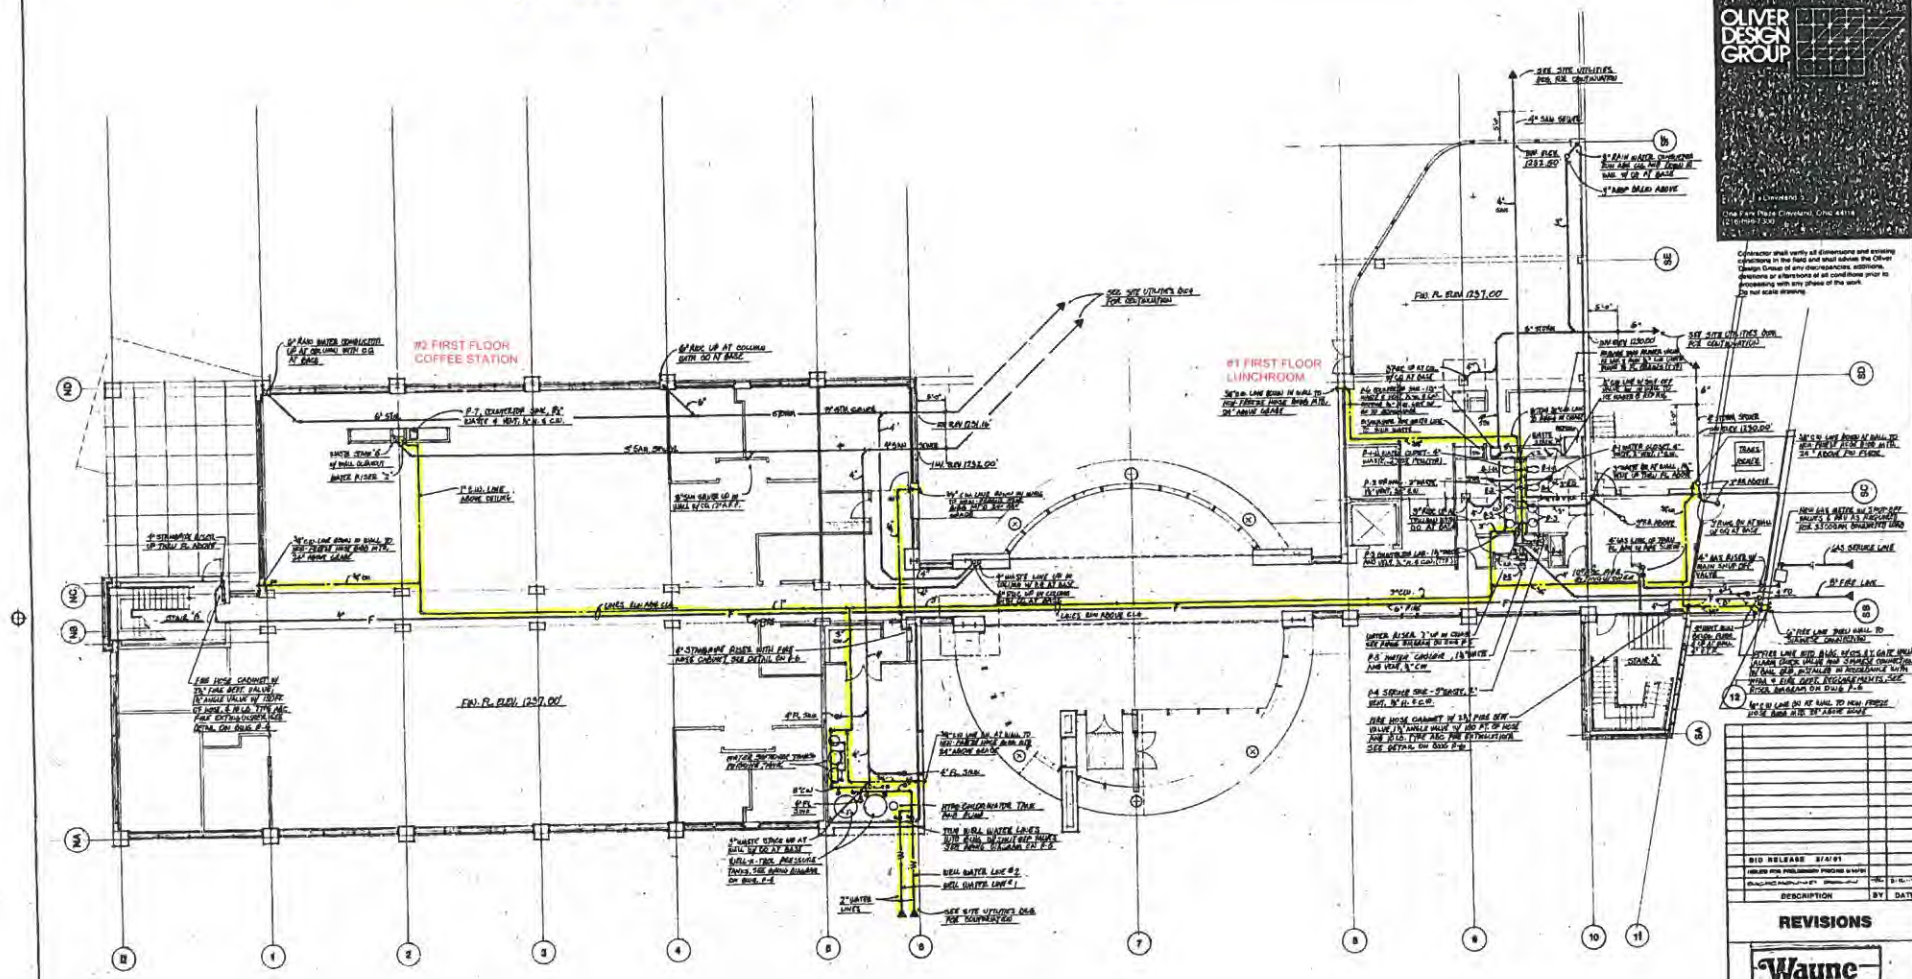

NO.	DESCRIPTION	BY	DATE

 REVISIONS



FIRST FLOOR PLAN
 PLUMBING

OLIVER
 DESIGN
 GROUP

PROJECT NO. 1007 SHEET 1 OF 6
 SCALE 1/4" = 1'-0"
 DRAWN BY [Signature]
 ISSUE DATE


P-1

APPROVED [Signature] DATE



1111 Chestnut
 1111 Chestnut
 1111 Chestnut

Contractor shall verify all dimensions and existing conditions in the field and alert before the Owner/Design Group of any discrepancies. Additional quantities of materials shall be confirmed prior to proceeding with any phase of the work. Do not back-scribe.

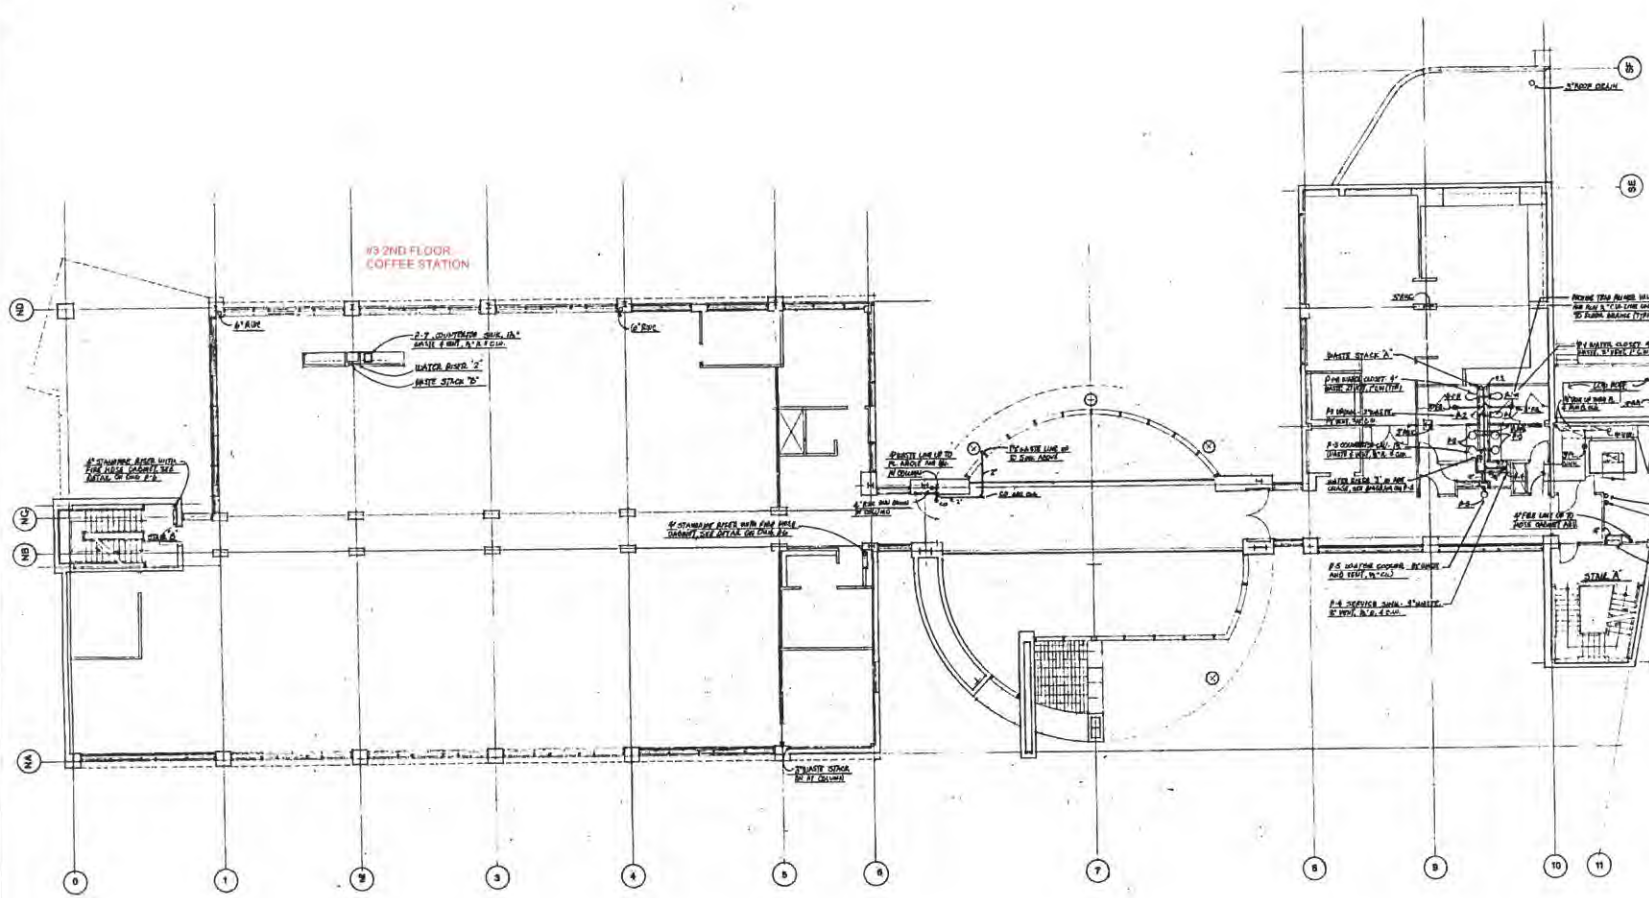

NO.	DESCRIPTION	DATE

REVISIONS



SECOND FLOOR PLAN PLUMBING


PROJECT NO. 10017	SHEET 2 OF 6
SCALE: 3/4" = 1'-0"	P-2
DRAWN: [Signature]	
ISSUE DATE:	



WAYNE DALTON & ASSOCIATES
 1111 CHESTNUT STREET, SUITE 200
 CLEVELAND, OHIO 44115

APPROVED: _____ DATE: _____

Contractor shall verify all dimensions and existing conditions on the field and shall advise the Owner/Design Group of any discrepancies, omissions, omissions or alterations of any conditions prior to proceeding with any phase of the work.
Do not scale drawing.

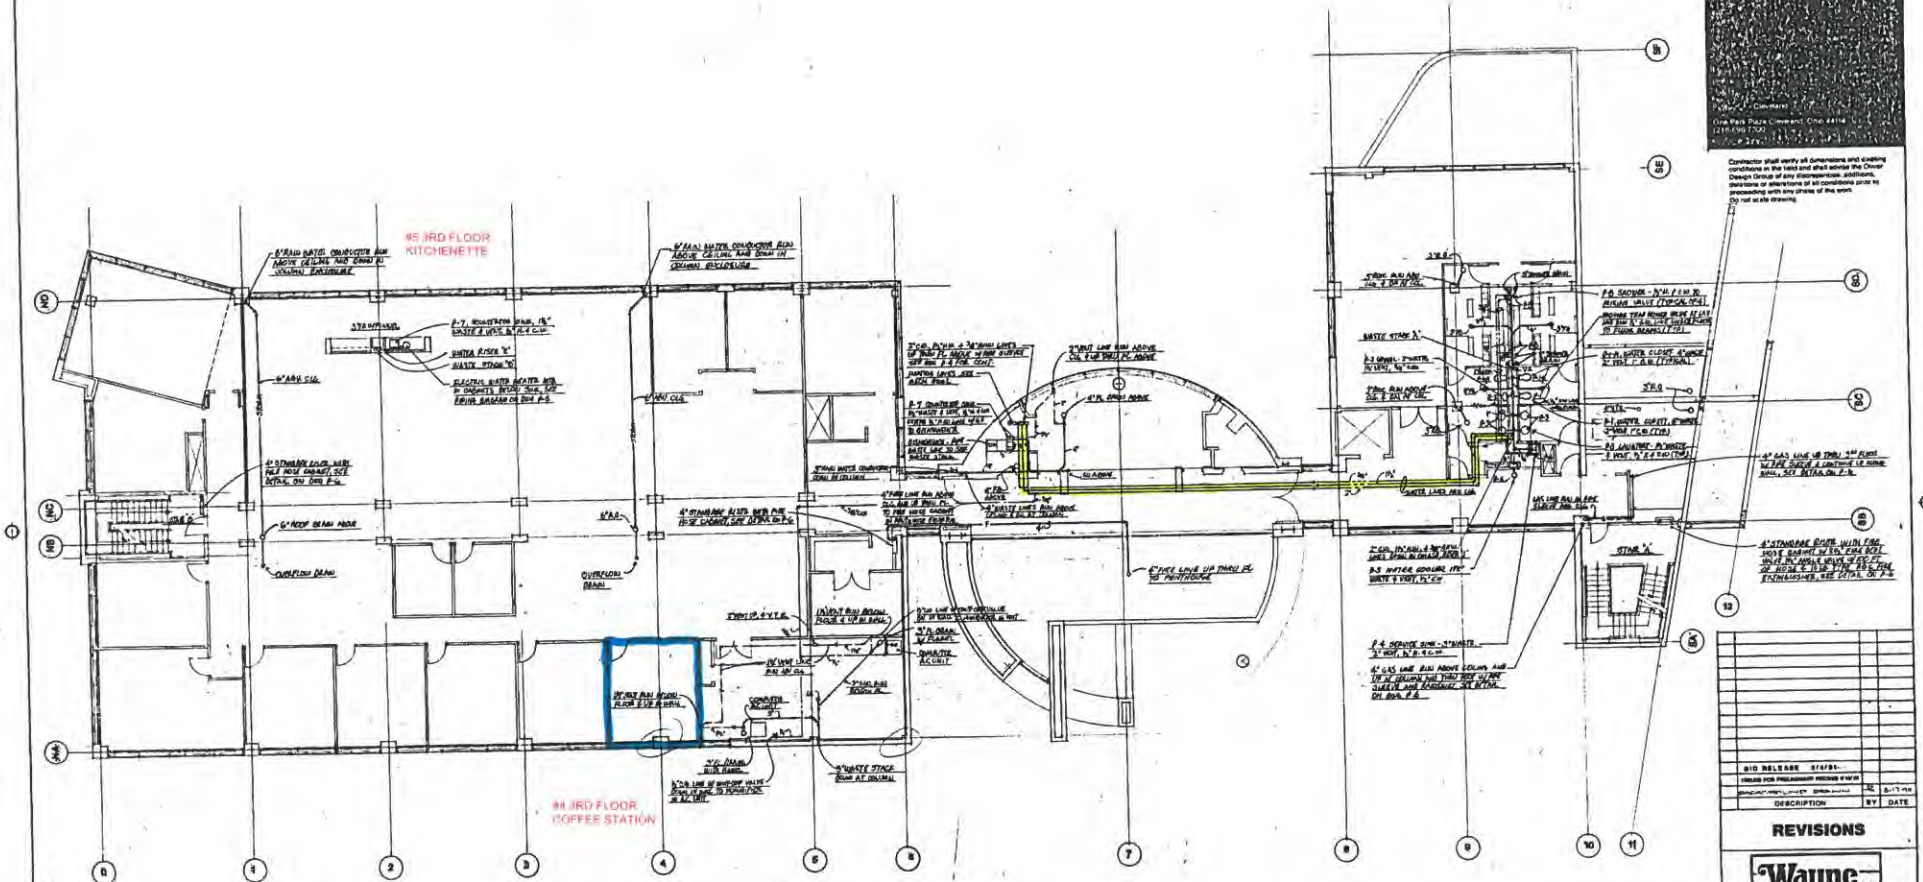

NO.	DATE	DESCRIPTION	BY	DATE

REVISIONS



 
THIRD FLOOR PLAN
PLUMBING

PROJECT NO. 700011 SHEET 3 OF 6
SCALE 1/8" = 1'-0"
DRAWN [Signature] P-3
ISSUE DATE




APPROVED _____ DATE _____

WILSON B. GIBBS & ASSOCIATES
13750 WILSON ROAD, CLEVELAND, OH 44130
TEL: 216.231.1234 FAX: 216.231.1235



13300 Broadview
Cleveland, Ohio 44134
Tel: (216) 752-1111
Fax: (216) 752-1112

Contractor shall verify all dimensions and existing conditions in the field and shall inform the Owner of any discrepancies or alterations of any conditions prior to commencing with the phase of the work. Do not scale drawings.

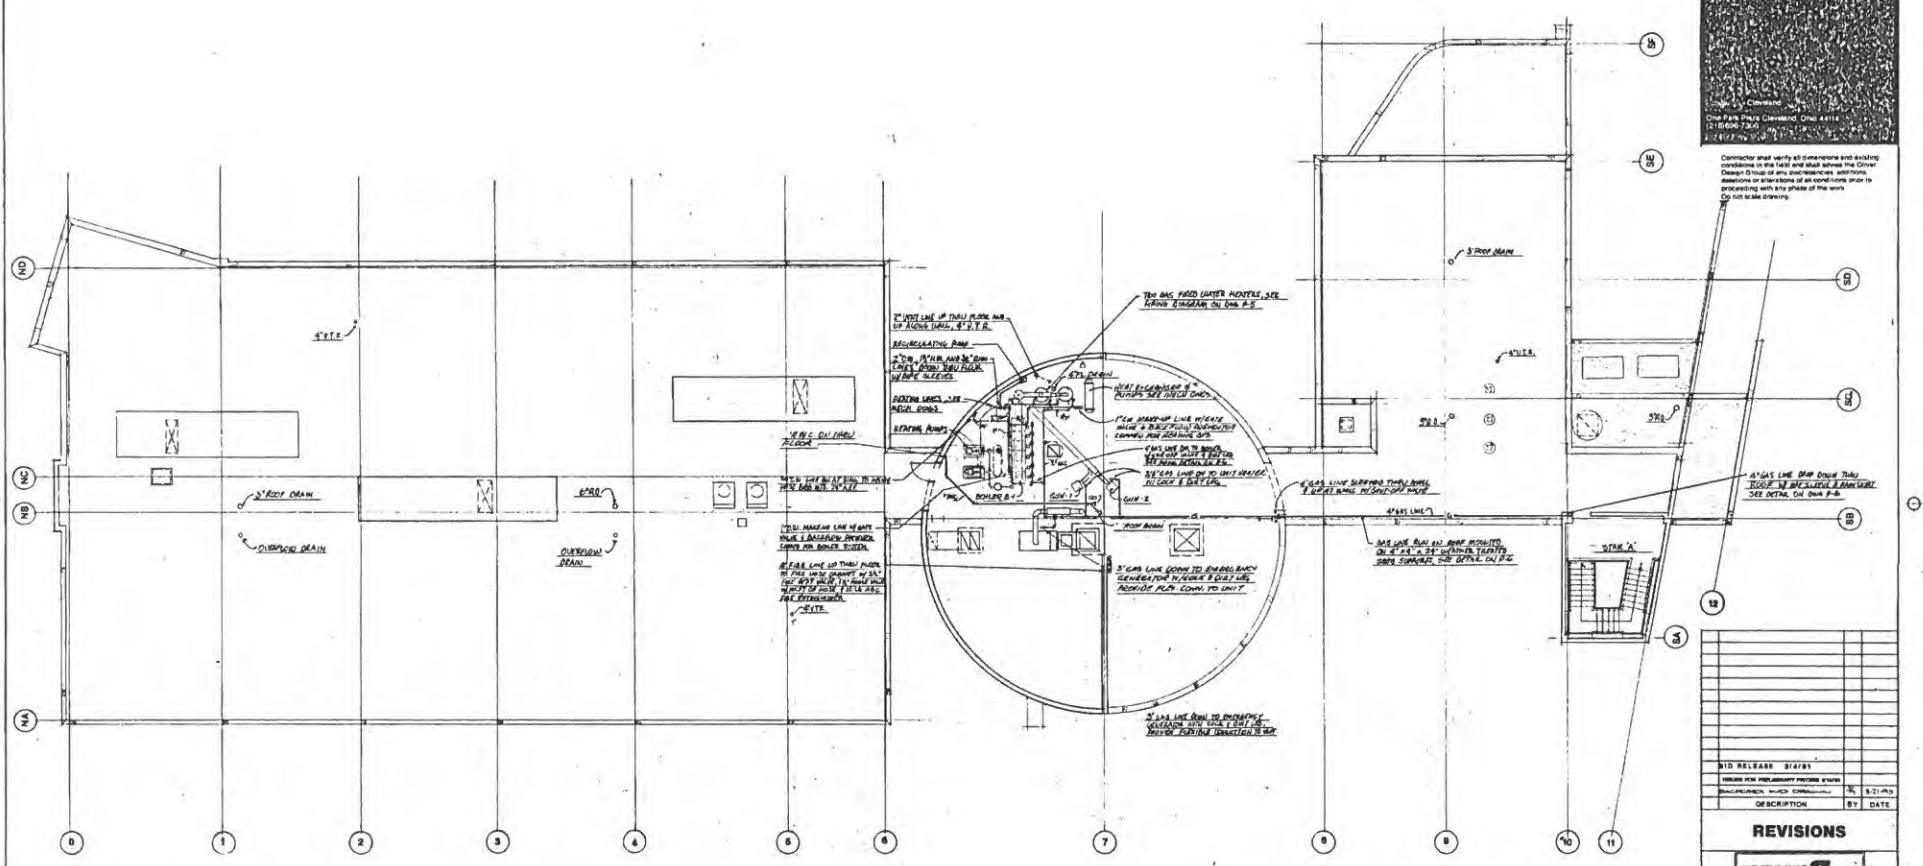

NO.	DATE	DESCRIPTION	BY	DATE

NO.	DATE	DESCRIPTION	BY	DATE

REVISIONS




ROOF AND PENTHOUSE PLAN PLUMBING




APPROVED DATE


67

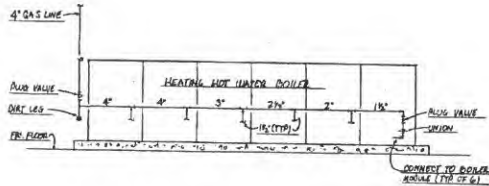


BOILER GAS PIPING DIAGRAM
NO SCALE

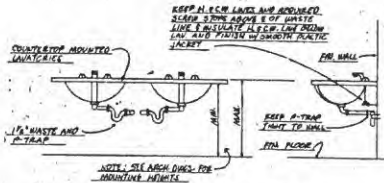


DETAIL AT LAVS
NO SCALE

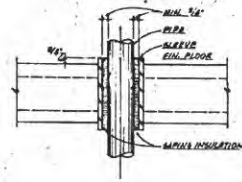


PIPE SLEEVE DETAIL
NO SCALE

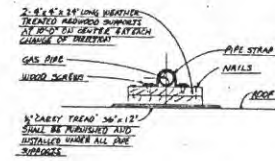


GAS PIPE SUPPORT DETAIL
NO SCALE

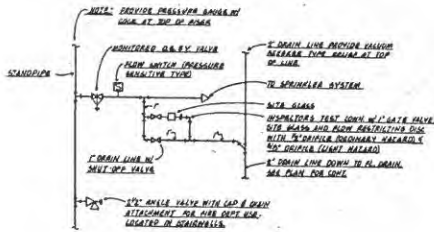


INSPECTORS TEST CONNECTION DETAIL
NO SCALE

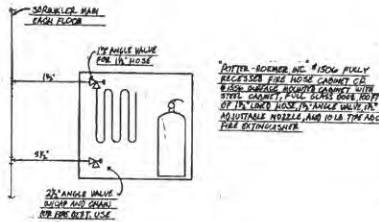

FIRE HOSE CABINET DETAIL
NO SCALE

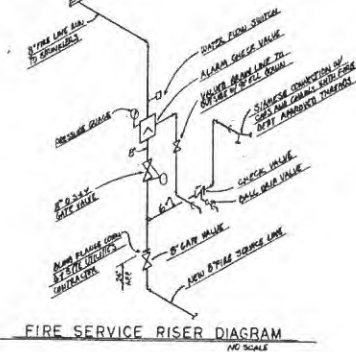

FIRE SERVICE RISER DIAGRAM
NO SCALE

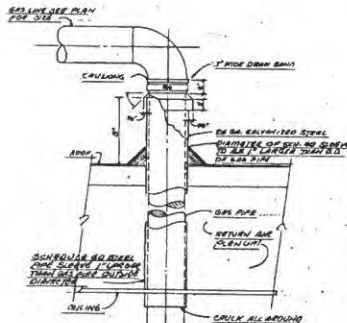

GAS PIPE SLEEVE DETAIL
NO SCALE

OLIVER DESIGN GROUP

Contractor shall verify all dimensions and existing conditions in the field and shall advise the Oliver Design Group of any discrepancies, additions, omissions or alterations to all conditions prior to proceeding with any phase of the work. Do not scale drawing.

BID RELEASE 3/1/01
VALID FOR PRELIMINARY PRICING STAFF
DESCRIPTION BY DATE

REVISIONS

Wayne Dalton

PLUMBING DETAILS & DIAGRAMS



PROJECT NO. 0007 SHEET 1 OF 6

SCALE AS NOTED
DRAWN MBE/KSD

ISSUE DATE

P-6

OSWALD & ASSOCIATES
PLUMBING & MECHANICAL
1001 1/2 STREET
NEW YORK, N.Y. 10007
212 462 1234

APPROVED

DATE