



OVERALL FLOOR PLAN
SCALE 1/32" = 1'-0"

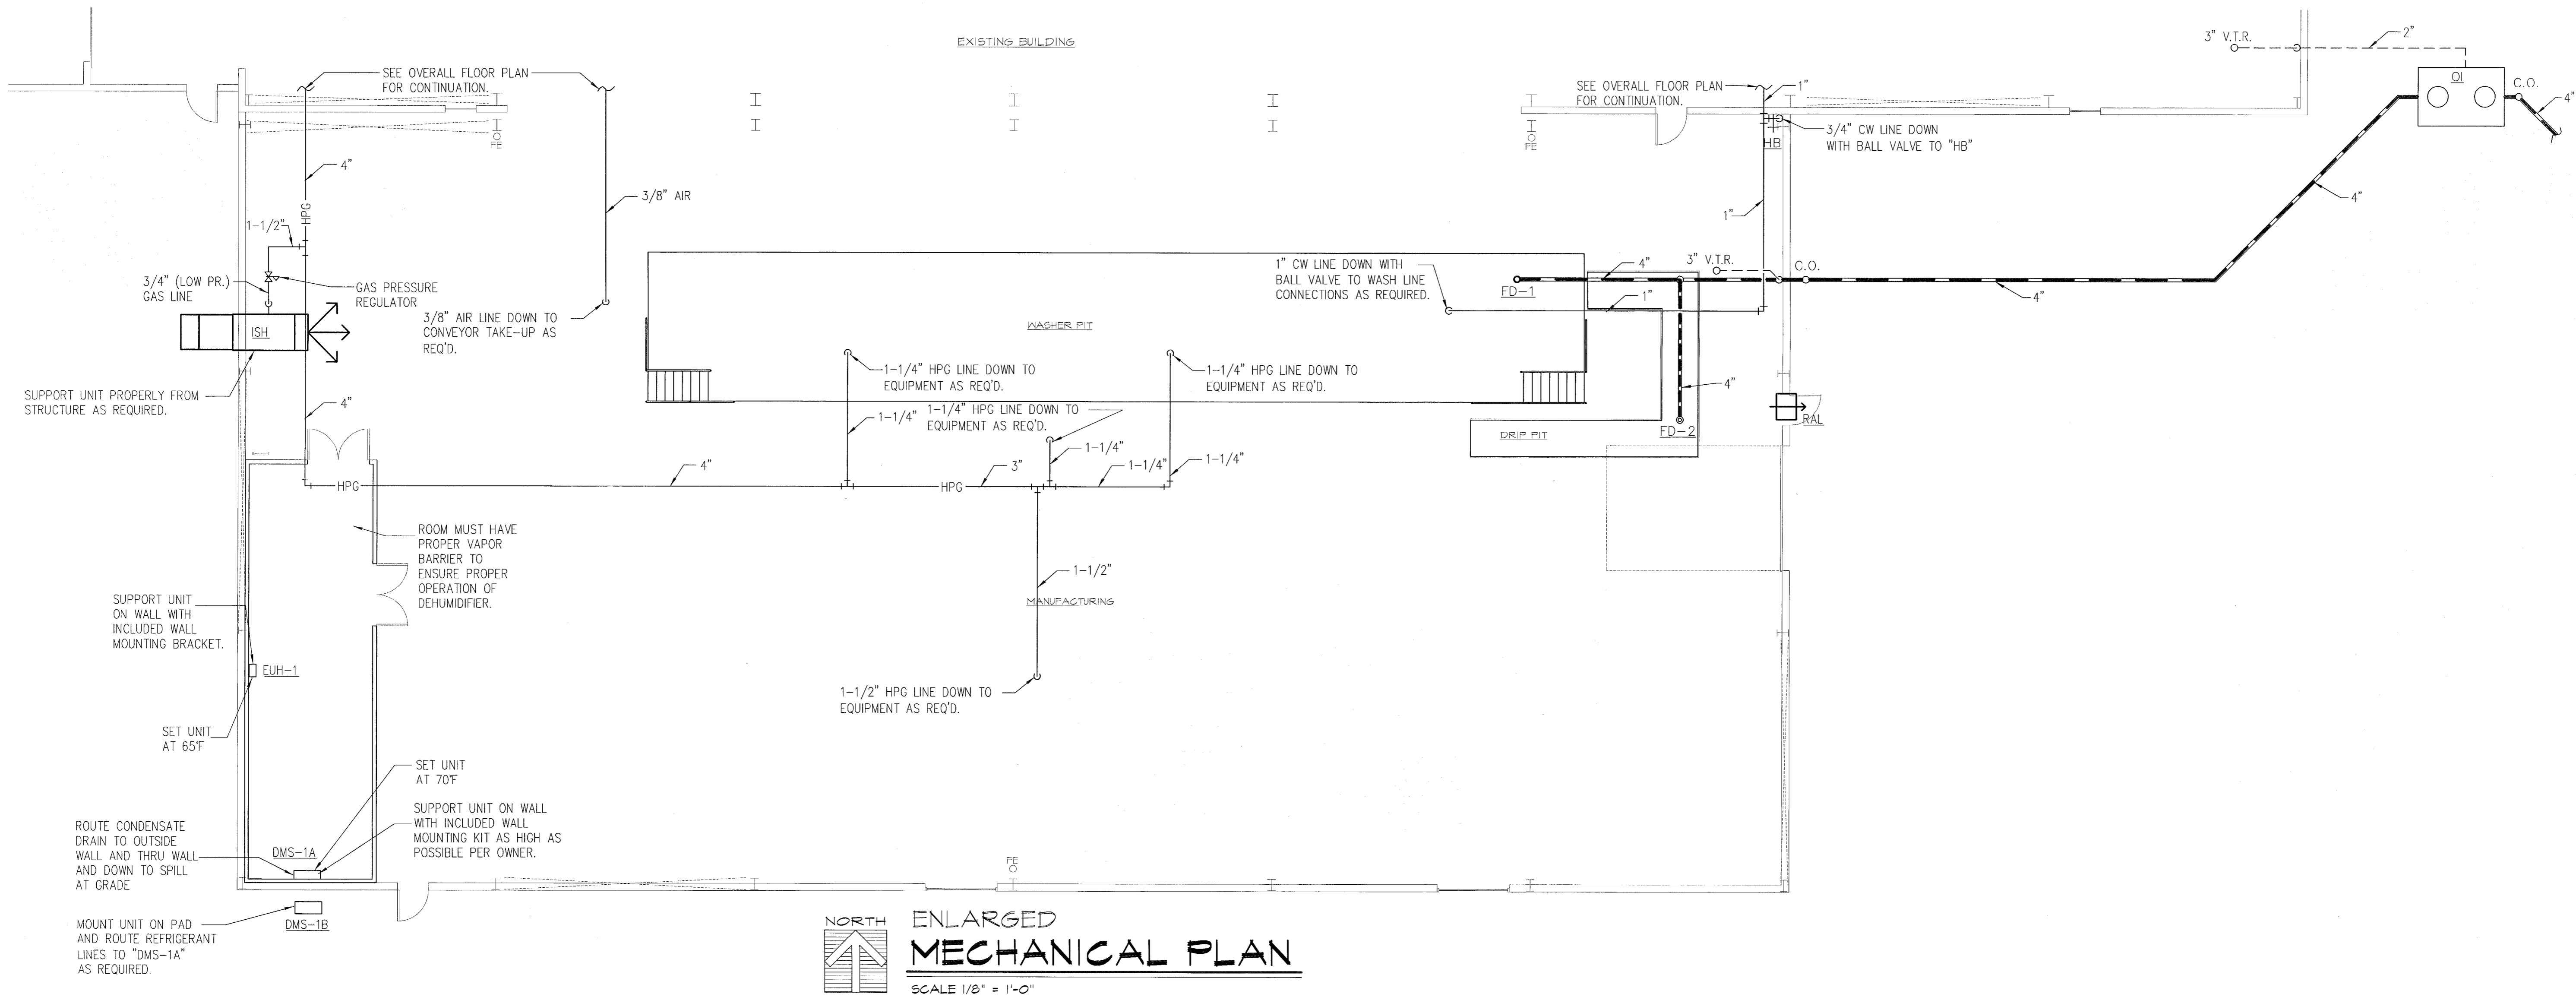


ENLARGED MECHANICAL PLAN
SCALE 1/8" = 1'-0"

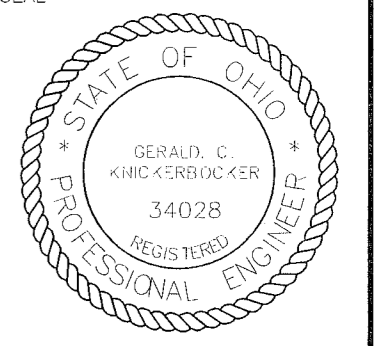


REVISIONS
FILE ...CONVING
DRAWN BY
DATE 8-29-11
DRAWING NO. M-1


2/21/2012 9:30:46 AM
M-1.DWG
11027 - CNC METAL PRODUCTS OWNER EQUIPMENT
2011004.1624

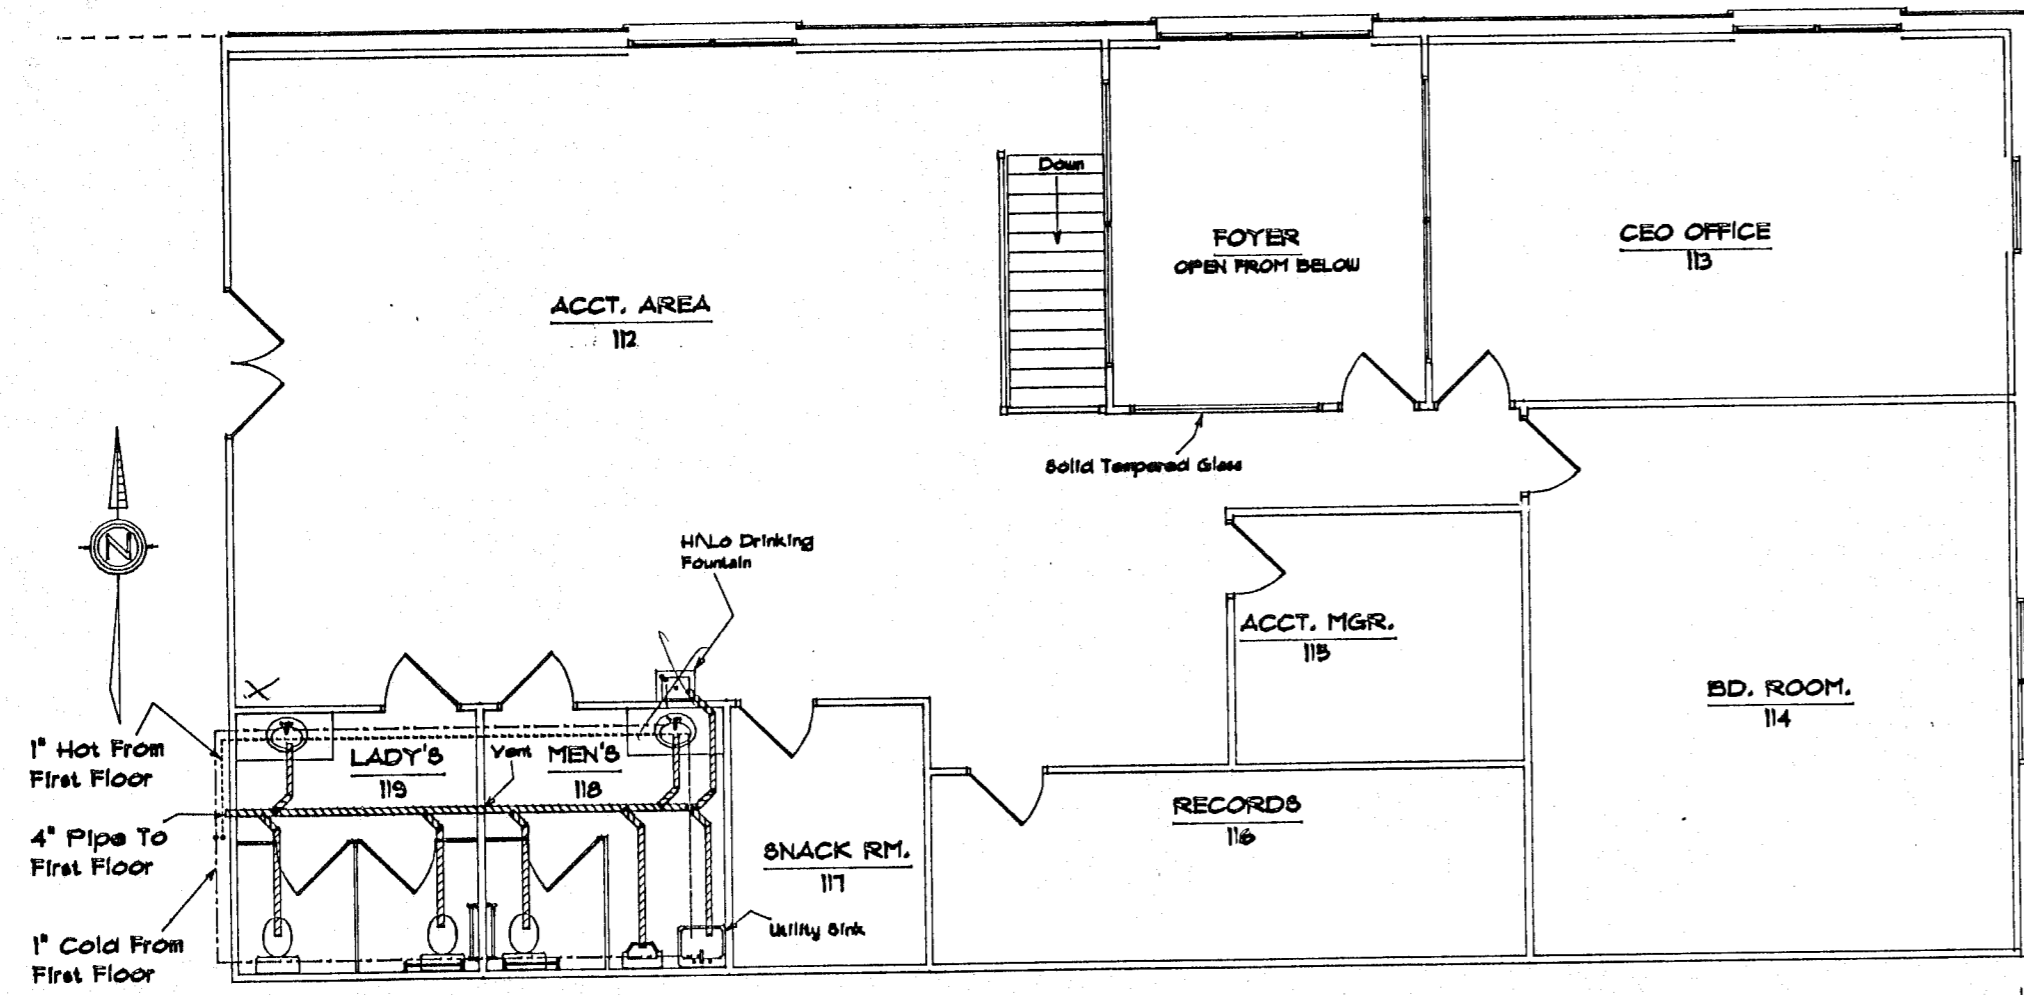

UPPER FLOOR PLUMBING

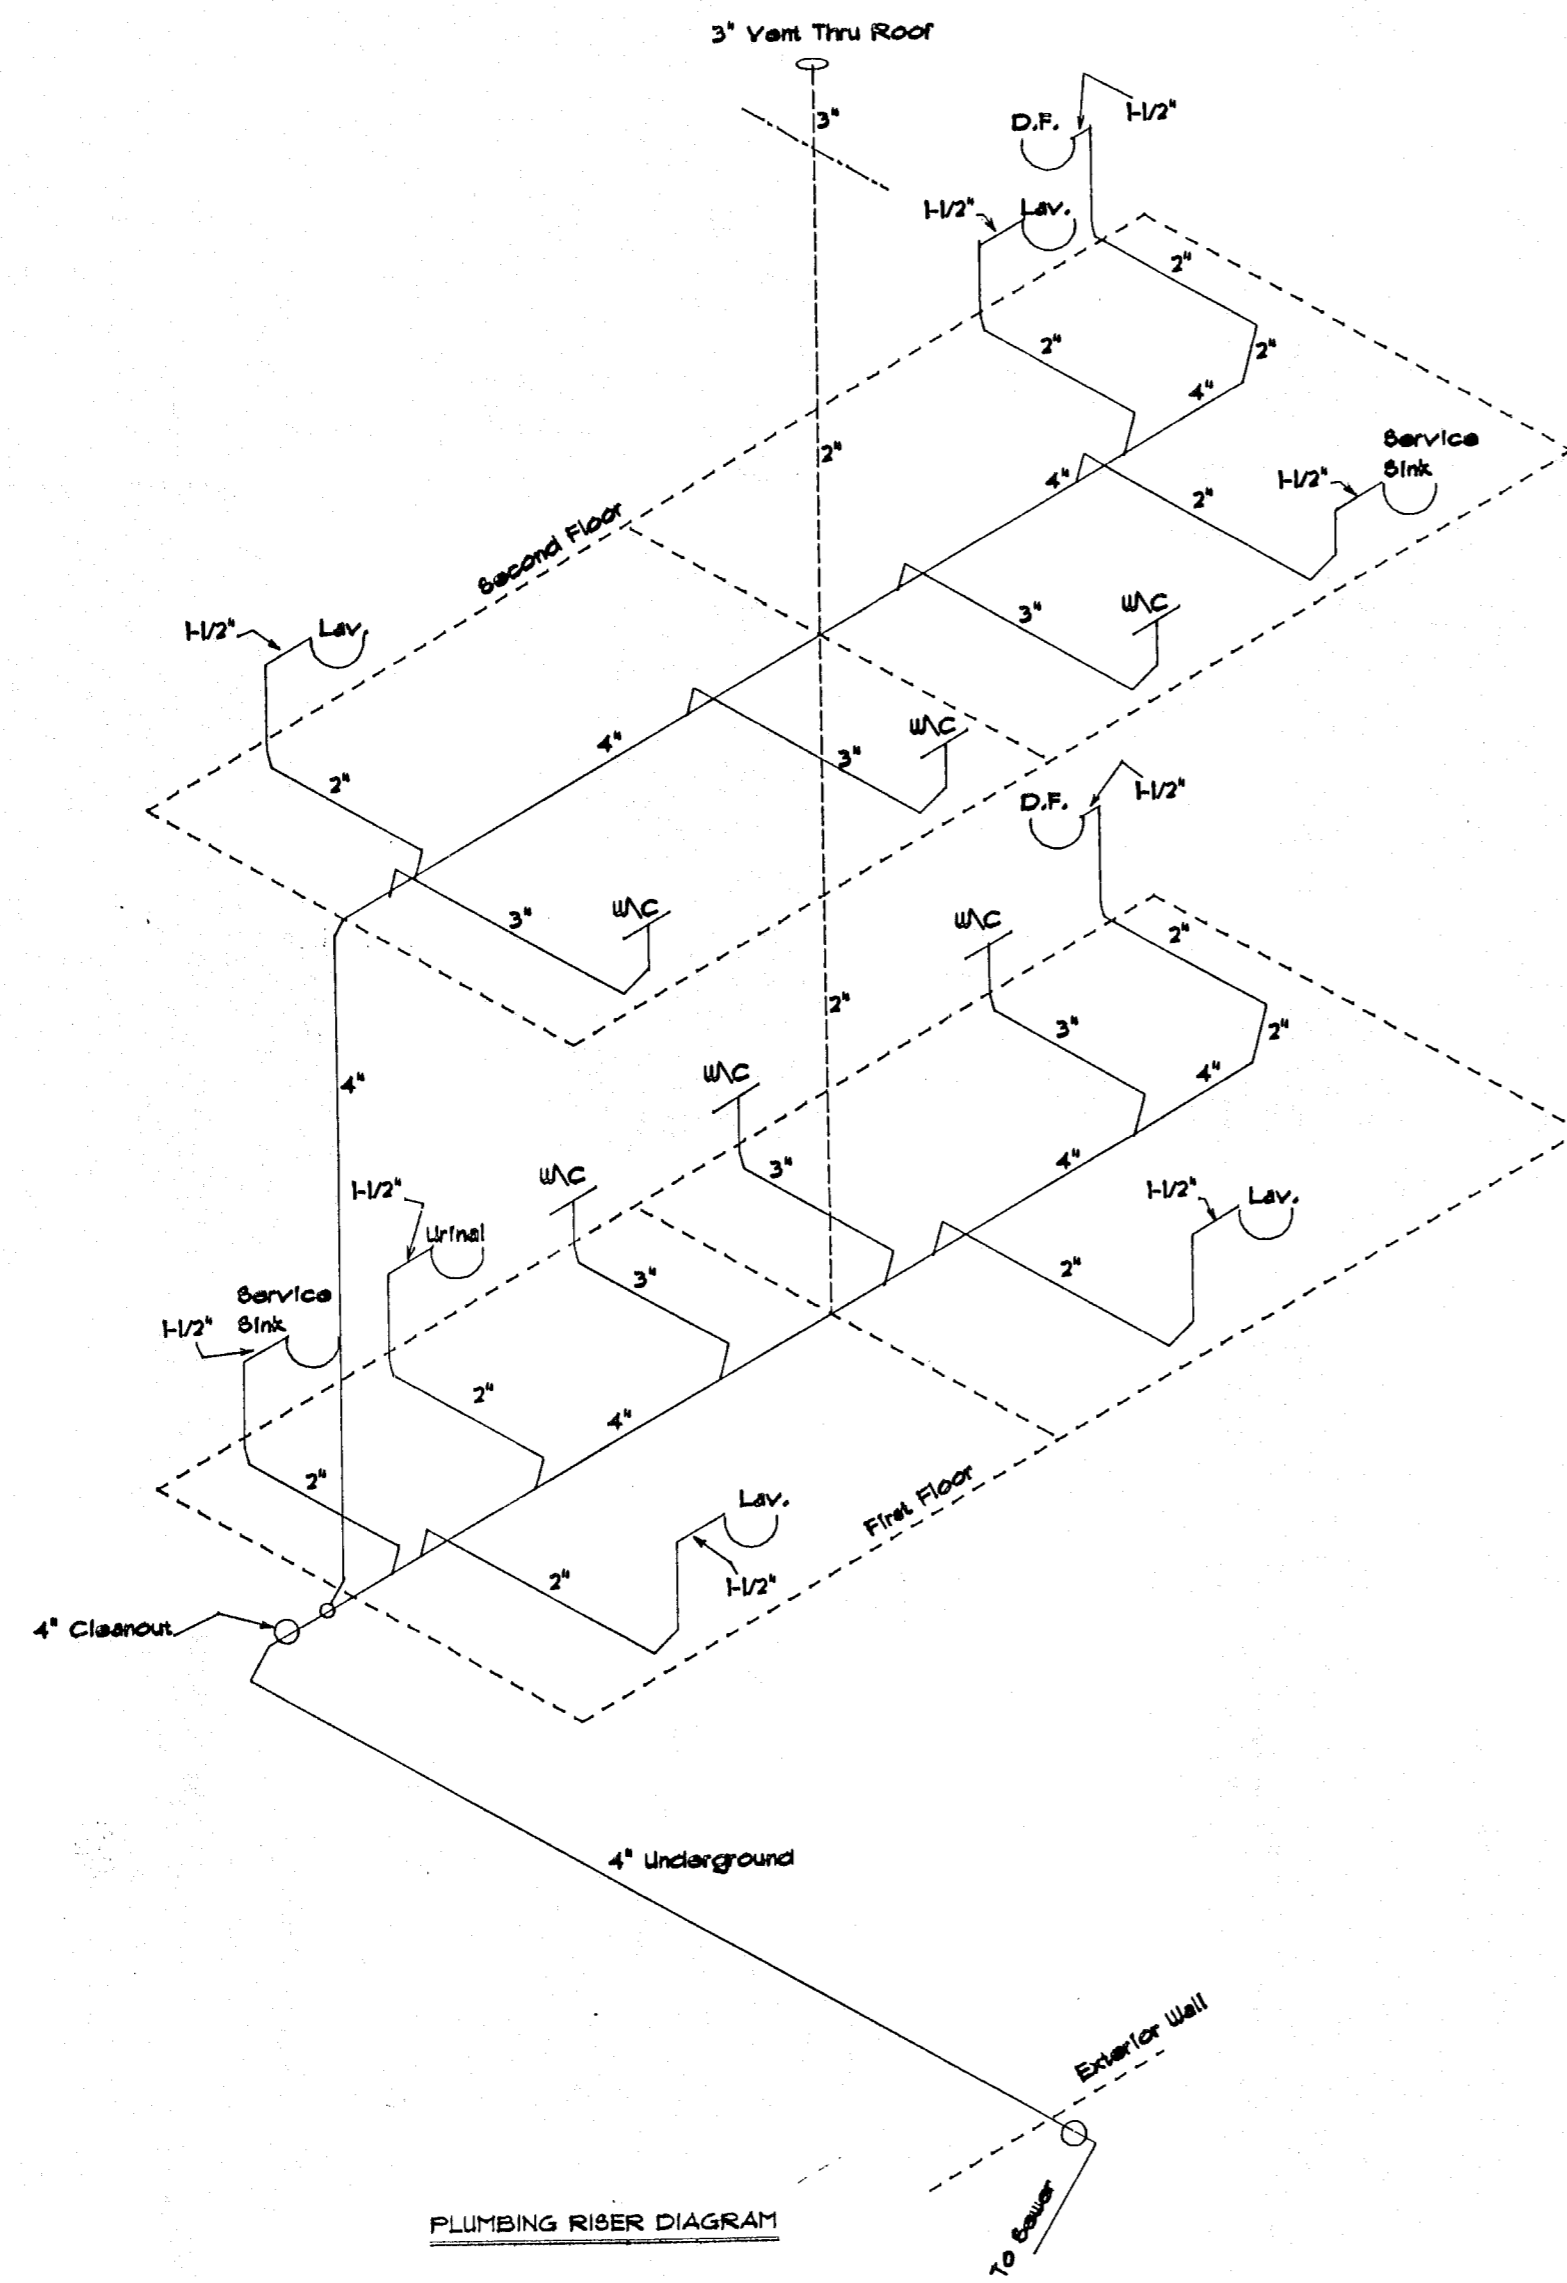

PLUMBING RISER DIAGRAM

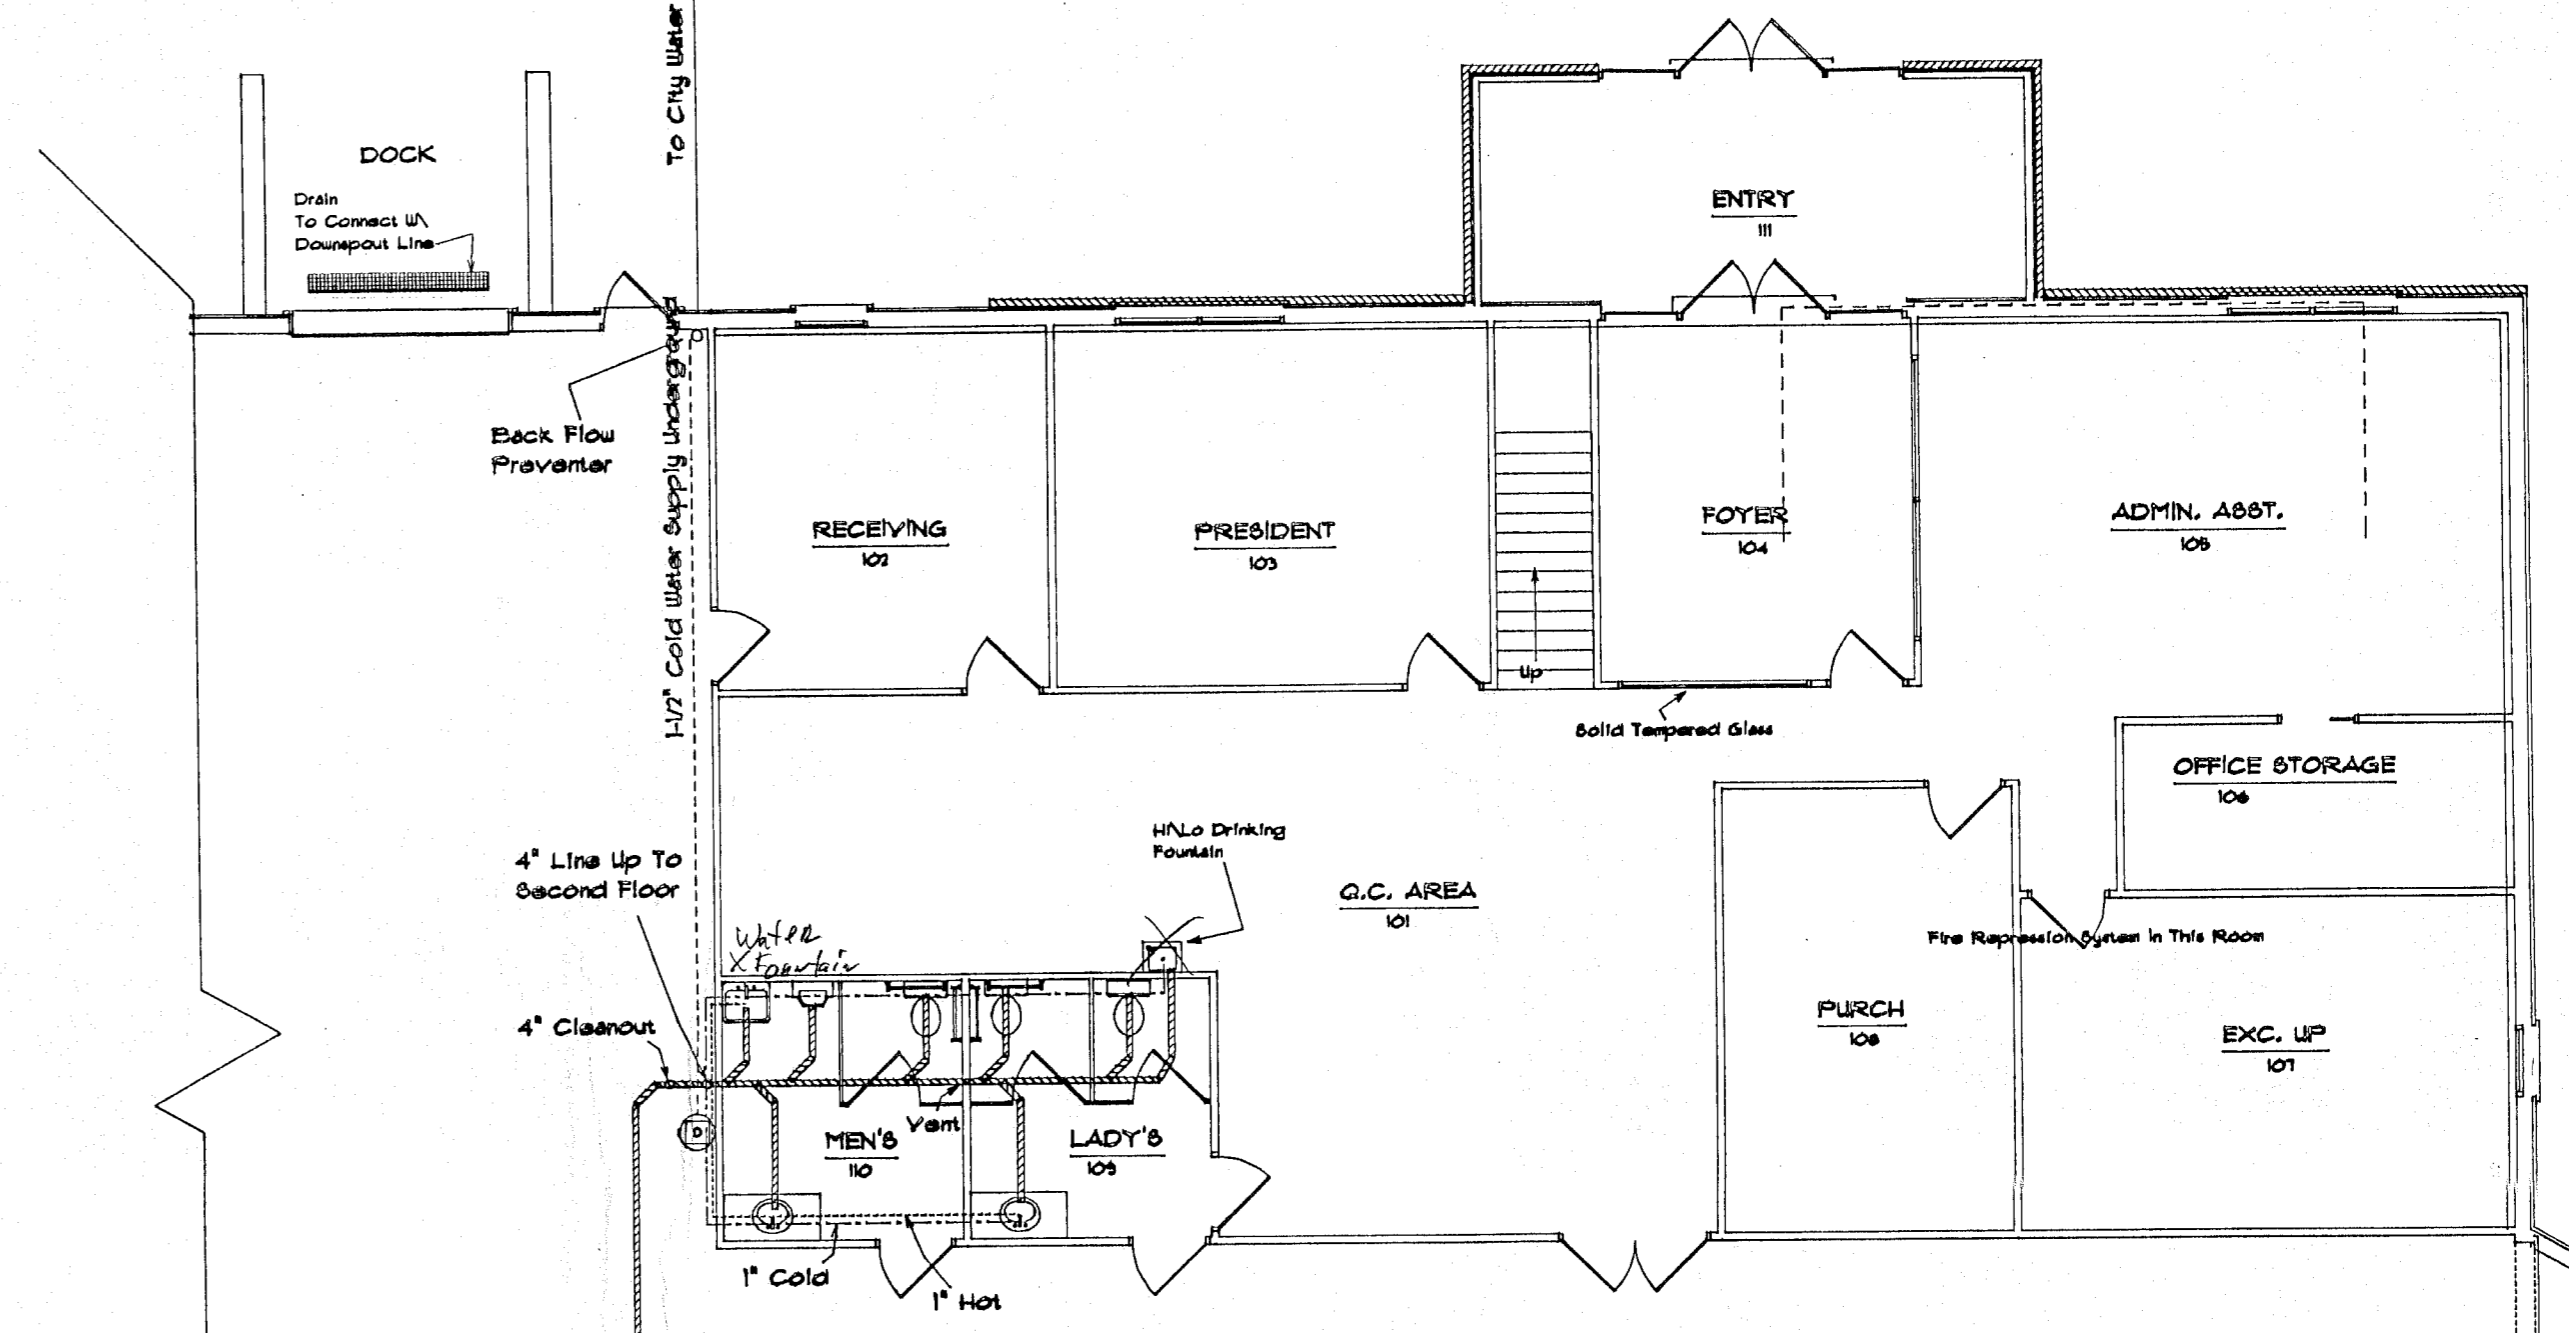

MAIN FLOOR PLUMBING

CNC META		
Drawn By:	Scale:	Date:
<i>BD</i>	1/8" = 1' 0"	07-16-99
Approved By:		
Subject:		MAIN FLOOR PL
BUCKEYE DRAFTING (330) 614-DRAW		